

**COUNTY OF EL DORADO, CA  
DEPARTMENT OF TRANSPORTATION**


**PROJECT PLANS FOR THE CONSTRUCTION OF  
HARVARD WAY AT CLERMONT WAY  
INTERSECTION IMPROVEMENTS**

IN THE COUNTY OF EL DORADO, DISTRICT 1  
ON HARVARD WAY FROM CLERMONT WAY TO SILVA VALLEY PARKWAY


To be supplemented with Standard Plans and Specifications dated 2022, including  
the 2022 Revised Standard Specifications, of the California Department of  
Transportation, unless otherwise noted.

**INDEX OF SHEETS**


SHEET	PLAN SHEET	TITLE
1		TITLE SHEET
2-3	CD-1 THRU CD-2	SURVEY CONTROL DIAGRAM
4-5	L-1 THRU L-2	LAYOUT
6	C-1	CONSTRUCTION DETAILS
7-11	SPD-1 THRU SPD-5	SIGNING AND PAVEMENT DELINEATION
12-15	SC-1 THRU SC-11	STAGE CONSTRUCTION
16-20	E-1 THRU E-5	SIGNAL AND LIGHTING DETAILS

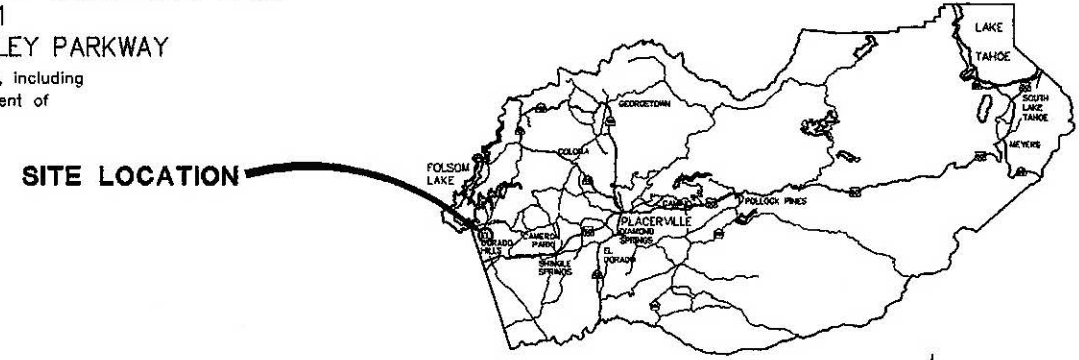

**VICINITY MAP**  
COUNTY OF EL DORADO

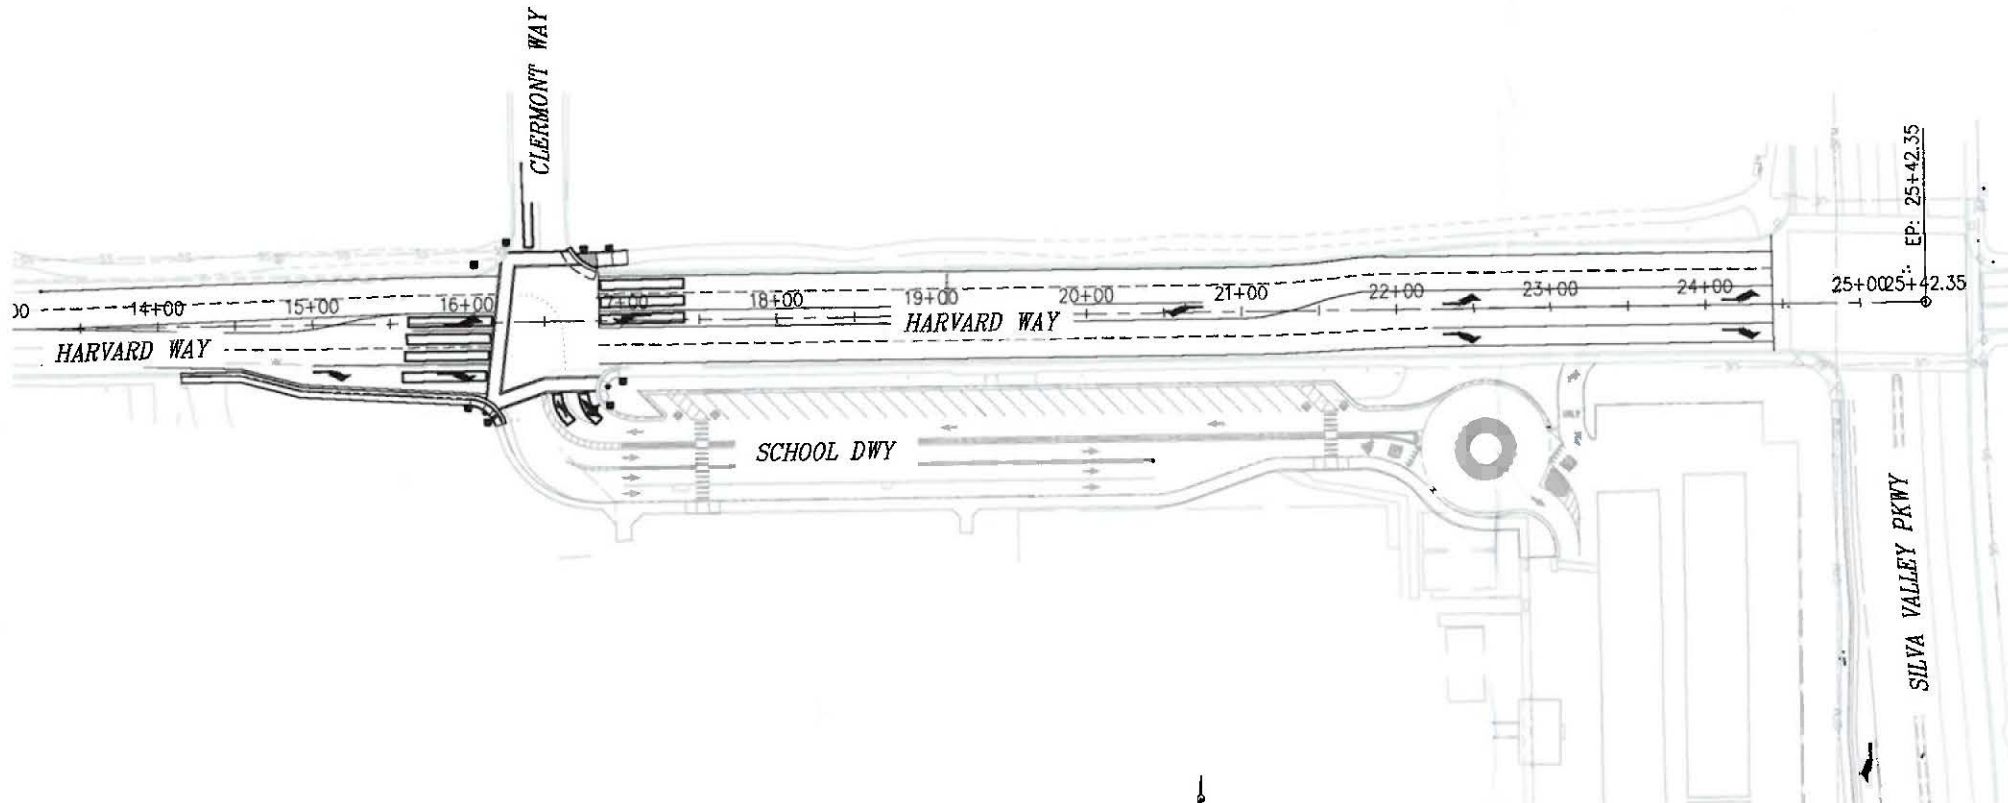

**SITE PLAN**  
1"=60'

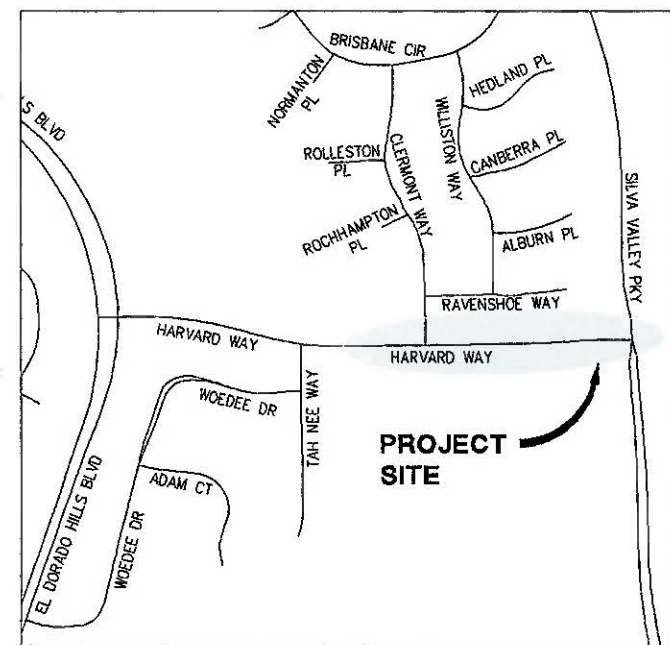

**LOCATION MAP**  
NOT TO SCALE

**BOARD OF SUPERVISORS**

I	JOHN HIDAHL
II	GEORGE TURNBOO
III	WENDY THOMAS
IV	LORI PARLIN
V	BROOKE LAINE

**COUNTY OF EL DORADO  
DEPARTMENT OF TRANSPORTATION**

(530) 621-5900  
2850 FAIRLANE CT  
PLACERVILLE, CA 95667

ADOPTED AND APPROVED BY: *Wendy Thomas* 3/13/24 DATE

WENDY THOMAS, CHAIR, EL DORADO COUNTY BOARD OF SUPERVISORS

APPROVED BY: *Mattew D. Snelzer* 3/13/24 DATE

RAFAEL MARTINEZ, DIRECTOR, DEPARTMENT OF TRANSPORTATION

MATTHEW D. SNELTZER, P.E. NO. C52632, DEPUTY DIRECTOR, ENGINEERING

CONTRACT NO. 8045 | CIP NO. 36105080

**HARVARD WAY AT CLERMONT WAY**

**TITLE SHEET**

SHEET 1 OF 20

CONTRACTOR'S LICENSE CLASSIFICATION: Bidders shall be properly licensed to perform the Work pursuant to the State Contractor's License Act (Business and Professions Code section 7000 et seq.) and shall possess a CLASS A LICENSE or equivalent combination of Classes required by the categories and type of Work included in the Contract Documents and Plans. Failure of the successful Bidder to obtain proper and adequate licensing at the time bids are submitted shall constitute a failure to execute the Contract, and forfeiture as provided under that section.

MARK	DATE	BY



SUBMITTED BY: \_\_\_\_\_ DATE \_\_\_\_\_  
CIVIL ENGINEER  
STATE OF CALIFORNIA NO. \_\_\_\_\_