

**INDEX OF SHEETS**



SHEET	PLAN SHEET	TITLE
1		TITLE SHEET
2	CD-1	SURVEY CONTROL DIAGRAM
3	X-1	TYPICAL SECTIONS
4-5	L-1 THRU L-2	LAYOUT
6-8	C-1 THRU C-3	CONSTRUCTION DETAILS
9	EC-1	EROSION CONTROL PLANS
10-11	SC-1 THRU SC-2	CONSTRUCTION AREA SIGNS
12	SC-3	CONSTRUCTION AREA SIGN QUANTITIES
13	SPD-1	PAVEMENT & SIGN DELINEATION
14	SPD-2	PAVEMENT & SIGN DELINEATION QUANTITIES
15-17	E-1 THRU E-3	MODIFY SIGNAL AND LIGHTING PLAN

**COUNTY OF EL DORADO, CA  
DEPARTMENT OF TRANSPORTATION**


**PROJECT PLANS FOR THE CONSTRUCTION OF  
SILVA VALLEY INTERSECTION  
IMPROVEMENTS AT HARVARD WAY**

IN THE COUNTY OF EL DORADO, DISTRICT I

To be supplemented with Standard Plans and Specifications dated 2018, including the 2018 Revised Standard Specifications, of the California Department of Transportation, unless otherwise noted.

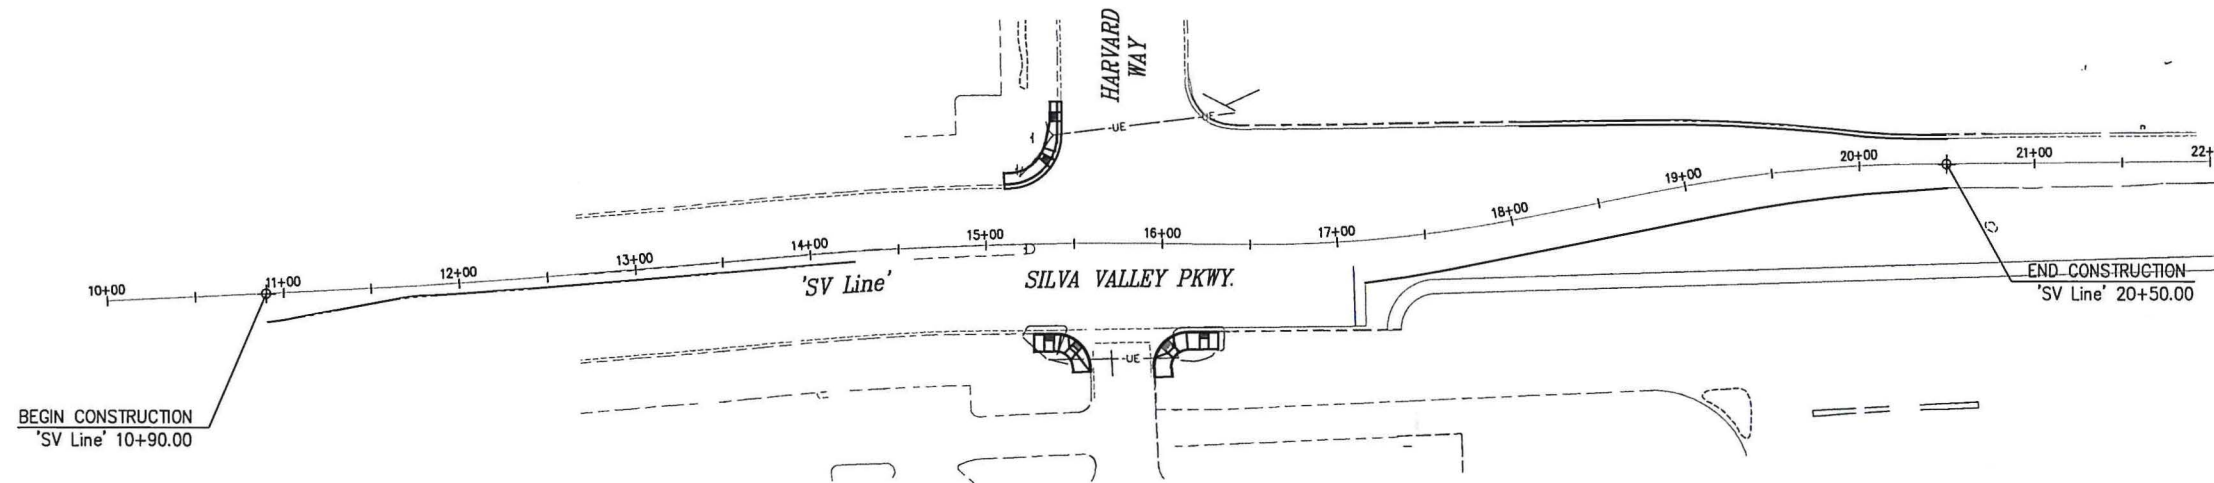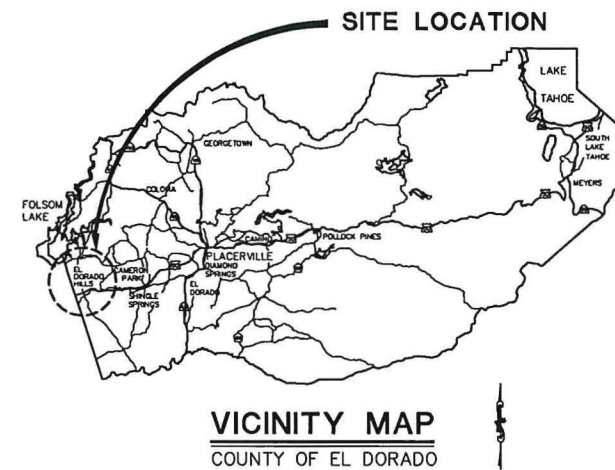

**SITE PLAN**  
SCALE: 1" = 50'

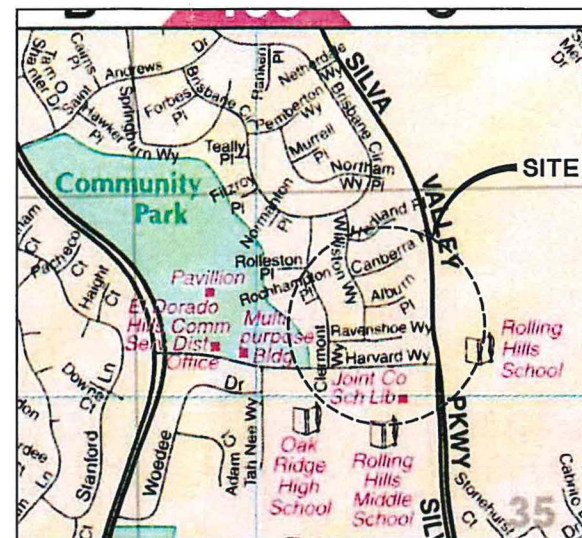

**LOCATION MAP**  
NOT TO SCALE

**FEDERAL AID PROJECT  
CML 5925 (149)**



SUBMITTED BY:  
BRIAN C. FRANKLIN  
STATE OF CALIFORNIA NO. C68952

*B. Franklin* 3/30/2021  
DATE

**BOARD OF SUPERVISORS**

I	JOHN HIDAHL
II	GEORGE TURNBOO
III	WENDY THOMAS
IV	LORI PARLIN
V	SUE NOVASEL

**COUNTY OF EL DORADO  
DEPARTMENT OF TRANSPORTATION**

(530) 621-5900  
2850 FAIRLANE CT  
PLACERVILLE, CA 95667

ADAPTED AND APPROVED BY: *[Signature]* DATE: 4/20/21

APPROVED BY: *[Signature]* DATE: 4/5/21

APPROVED BY: *[Signature]* DATE: 4/5/21

CONTRACT NO. 4546 PROJECT NO. 72378

**SILVA VALLEY INTERSECTION  
IMPROVEMENTS AT HARVARD WAY**

**TITLE SHEET**

SHEET 1 OF 17

CONTRACTOR'S LICENSE CLASSIFICATION: Bidders shall be properly licensed to perform the Work pursuant to the State Contractor's License Act (Business and Professions Code section 7000 et seq.) and shall possess a CLASS A LICENSE or equivalent combination of Classes required by the categories and type of Work included in the Contract Documents and Plans. Failure of the successful Bidder to obtain proper and adequate licensing at the time bids are submitted shall constitute a failure to execute the Contract, and forfeiture as provided under that section.

REVISIONS		
MARK	DATE	BY






COUNTY OF EL DORADO, CA  
DEPARTMENT OF TRANSPORTATION


PROJECT PLANS FOR THE CONSTRUCTION OF  
**MERRYCHASE/COUNTRY CLUB DRIVE IMPROVEMENTS**

IN THE COUNTY OF EL DORADO, DISTRICT 2  
ALONG MERRYCHASE DRIVE AND COUNTRY CLUB DRIVE FROM EL NORTE ROAD TO PLACITAS DRIVE


To be supplemented with Standard Plans and Specifications dated 2018, including the amendments to the 2018 Standard Specifications, of the California Department of Transportation, unless otherwise noted.

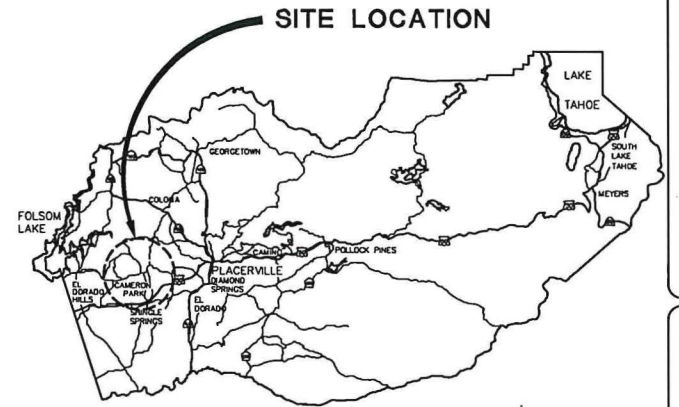

VICINITY MAP  
COUNTY OF EL DORADO

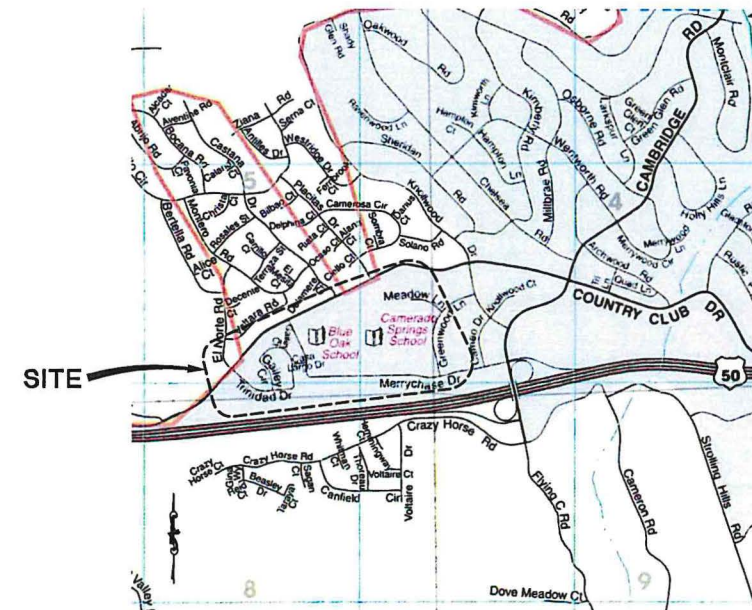

LOCATION MAP  
NOT TO SCALE

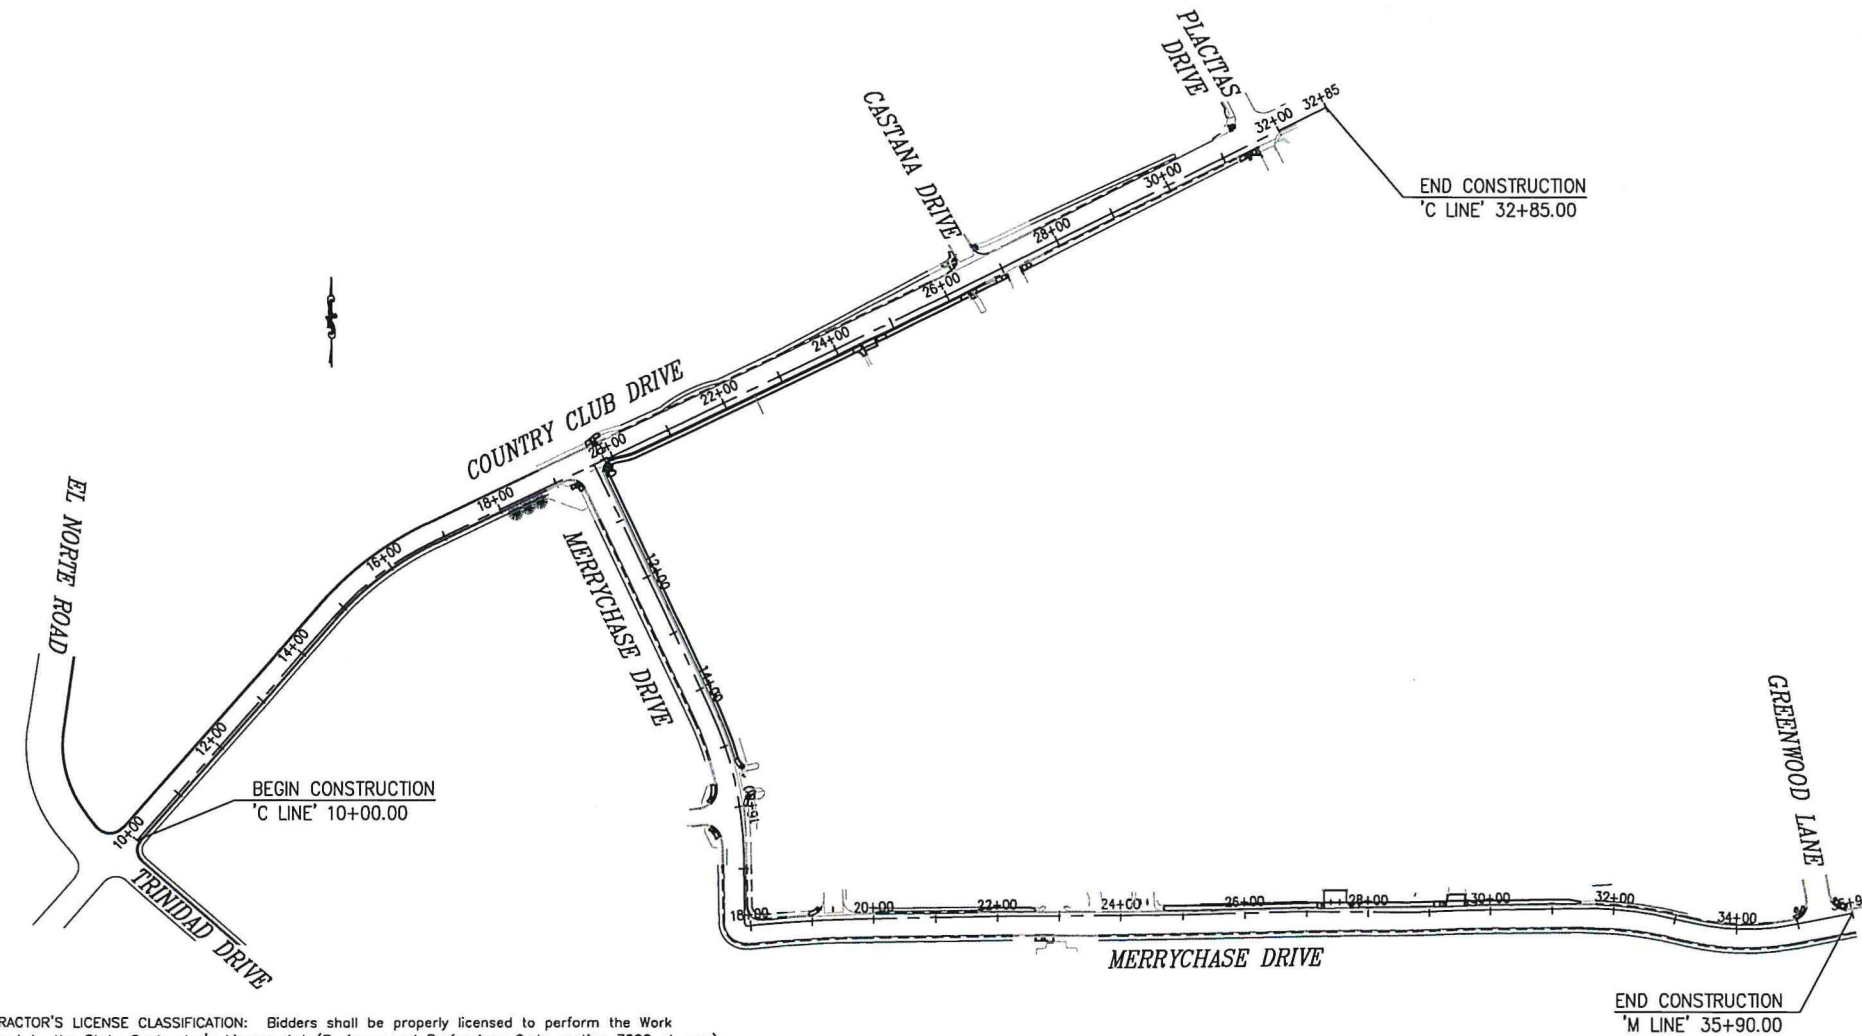

SITE PLAN  
SCALE: 1" = 150'

INDEX OF SHEETS

SHEET	PLAN SHEET	TITLE
1		TITLE SHEET
2-4	CD-1 thru CD-3	SURVEY CONTROL DIAGRAM
5	X-1	TYPICAL SECTIONS
6-9	L-1 thru L-4	LAYOUT PLAN & PROFILE
10-22	C-1 thru C-13	CONSTRUCTION DETAILS
23-24	C-14 thru C-15	QUANTITIES
25-29	SC-1 thru SC-5	CONSTRUCTION AREA SIGNS
30-33	EC-1 thru EC-4	EROSION CONTROL
34-38	SPD-1 thru SPD-5	SIGNING & STRIPING
39	SPD-6	SIGNING & STRIPING QUANTITIES
40-41	RW-1 thru RW-2	RETAINING WALL PLAN & PROFILE
42-43	E-1 thru E-2	ELECTRICAL PLAN

BOARD OF SUPERVISORS  
I JOHN HIDAHL  
II GEORGE TURNBOO  
III WENDY THOMAS  
IV LORI PARLIN  
V SUE NOVASEL

COUNTY OF EL DORADO  
DEPARTMENT OF TRANSPORTATION  
(530) 621-5900  
2850 FAIRLANE CT  
PLACERVILLE, CA 95667

ADOPTED AND APPROVED BY: *John Hidahl* DATE: 4/20/21  
CHIEF, EL DORADO COUNTY BOARD OF SUPERVISORS  
APPROVED BY: *Rafael Martinez* DATE: 4/15/21  
RAFAEL MARTINEZ, DIRECTOR  
DEPARTMENT OF TRANSPORTATION  
APPROVED BY: *Justin W. Harrington* DATE: 4/15/21  
JUSTIN W. HARRINGTON, REGISTERED PROFESSIONAL ENGINEER  
DEPUTY DIRECTOR, ENGINEERING

CONTRACT NO. 4546 PROJECT NO. 72312  
MERRYCHASE / COUNTRY CLUB DRIVE IMPROVEMENTS  
TITLE SHEET  
SHEET 1 OF 43

FEDERAL AID PROJECT  
CML 5925 (145)

CONTRACTOR'S LICENSE CLASSIFICATION: Bidders shall be properly licensed to perform the Work pursuant to the State Contractor's License Act (Business and Professions Code section 7000 et seq.) and shall possess a CLASS A LICENSE or equivalent combination of Classes required by the categories and type of Work included in the Contract Documents and Plans. Failure of the successful Bidder to obtain proper and adequate licensing at the time bids are submitted shall constitute a failure to execute the Contract, and forfeiture as provided under that section.

REVISIONS

MARK	DATE	BY



SUBMITTED BY: *Justin W. Harrington*  
CIVIL ENGINEER  
STATE OF CALIFORNIA NO. \_\_\_\_\_  
DATE: 4/2/2021