

INDEX OF SHEETS

No.	ROADWAY PLANS
1	TITLE SHEET
2-9	TYPICAL CROSS SECTIONS
10-18	LAYOUT
19-31	PROFILE AND SUPERELEVATION DIAGRAM
32-44	CONSTRUCTION DETAILS
45-53	EROSION CONTROL PLAN
54-59	CONTOUR GRADING
60-68	DRAINAGE PLAN
69-77	DRAINAGE PROFILE
78-81	DRAINAGE DETAILS
82-85	DRAINAGE QUANTITIES
86-94	UTILITY PLANS
95	CONSTRUCTION AREA SIGNS
96-97	STAGE CONSTRUCTION
98-122	TRAFFIC HANDLING PLAN AND DETAILS
123-128	TRAFFIC HANDLING QUANTITIES
129-136	DETOUR PLAN, DETAILS AND QUANTITIES
137-147	PAVEMENT DELINEATION PLAN AND DETAILS
148-151	PAVEMENT DELINEATION QUANTITIES
152-160	SIGN PLAN
161-164	SIGN DETAILS
165-169	SIGN QUANTITIES
170-173	SUMMARY OF QUANTITIES
174-184	RETAINING WALL PLAN AND DETAILS
185-205	ELECTRICAL PLANS

No. STRUCTURE PLANS

No.	STRUCTURE PLANS
<b>BRIDGE No. 25-0005 R/L</b>	
206-207	GENERAL PLAN
208	INDEX TO BRIDGE PLANS
209-210	STAGE CONSTRUCTION
211	FOUNDATION PLAN
212-215	ABUTMENT LAYOUT
216-220	ABUTMENT DETAILS
221-222	RETAINING WALLS
223-224	PIER LAYOUT
225-231	PIER DETAILS
232-233	TYPICAL SECTION
234	GIRDER LAYOUT
235-236	GIRDER DETAILS
237	CAMBER DIAGRAM
238-241	CROSS FRAME DETAILS
242-243	BEARING DETAILS
244-248	MISCELLANEOUS DETAILS
249	MISCELLANEOUS STEEL GIRDER DETAILS
250-252	STRUCTURE APPROACH TYPE
253	TUBULAR BICYCLE RAILING
254-259	LOG OF TEST BORINGS

**DEPARTMENT OF TRANSPORTATION  
COUNTY OF EL DORADO, CA**

**PROJECT PLANS FOR CONSTRUCTION ON  
STATE HIGHWAY  
IN EL DORADO COUNTY  
NEAR PLACERVILLE  
ON US 50 FROM 0.7 km WEST  
TO 1.2 km EAST OF THE US 50  
MISSOURI FLAT ROAD OVERCROSSING**

TO BE SUPPLEMENTED BY STANDARD PLANS DATED JULY 2004



DIST	COUNTY	ROUTE	KILOMETER POST TOTAL PROJECT	SHEET No.	TOTAL SHEETS
03	ED	50	22.9/25.1	1	259




EL DORADO COUNTY  
2850 FAIRLANE COURT  
PLACERVILLE, CA 95667

QUINCY ENGINEERING, INC  
3247 Ramos Circle  
Sacramento, CA 95827

The State of California or its officers or agents shall not be responsible for the accuracy or completeness of electronic copies of this plan sheet.

To get to the Caltrans web site, go to: <http://www.dot.ca.gov>

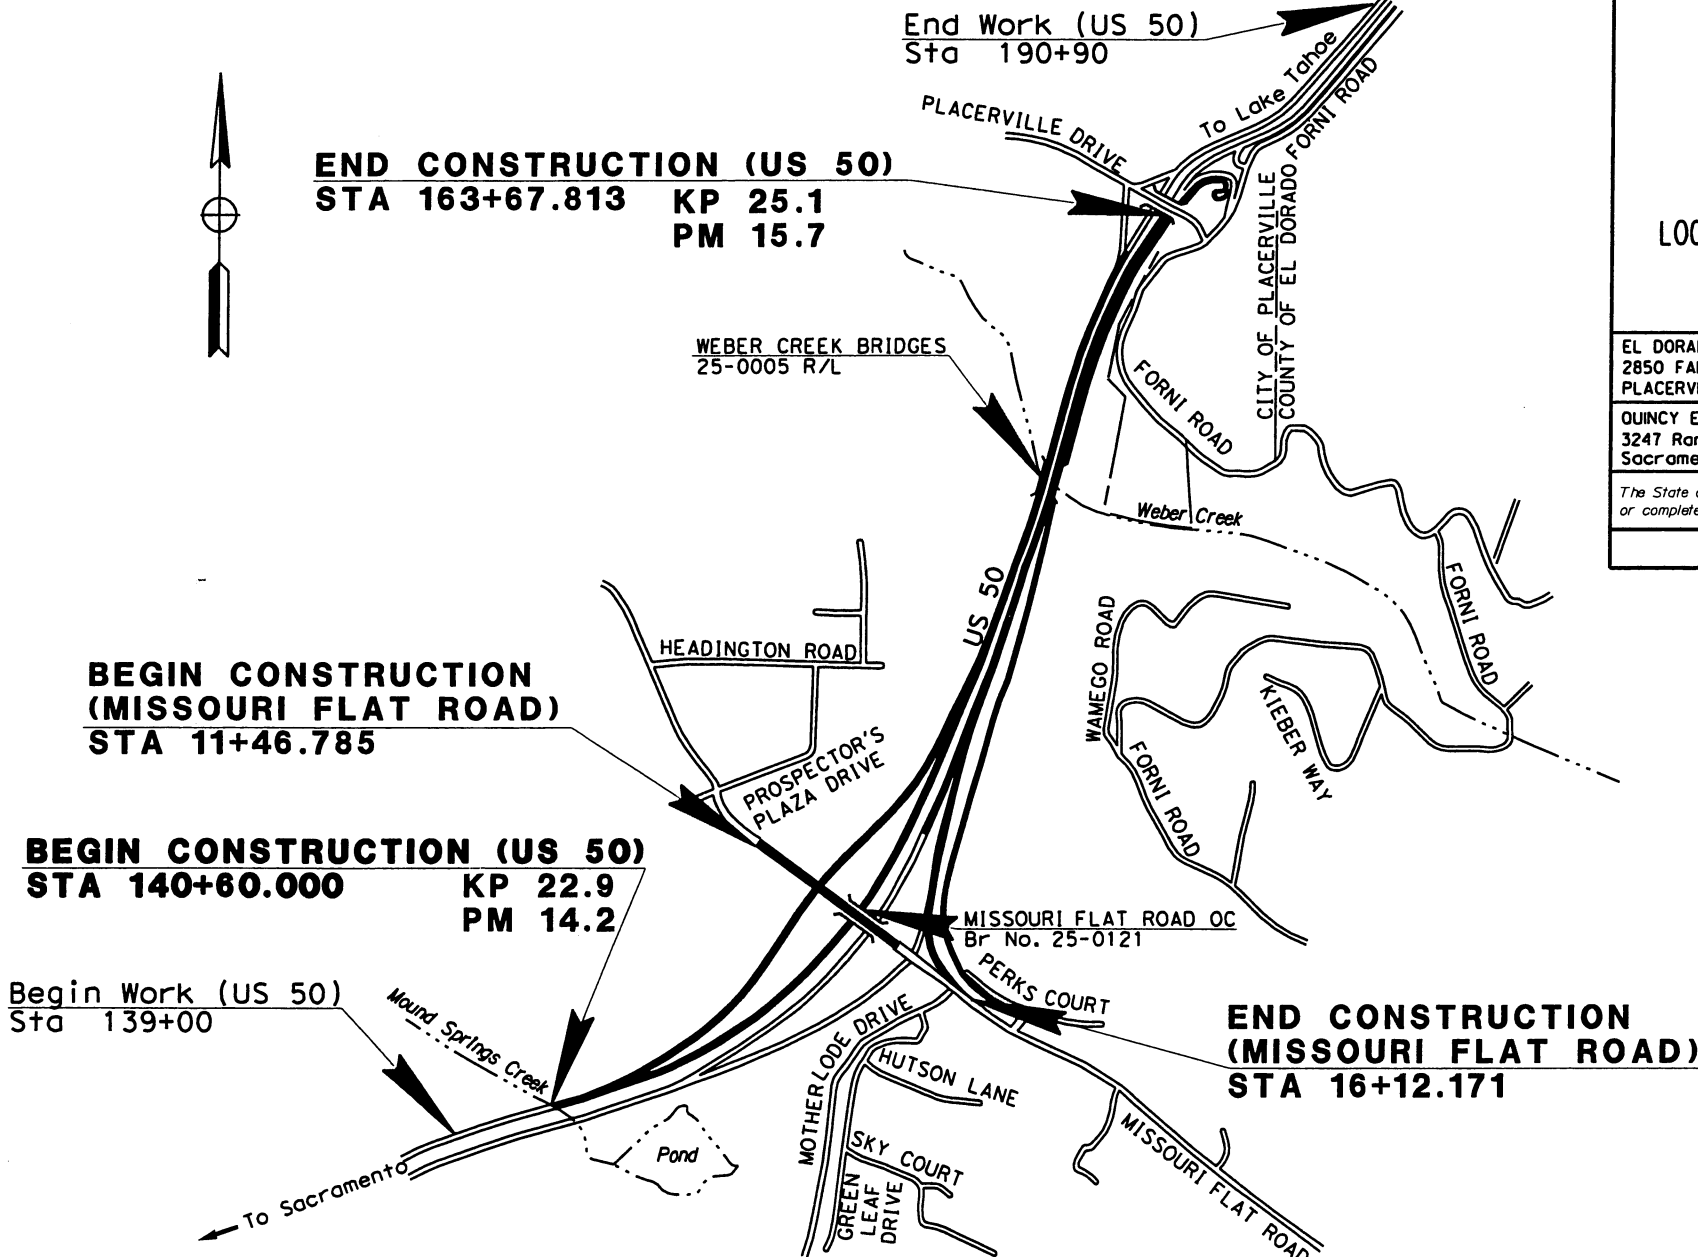

**BEGIN CONSTRUCTION (MISSOURI FLAT ROAD)**  
STA 11+46.785

**BEGIN CONSTRUCTION (US 50)**  
STA 140+60.000    KP 22.9  
PM 14.2

Begin Work (US 50)  
Sta 139+00

End Work (US 50)  
Sta 190+90

**END CONSTRUCTION (US 50)**  
STA 163+67.813    KP 25.1  
PM 15.7

**END CONSTRUCTION (MISSOURI FLAT ROAD)**  
STA 16+12.171

Approved as to impact on State facilities and conformance with applicable State standards and practices and that technical oversight was performed as described in the California Department of Transportation A & E Consultant Service Manual.

The Contractor shall possess the class (or classes) of license as specified in the "Notice to Contractors".

DESIGN OVERSIGHT APPROVAL  
PRINTED NAME: LYLE STOCKTON  
PROJECT ENGINEER: G. McLAUGHLIN

APPROVED AND ADDED BY: *[Signature]* 9/15/09  
DATE: 9/15/09


NON-BRIGGS  
CHAIRMAN, EL DORADO COUNTY BOARD OF SUPERVISORS  
APPROVED BY: *[Signature]* 9/14/07  
DATE: 9/14/07

JAMES M. WARE P.E. NO. 61036  
DIRECTOR, EL DORADO COUNTY DEPARTMENT OF TRANSPORTATION  
APPROVED BY: *[Signature]* 9/10/09  
DATE: 9/10/09

MATTHEW D. SWEETZER P.E. NO. 56972  
DEPUTY DIRECTOR OF ENGINEERING, EL DORADO COUNTY DEPT. OF TRANSPORTATION

**COUNTY OF EL DORADO  
DEPARTMENT OF TRANSPORTATION**

2850 FAIRLANE COURT  
PLACERVILLE, CA 95667  
(530) 621-5900

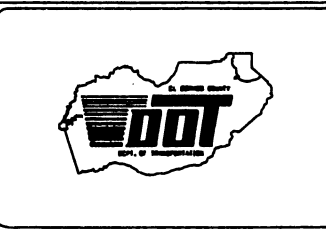

REVISIONS		
MARK	DATE	BY

BOARD OF SUPERVISORS	
JOHN R. KNIGHT	I
RAY NUTTING	II
JAMES R. SWEENEY	III
RON BRIGGS	IV
NORMA SANTIAGO	V

CU 03131
EA 03-4E28U4
COUNTY CONTRACT NO. 71366
CONTRACT NO. 03-4E28U4

*Alan P. Glen* 9/1/09  
Project Manager Date  
Registered Civil Engineer

September 15, 2009  
Plans Approval Date

