

INDEX OF SHEETS

SHEET NO.	PLAN SHEET	TITLE
1		TITLE SHEET & LOCATION MAP
2-11	X-1 to X-10	TYPICAL CROSS SECTIONS
12	CD-1	CONTROL DIAGRAM
13	K-1	KEY MAP
14-20	L-1 to L-7	PLAN AND PROFILE
21-22	SE-1 to SE-2	SUPER ELEVATION DIAGRAM
23-34	C-1 to C-12	CONSTRUCTION DETAILS
35-43	G-1 to G-9	CONTOUR GRADING PLAN
44-59	D-1 to D-16	DRAINAGE
60-68	U-1 to U-9	UTILITY PLAN
69-76	W-1 to W-8	WATERLINE PLAN
77-84	SC-1 to SC-8	STAGE CONSTRUCTION AND TRAFFIC HANDLING
85	CS-1	CONSTRUCTION AREA SIGNS
86-94	SPD-1 to SPD-9	SIGNING & PAVEMENT DELINEATION PLANS
95	Q-1	SUMMARY OF QUANTITIES
96-103	ECP-1 to ECP-8	EROSION CONTROL PLANS
104-108	E-1 to E-5	ELECTRICAL PLANS
109-123	S-1 to S-15	STRUCTURE PLANS


# DEPARTMENT OF TRANSPORTATION COUNTY OF EL DORADO, CA



*Richard W. Shepard*  
REGISTERED CIVIL ENGINEER  
10/18/06  
PLANS / APPROVAL DATE  
COUNTY OF EL DORADO  
PLACERVILLE, CA. 95667  
Dokken Engineering  
550 Main Street, Suite G-1  
Placerville, CA 95667 (530) 295-1080

## PROJECT PLANS FOR CONSTRUCTION OF IMPROVEMENTS IN EL DORADO COUNTY FOR LATROBE ROAD REALIGNMENT, WIDENING AND BRIDGE PROJECT SUNCAST Ln TO GOLDEN FOOTHILL Pkwy CONTRACT 72403

To be supplemented by State of California Department of Transportation Standard Plans dated July 2002, County of El Dorado Design and Improvement Standards Manual dated March 1994 and El Dorado Irrigation District Water, Sewer and Recycled Water Standards.

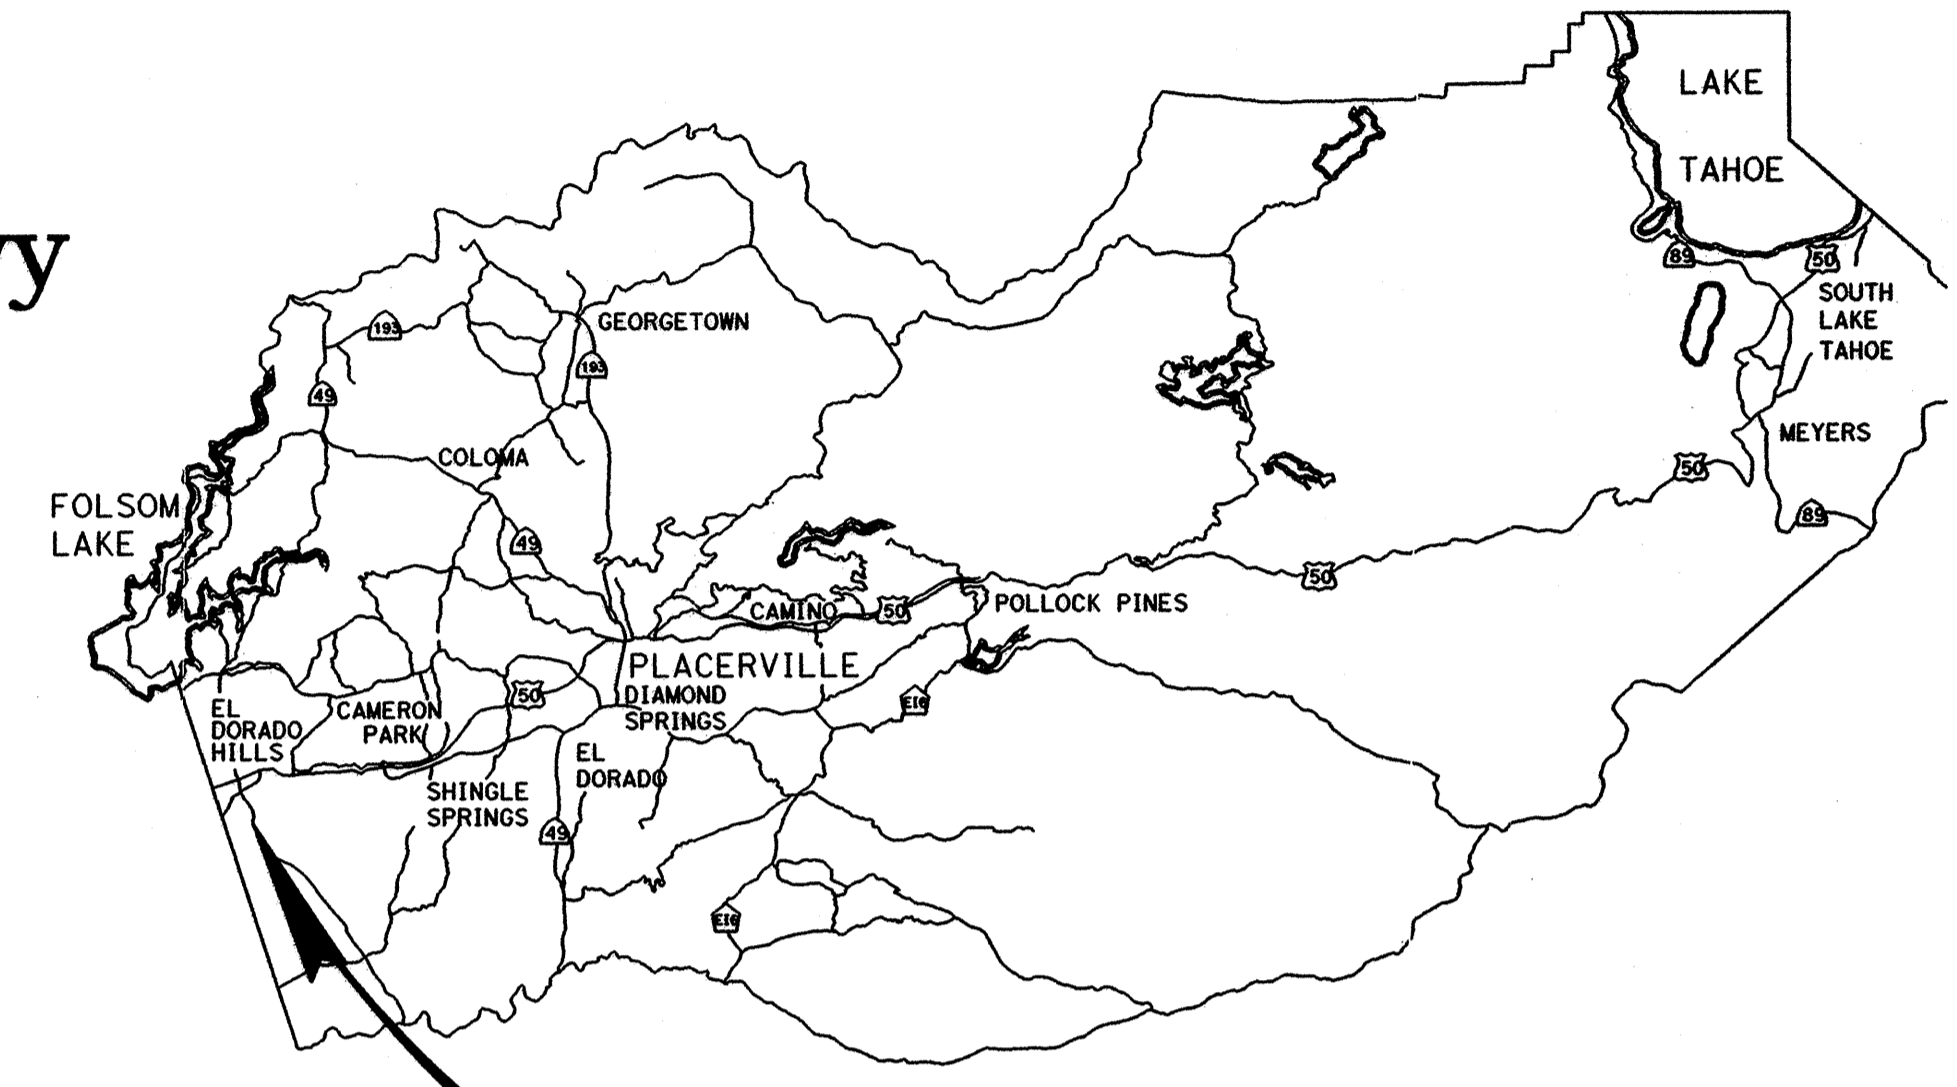

LOCATION MAP

SITE LOCATION

**PROJECT LIMITS  
STA'L'113+40.000**

Begin Work  
Sta 'L' 112+40

Limit of Work (Old Latrobe Rd)  
Sta 'E' 11+00

← To El Dorado Hills

**PROJECT LIMITS  
STA'S' 2+26.651**

SUNCAST LANE  
ENTRANCE No. 2

Begin Work  
Sta 'S' 1+00

El Dorado County

LATROBE ROAD

GOLDEN FOOTHILL  
PARKWAY  
ENTRANCE No. 3

INVESTMENT BLVD.  
ENTRANCE No. 4

**PROJECT LIMITS  
STA'L'145+33**

End Work  
Sta 'L' 146+00


→ To Latrobe

NOTES:

1. RELOCATE EXISTING FENCES WHERE REQUIRED.
2. PARCEL NUMBERS SHOWN ON UTILITY SHEETS.

LEGEND

ROAD CONSTRUCTION

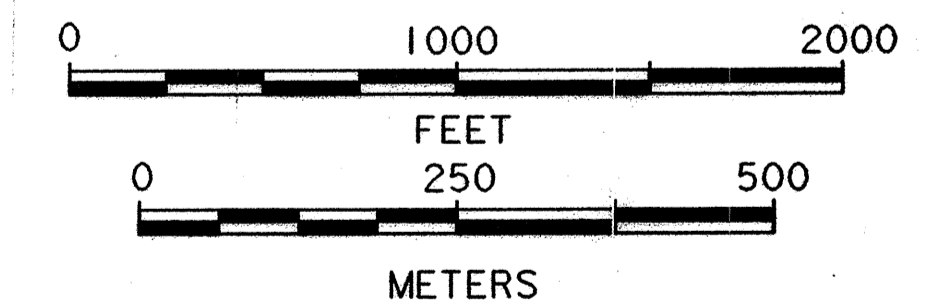


THE CONTRACTOR SHALL POSSESS THE CLASS (OR CLASSES) OF LICENSE AS SPECIFIED IN THE "NOTICE TO CONTRACTORS"

APPROVED BY:

JAMES SWEENEY  
CHAIRMAN, EL DORADO COUNTY BOARD OF SUPERVISORS  
*[Signature]* 10/26/06  
RICHARD W. SHEPARD, P.E. No. C35439  
DIRECTOR, EL DORADO COUNTY DEPARTMENT OF TRANSPORTATION  
RUSSELL NYGAARD, P.E. No. C59689  
DEPUTY DIRECTOR, EL DORADO COUNTY DEPARTMENT OF TRANSPORTATION  
*[Signature]* 10-20-2006

COUNTY OF EL DORADO  
DEPARTMENT OF TRANSPORTATION

2850 FAIRLANE COURT  
PLACERVILLE, CA 95667  
(530) 621-5900

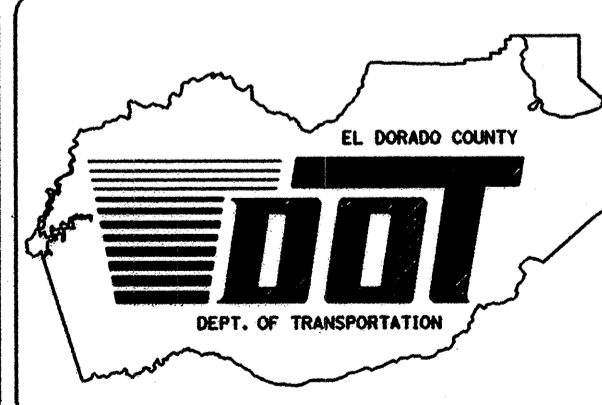

REVISIONS

MARK	DATE	BY

BOARD OF SUPERVISORS  
RUSTY DUPRAY I  
HELEN BAUMANN II  
JAMES SWEENEY III  
VACANT IV  
NORMA SANTIAGO V

LATROBE ROAD  
REALIGNMENT, WIDENING  
& BRIDGE PROJECT  
PHASE II  
**TITLE SHEET**  
SHEET 1 OF 123