

INDEX OF SHEETS


SHEET	PLAN SHEET	TITLE
1		TITLE SHEET
2-10	CD-1 THRU CD-9	SURVEY AND CONTROL DIAGRAM
11-13	X-1 THRU X-3	TYPICAL SECTIONS
14-29	L-1 THRU L-16	LAYOUT
30-60	C-1 THRU C-31	CONSTRUCTION DETAILS
61-64	D-1 THRU D-4	DRAINAGE
65-70	SPD-1 THRU SPD-6	SIGNING AND PAVEMENT DELINEATION
71-73	E-1 THRU E-3	ELECTRICAL PLANS
74	CS-1	CONSTRUCTION AREA SIGNS
75-79	TR-1 THRU TR-5	TREE REMOVAL
80-83	EC-1 THRU EC-4	EROSION CONTROL
84-87	RW-1 THRU RW-4	RETAINING WALLS

COUNTY OF EL DORADO, CA  
DEPARTMENT OF TRANSPORTATION


PROJECT PLANS FOR THE CONSTRUCTION OF  
**PONY EXPRESS TRAIL BICYCLE,  
PEDESTRIAN AND ADA IMPROVEMENTS**

IN THE COUNTY OF EL DORADO, DISTRICT V  
IN THE TOWN OF POLLOCK PINES, ON PONY EXPRESS TRAIL, BETWEEN SANDERS DR AND SLY PARK RD


To be supplemented with Standard Plans and Specifications dated 2022, including the 2022 Revised Standard Specifications, of the California Department of Transportation, unless otherwise noted.

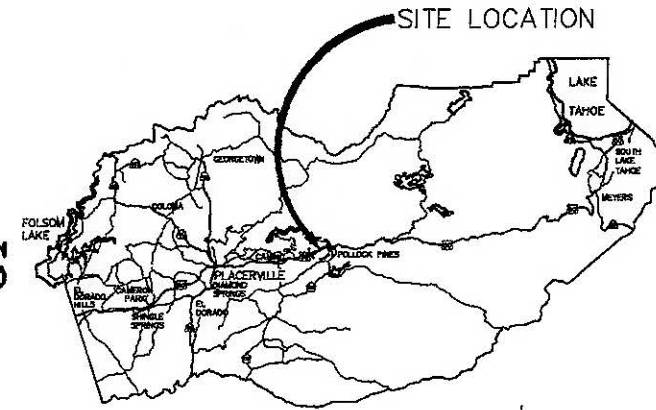

VICINITY MAP  
COUNTY OF EL DORADO

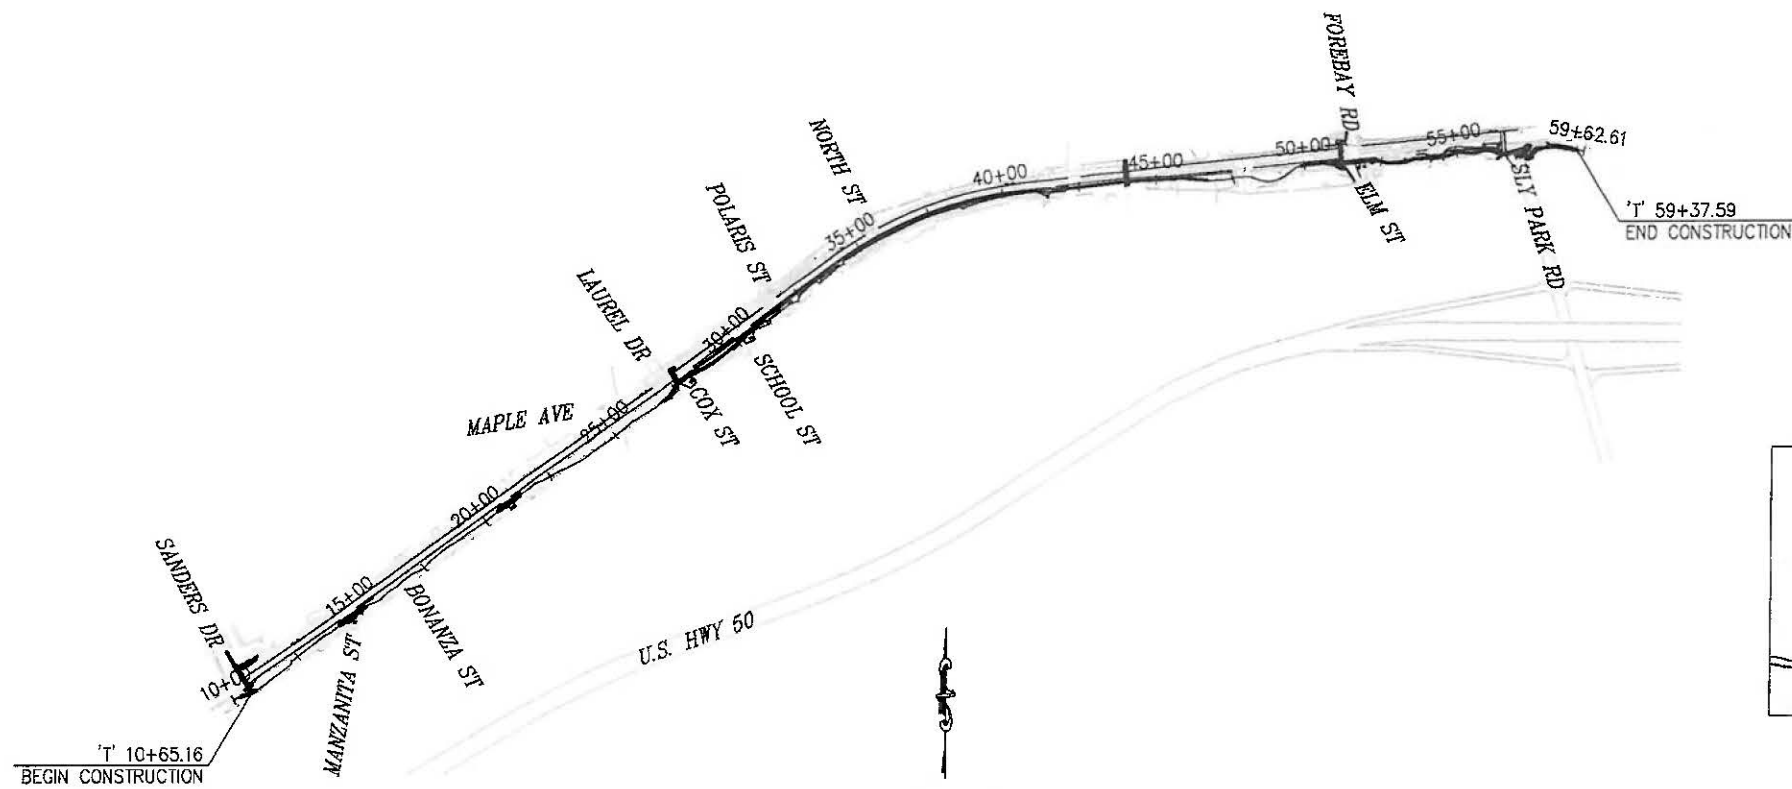

SITE PLAN  
SCALE: 1"=300'

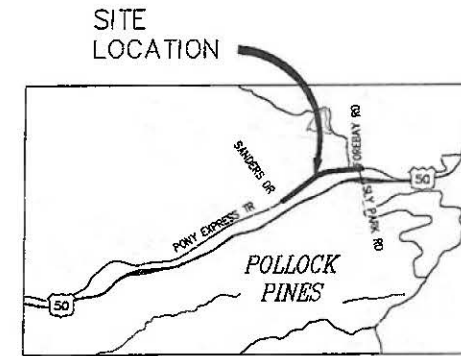

LOCATION MAP  
NOT TO SCALE

FEDERAL AID PROJECT  
CML 5925 (176)

BOARD OF SUPERVISORS  
I JOHN HIDAH  
II GEORGE TURNBOO  
III WENDY THOMAS  
IV LORI PARLIN  
V BROOKE LAINE


COUNTY OF EL DORADO  
DEPARTMENT OF TRANSPORTATION  
(530) 621-5800  
2850 FAIRLANE CT  
PLACERVILLE, CA 95667

ADOPTED AND APPROVED BY: Wendy Thomas, 7/10/23  
WENDY THOMAS, CHAIR, EL DORADO COUNTY BOARD OF SUPERVISORS  
APPROVED BY: Matthew D. Salzman, 7/10/23  
MATTHEW D. SALZMAN, DEPUTY DIRECTOR, ENGINEERING

PW NO. GIP NO. 36109010  
PONY EXPRESS TRAIL BICYCLE,  
PEDESTRIAN AND ADA  
IMPROVEMENTS  
TITLE SHEET  
SHEET 1 OF 87

CONTRACTOR'S LICENSE CLASSIFICATION: Bidders shall be properly licensed to perform the Work pursuant to the State Contractor's License Act (Business and Professions Code section 7000 et seq.) and shall possess a CLASS A LICENSE or equivalent combination of Classes required by the categories and type of Work included in the Contract Documents and Plans. Failure of the successful Bidder to obtain proper and adequate licensing at the time bids are submitted shall constitute a failure to execute the Contract, and forfeiture as provided under that section.

MARK	DATE	BY

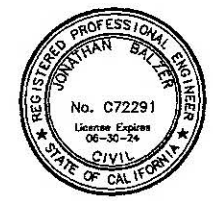

SUBMITTED BY: [Signature]  
CIVIL ENGINEER  
STATE OF CALIFORNIA NO. C72291  
DATE: 06/29/23