

INDEX OF PLANS


SHEET No.	DESCRIPTION
1	TITLE AND LOCATION MAP
2-7	TYPICAL CROSS SECTIONS
8-22	LAYOUTS
23-50	PROFILE AND SUPERELEVATION DIAGRAMS
51-54	CONSTRUCTION DETAILS
55-68	EROSION CONTROL PLANS
69	EROSION CONTROL QUANTITIES
70-107	DRAINAGE PLANS, PROFILES, DETAILS AND QUANTITIES
108-122	UTILITY PLANS
123	CONSTRUCTION AREA SIGNS
124-164	STAGE CONSTRUCTION AND TRAFFIC HANDLING PLANS AND QUANTITIES
165-182	PAVEMENT DELINEATION PLANS AND QUANTITIES
183-200	SIGN DETAILS AND QUANTITIES
201-202	SUMMARY OF QUANTITIES
203-206	LANDSCAPE PLANS
207-218	ELECTRICAL PLANS

DEPARTMENT OF TRANSPORTATION
COUNTY OF EL DORADO, CA

PROJECT PLANS FOR CONSTRUCTION ON
STATE HIGHWAY
IN EL DORADO COUNTY
NEAR EL DORADO HILLS
FROM 0.3 MILE WEST OF
BASS LAKE ROAD UNDERCROSSING TO
0.1 MILE WEST OF CAMERON PARK DRIVE

TO BE SUPPLEMENTED BY STANDARD PLANS DATED MAY, 2006

THE STANDARD PLANS LIST APPLICABLE TO THIS CONTRACT IS INCLUDED IN THE NOTICE TO BIDDERS AND SPECIAL PROVISIONS BOOK.

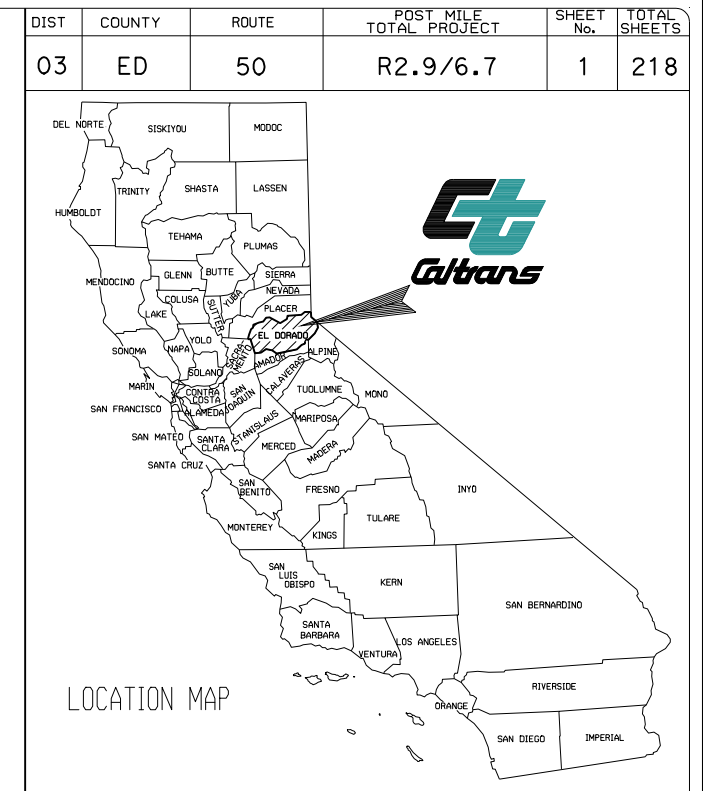


EL DORADO COUNTY
2850 FAIRLANE COURT
PLACERVILLE, CA 95667

The State of California or its officers or agents shall not be responsible for the accuracy or completeness of electronic copies of this plan sheet.

BEGIN CONSTRUCTION
Sta 163+15 PM R2.9

End Work
Sta 411+00

END CONSTRUCTION
Sta 351+00 PM 6.7

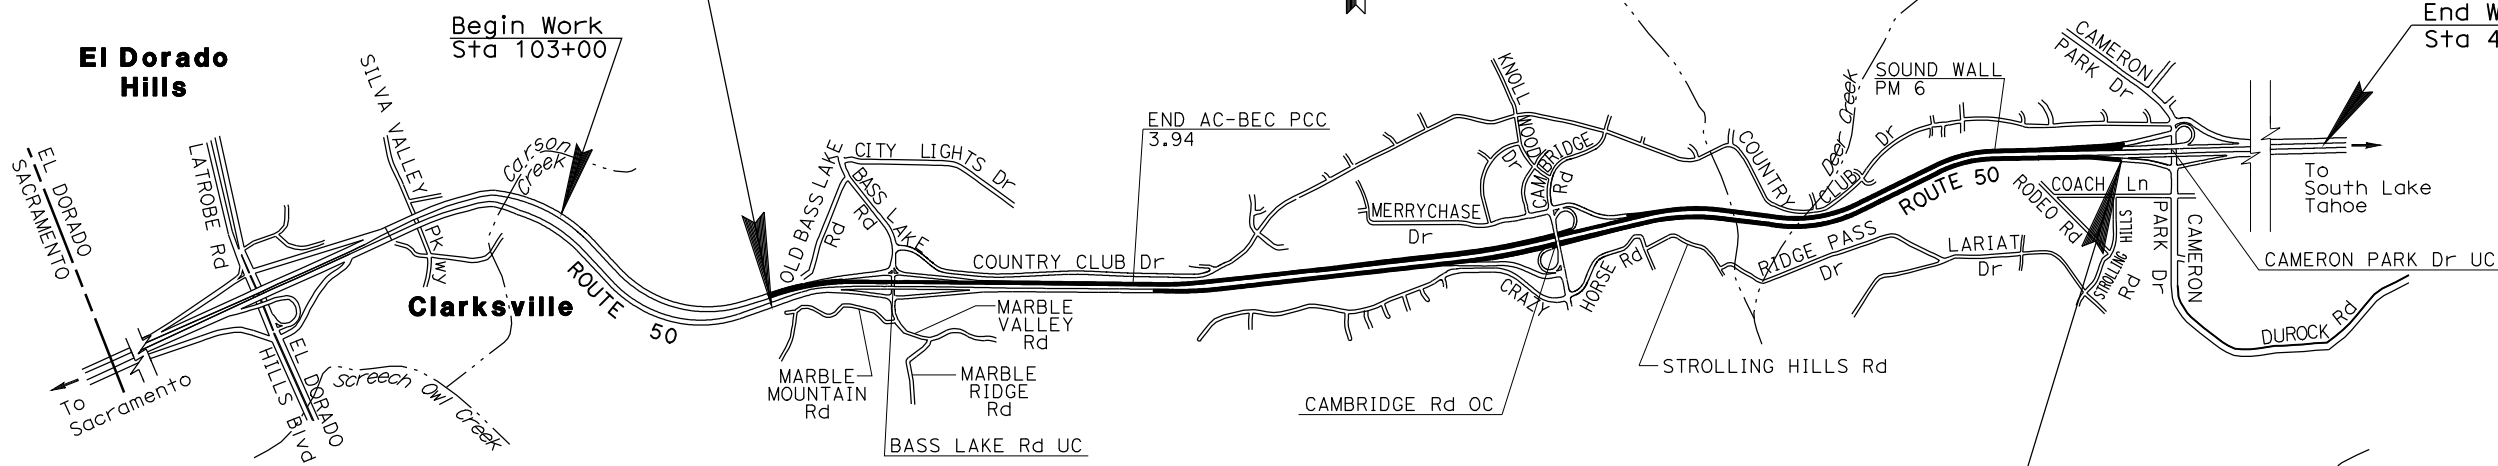

NO SCALE

THE CONTRACTOR SHALL POSSESS THE CLASS (OR CLASSES) OF LICENSE AS SPECIFIED IN THE "NOTICE TO BIDDERS."

APPROVED AND ADOPTED BY:	DATE
JOHN R. KNIGHT CHAIRMAN, EL DORADO COUNTY BOARD OF SUPERVISORS	
APPROVED BY:	DATE
JAMES W. WARE, P.E. NO. C61036 DIRECTOR, EL DORADO COUNTY DEPARTMENT OF TRANSPORTATION	
MATTHEW D. SMELTZER, P.E. NO. C56832 DEPUTY DIRECTOR ENGINEERING DIVISION, EL DORADO COUNTY DEPARTMENT OF TRANSPORTATION	

**COUNTY OF EL DORADO
DEPARTMENT OF TRANSPORTATION**

2850 FAIRLANE COURT
PLACERVILLE, CA 95667
(530) 621-5900



REVISIONS		
MARK	DATE	BY

BOARD OF SUPERVISORS

JOHN KNIGHT	I
RAYMOND J. NUTTING	II
JAMES SWEENEY	III
RON V. BRIGGS	IV
NORMA SANTIAGO	V

CU 03221
EA 3A7121
COUNTY CONTRACT NO. 53113
PW No. 09-30408
CONTRACT NO. 03-3A712

PROJECT ENGINEER DATE 11-4-11
REGISTERED CIVIL ENGINEER

November 8, 2011
PLANS APPROVAL DATE

FEDERAL AID No. CML 5925(102)

REGISTRATION NO. 57530
DESIGN OVERSIGHT APPROVAL
PRINTED NAME
PROJECT ENGINEER
SCOTT MANN