


COUNTY OF EL DORADO, CA
DEPARTMENT OF TRANSPORTATION

PROJECT PLANS FOR THE CONSTRUCTION OF
PONDEROSA ROAD CLASS II
BIKE PATH AND SIDEWALK


IN THE COUNTY OF EL DORADO, DISTRICT 4
IN THE TOWN OF SHINGLE SPRINGS, ON PONDEROSA ROAD,
BETWEEN FOXWOOD LANE AND MINESHAFT LANE

To be supplemented with Standard Plans and Specifications dated 2024, including
the amendments to the 2024 Revised Standard Specifications, of the California
Department of Transportation, unless otherwise noted.

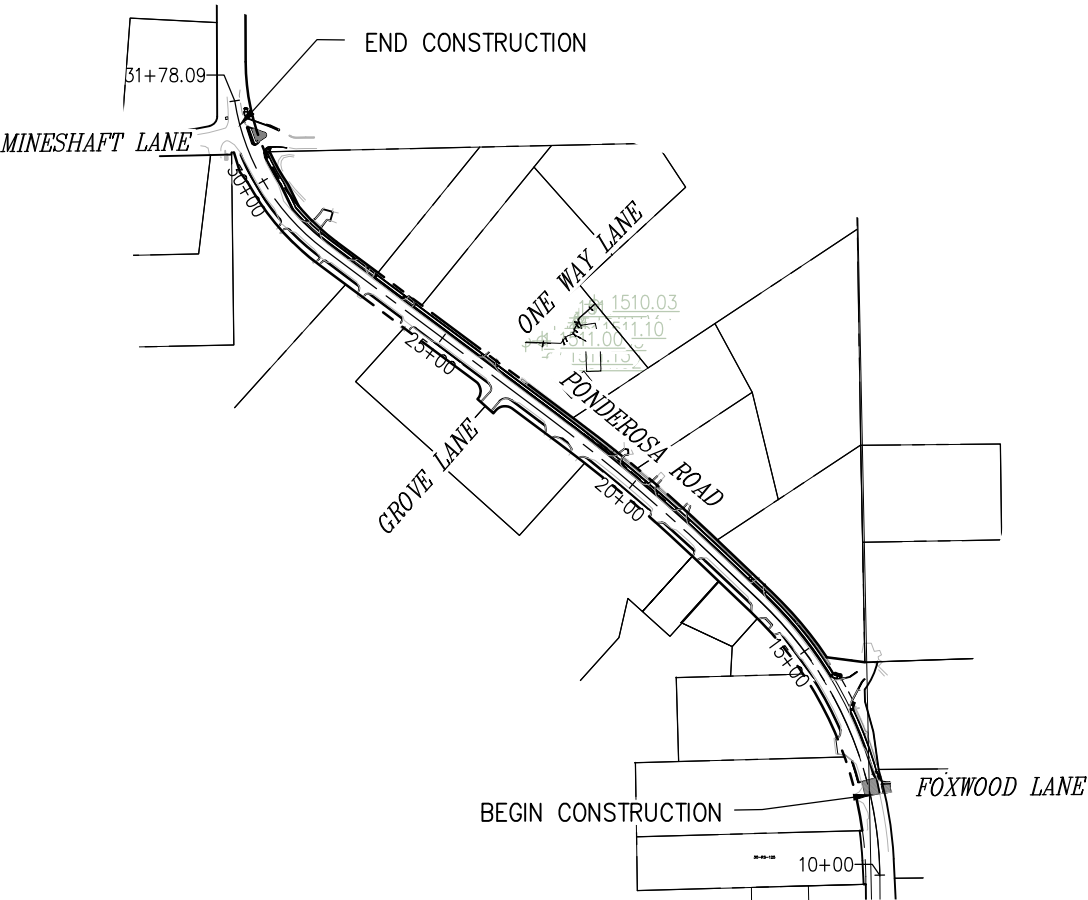


SITE PLAN

SCALE: 1"=200'

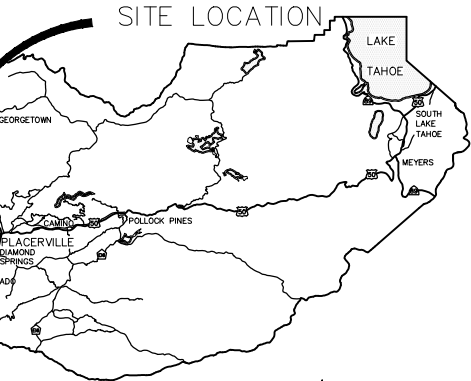

VICINITY MAP
COUNTY OF EL DORADO

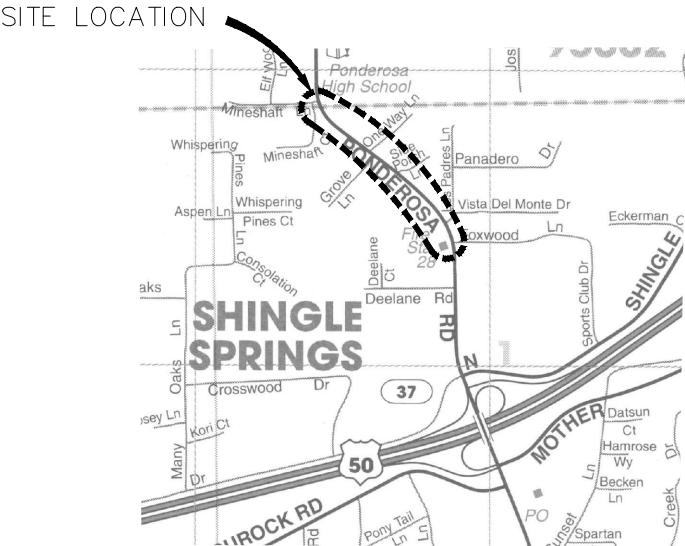

LOCATION MAP
NOT TO SCALE

FUNDING AGENCY

FEDERAL AID NUMBER IS CML 5925 (175)


[Signature]

SUBMITTED BY: JON BALZER P.E. 2/19/25
CIVIL ENGINEER
STATE OF CALIFORNIA NO. C72291

INDEX OF SHEETS		
SHEET	PLAN SHEET	TITLE
1		TITLE SHEET
2	CD-1	SURVEY CONTROL DIAGRAM
3	X-1	TYPICAL SECTIONS
4 - 7	L-1 TO L-4	TYPICAL SECTIONS
8	P-1	PROFILE - MINESHAFT
9 - 27	C-1 TO C-19	CONSTRUCTION DETAILS
28 - 36	D-1 TO D-9	DRAINAGE PLANS
37 - 38	R-1 & R-2	RETAINING WALL PLANS
39 - 42	SPD-1 TO SPD-4	SIGNING AND PAVEMENT DELINEATION
43 - 45	SC-1 TO SC-3	STAGE CONSTRUCTION AND SIGNING
46	TR-1	TREE REMOVAL PLAN

CONTRACTOR'S LICENSE CLASSIFICATION: Bidders shall be properly licensed to perform the Work pursuant to the State Contractor's License Act (Business and Professions Code section 7000 et seq.) and shall possess a CLASS A LICENSE or equivalent combination of Classes required by the categories and type of Work included in the Contract Documents and Plans. Failure of the successful Bidder to obtain proper and adequate licensing at the time bids are submitted shall constitute a failure to execute the Contract, and forfeiture as provided under that section.

REVISIONS		
MARK	DATE	BY

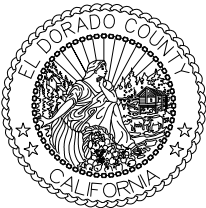

BOARD OF SUPERVISORS	
I	GREG FERRO
II	GEORGE TURNBOO
III	BRIAN VEERKAMP
IV	LORI PARLIN
V	BROOKE LAINE



COUNTY OF EL DORADO DEPARTMENT OF TRANSPORTATION	
(530) 621-5900 2850 FAIRLANE CT PLACERVILLE, CA 95667	

ADOPTED AND APPROVED BY:	
DATE	
CHAIR, EL DORADO COUNTY BOARD OF SUPERVISORS	
APPROVED BY:	
DATE	
RAFAEL MARTINEZ, DIRECTOR DEPARTMENT OF TRANSPORTATION	
DATE	
MATTHEW D. SMELTZER P.E. NO. C56832 DEPUTY DIRECTOR, ENGINEERING	

CONTRACT NO. 9275	CIP NO. 36109009
PONDEROSA ROAD CLASS II BIKE PATH AND SIDEWALK	
TITLE SHEET	
SHEET 1	OF 46

ORIGINAL SCALE IS IN INCHES
Drawing name: Z:\Civil 3D Projects\97018 Ponderosa Class II Sidewalk\CADD Files\Sheets\CD-1.dwg Layout Tab: CD-1 Feb 20,2025 11:04am dmorkowski

 FOR REDUCED PLANS

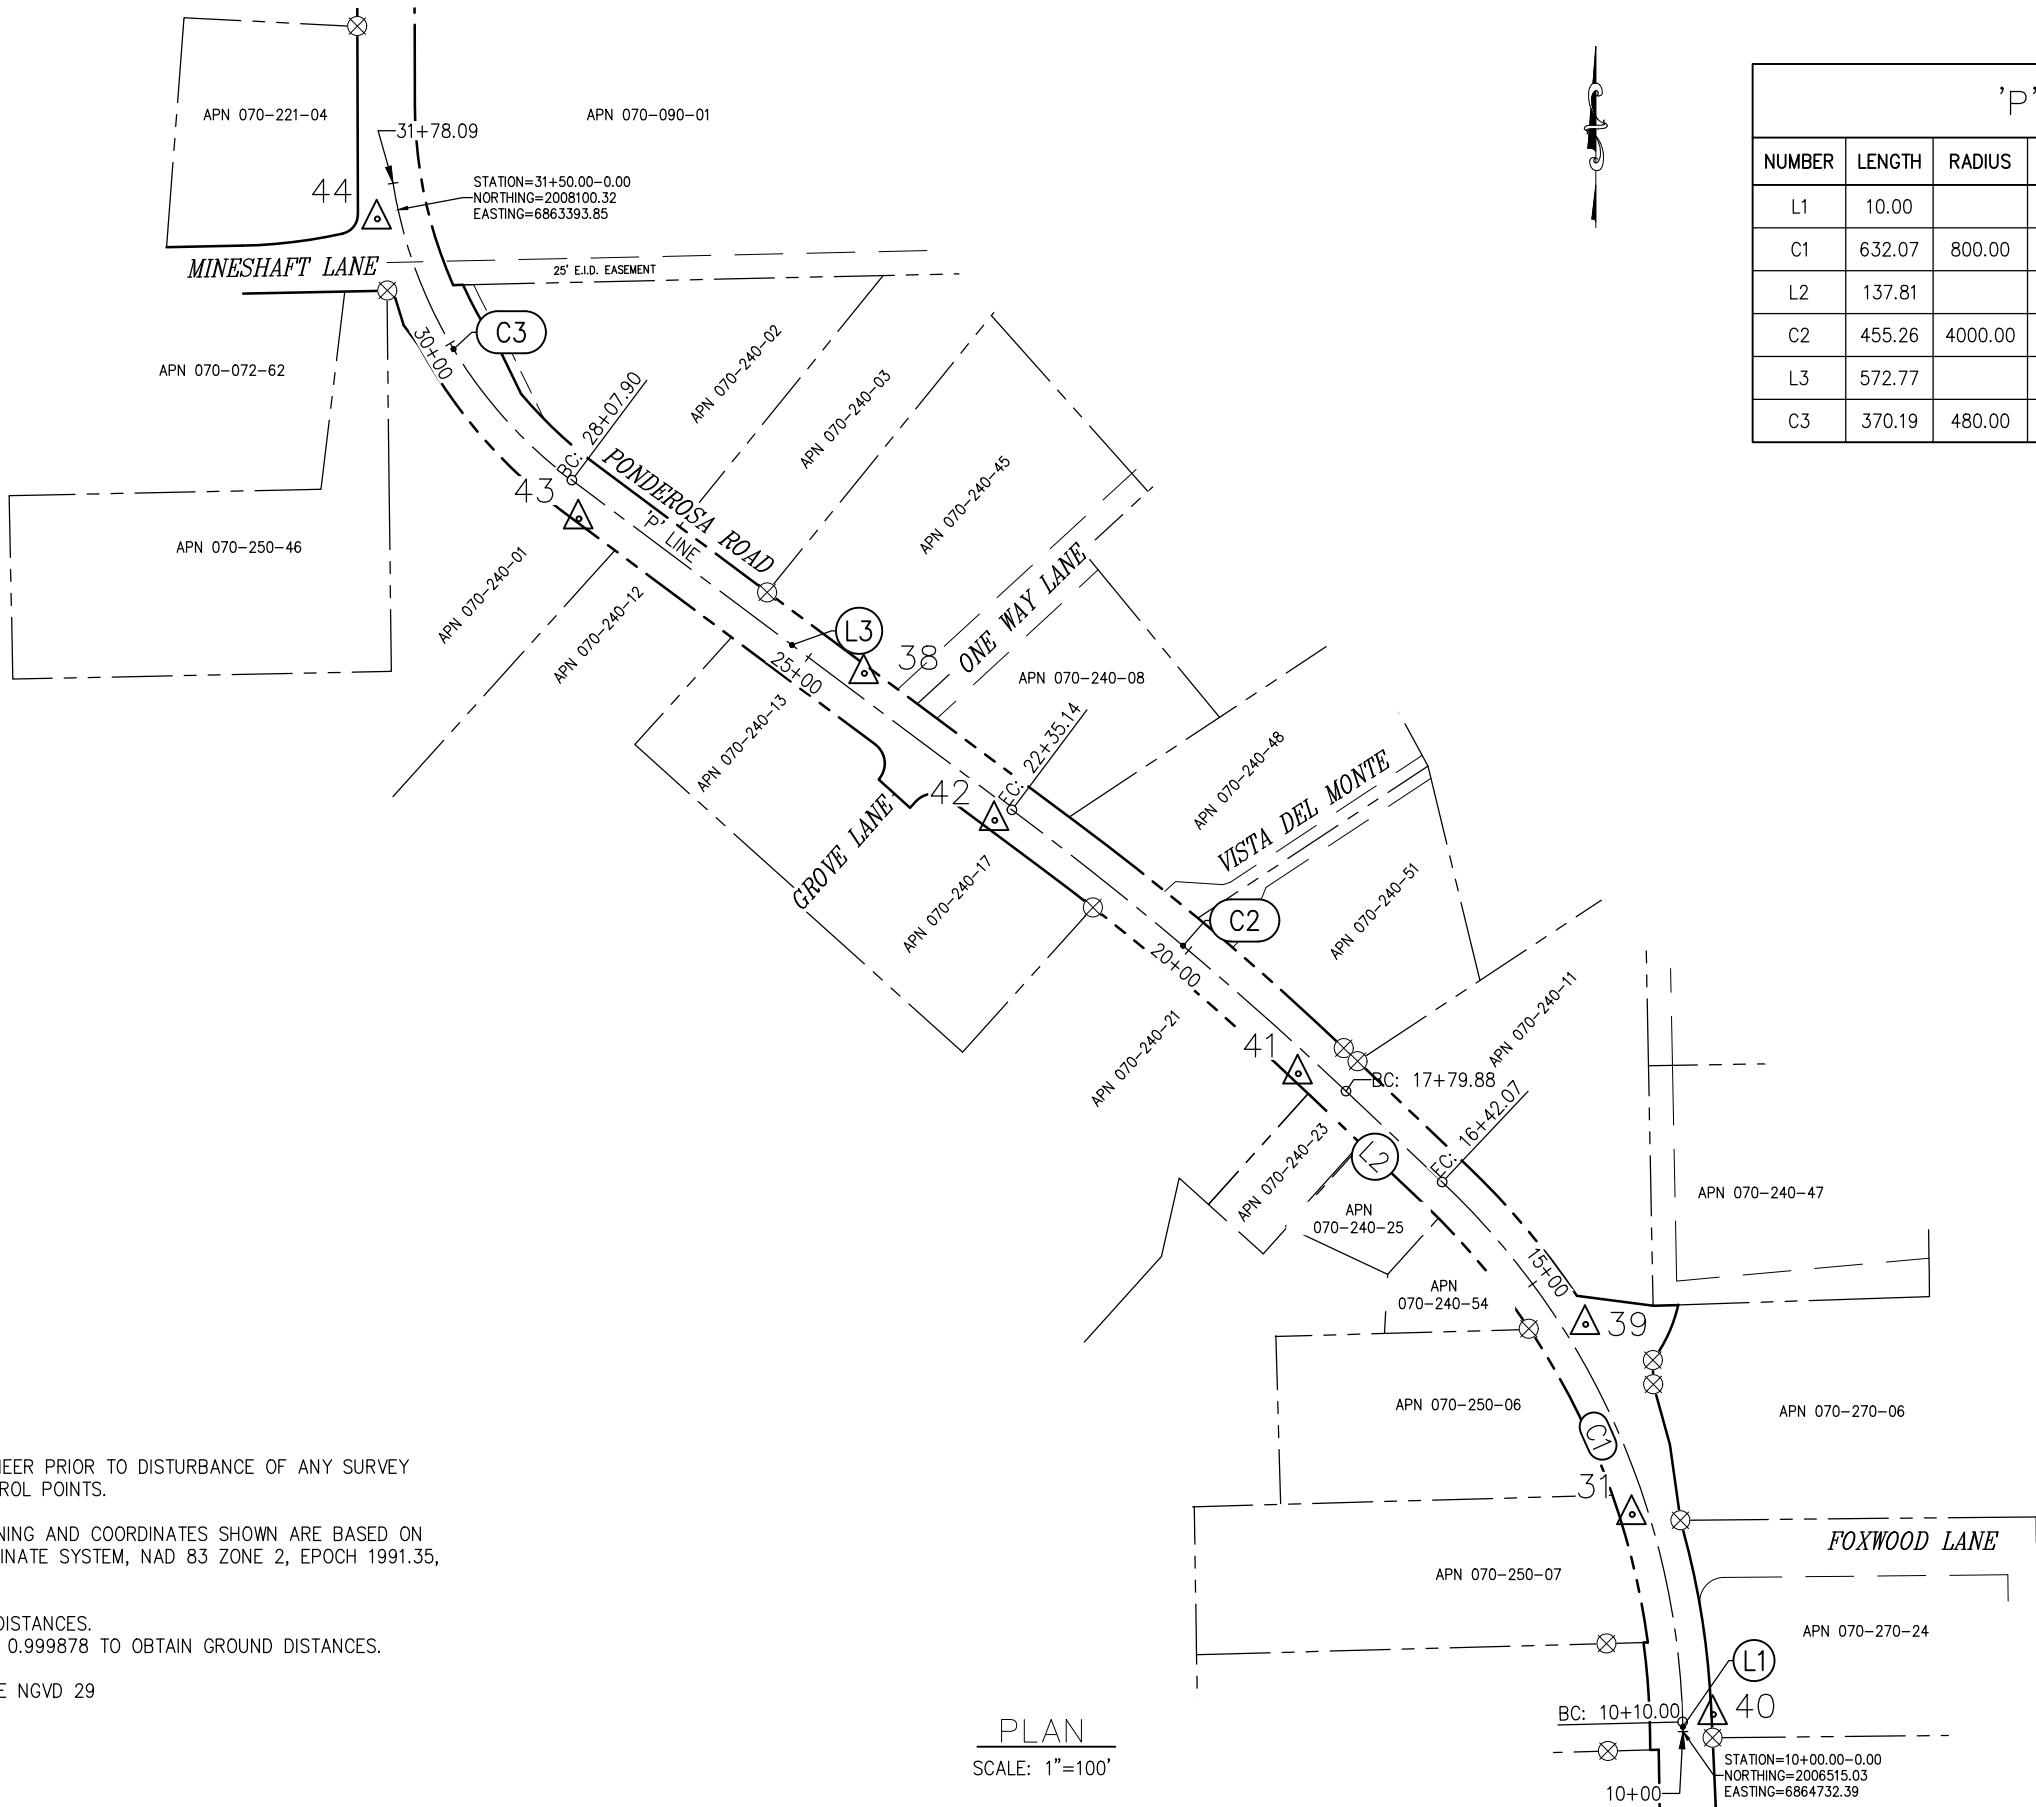

'P' ALIGNMENT				
NUMBER	LENGTH	RADIUS	LINE / CHORD DIRECTION & LENGTH	DELTA
L1	10.00		N 1° 22' 17" W	
C1	632.07	800.00	N 24° 00' 21" W - 615.76	45° 16' 08"
L2	137.81		N 46° 38' 25" W	
C2	455.26	4000.00	N 49° 54' 03" W - 455.01	6° 31' 16"
L3	572.77		N 53° 09' 41" W	
C3	370.19	480.00	N 31° 04' 03" W - 361.08	44° 11' 17"

CONTROL TABLE		
CONTROL NUMBER	ELEVATION	DESCRIPTION
31	1544.96	CP SPIKE
38	1515.98	CP SPIKE
39	1541.52	CP SPIKE
40	1548.86	CP SPIKE
41	1526.91	CP SPIKE
42	1516.47	CP SPIKE
43	1521.23	CP SPIKE
44	1521.30	CP SPIKE

LEGEND

- (E) SURVEY CONTROL
- (E) SURVEY MONUMENT

NOTES:

CONTRACTOR TO NOTIFY ENGINEER PRIOR TO DISTURBANCE OF ANY SURVEY MONUMENTS OR SURVEY CONTROL POINTS.

BEARINGS, DISTANCES, STATIONING AND COORDINATES SHOWN ARE BASED ON THE CALIFORNIA STATE COORDINATE SYSTEM, NAD 83 ZONE 2, EPOCH 1991.35, U.S. SURVEY FEET.

DISTANCES SHOWN ARE GRID DISTANCES.
DIVIDE DISTANCES SHOWN BY 0.999878 TO OBTAIN GROUND DISTANCES.

ELEVATIONS SHOWN REFERENCE NGVD 29

PLAN
SCALE: 1"=100'

SURVEY CONTROL DIAGRAM
SCALE : AS NOTED

REVISION	NUMBER	DATE	DESCRIPTION	BY



PREPARED UNDER THE SUPERVISION OF :
Joseph C. Neely
LICENSED LAND SURVEYOR
02/19/25
DATE:

DESIGNED: JB
DRAWN: CAD
CHECKED: JB
DATE: 2/12/25
ROAD NUMBER: 005




COUNTY OF EL DORADO
DEPARTMENT OF TRANSPORTATION

PONDEROSA ROAD CLASS II
BIKE PATH AND SIDEWALK


25-0282 Revised C 2 of 15

SHEET
CD-1
02 OF 46
W.O. No. 36109009


ORIGINAL SCALE: 1" = 10' INCHES
Drawing name: Z:\Civil 3D Projects\97018 Ponderosa Class II Sidewalk\CADD Files\Sheets\X-Sheets.dwg Layout Tab: X-1 Feb 20, 2025 11:20am dmankowski

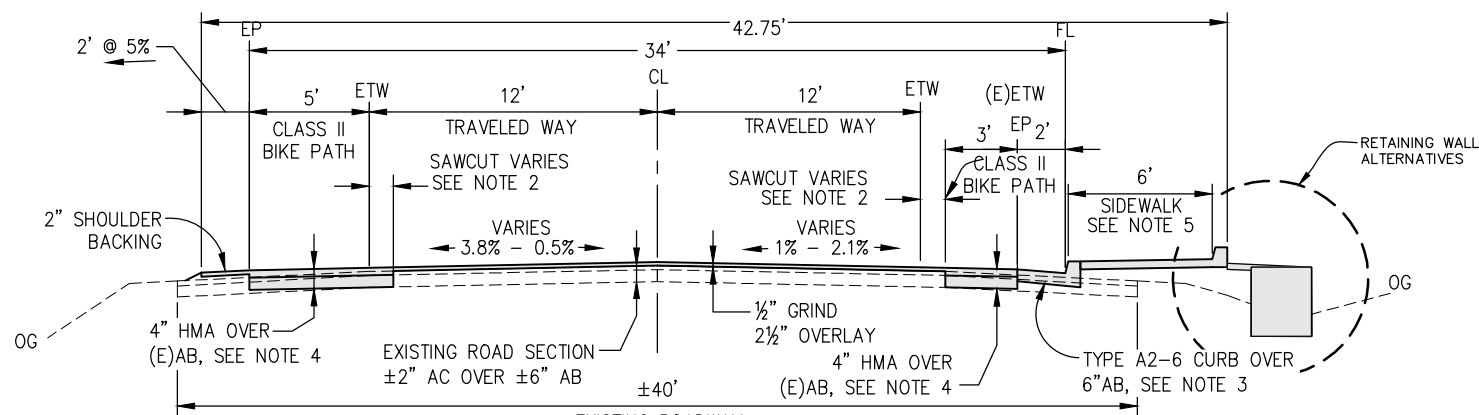

'P' 15+65.00 TO 'P' 16+47.00 (U-1 WALL LINE, SHT. R-1)
'P' 20+75.15 TO 'P' 23+39.18 (U-2 WALL LINE SHT. R-2)

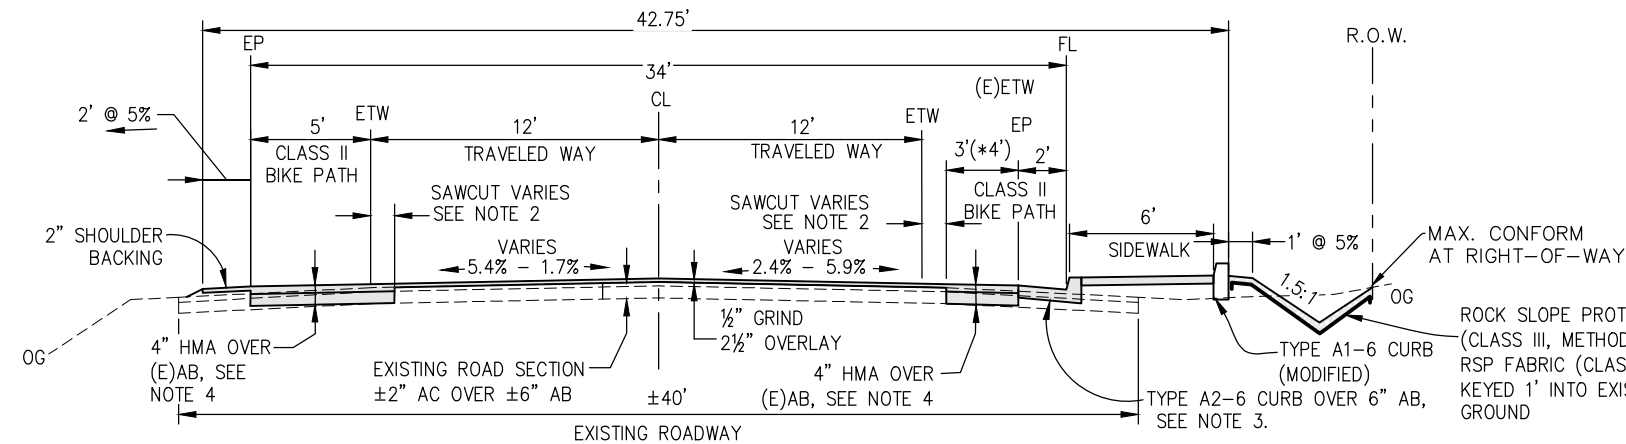

'P' 12+00.00 TO 'P' 15+65.00 * (4' WIDE FULL PAVEMENT SHOULDER SECTION THROUGH STATIONING)
'P' 16+92.00 TO 'P' 18+71.82
'P' 18+94.70 TO 'P' 19+57.91

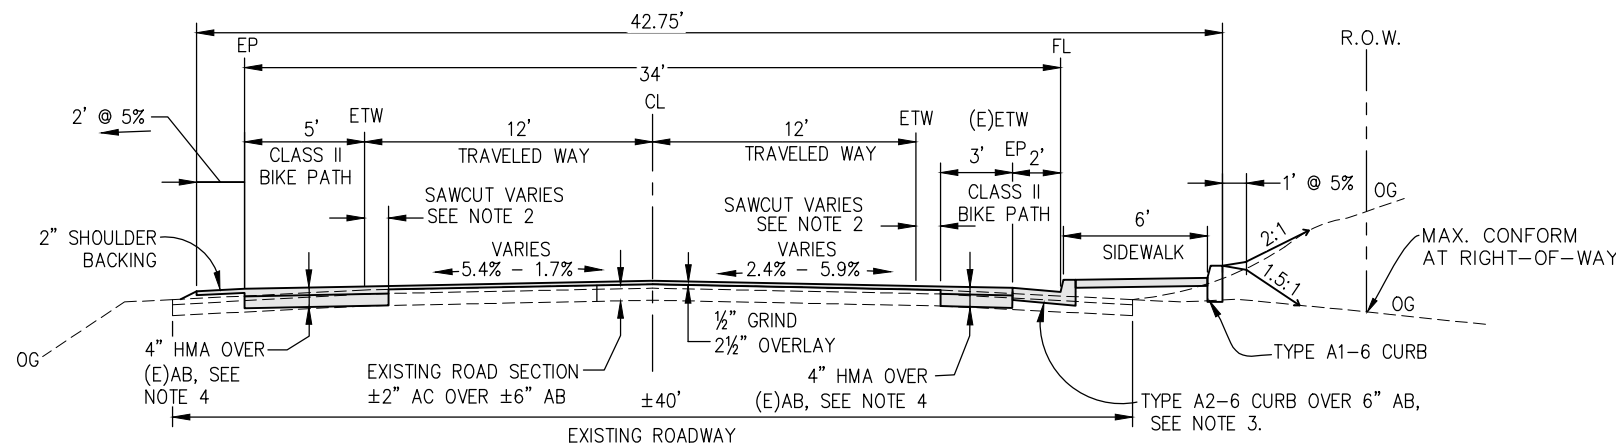


NOTES:

- SEE SHEET C-17 FOR TYPICAL SECTIONS AT RIGHT TURN LANE AT MINESHAFT DRIVE.
- SEE TYPICAL SECTIONS DETAILS FOR RESPECTIVE DRIVEWAYS ON C-SHEETS

'P' 18+71.91 TO 'P' 20+75.16
'P' 19+57.91 TO 'P' 20+75.16
'P' 23.39.19 TO 'P' 23.73.00
'P' 24.14.95 TO 'P' 28.74.92

CONSTRUCTION NOTES:


- RETAINING WALL, (2 LOCATIONS) FROM STA 15+65 TO 16+47, STA 20+75.15± TO 23+39.18± SEE R-SHEETS FOR WALL LAYOUTS.
- RT SIDE SAWCUT TO FOLLOW EXISTING ETW
LT SIDE SAWCUT VARIES 0'-2' FROM EXISTING ETW
- TYPE E CURB (MOD) AT VARIOUS DRIVEWAYS, SEE C-SHEETS.
- SCARIFY, RE-COMPACT, AND PLACE ADDITIONAL AB AS NEEDED TO MAKE GRADE
- 4" PCC OVER 4" AB

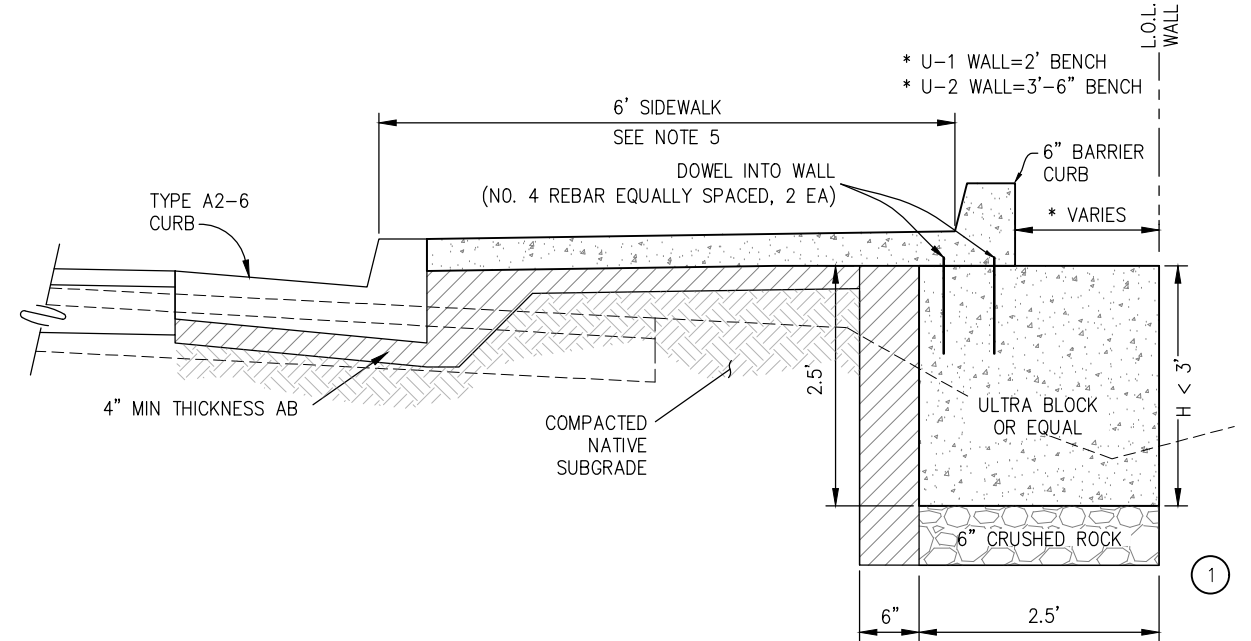


RETAINING WALL
BLOCK WALL ALTERNATIVE
NTS

NOTE: FULL FLAT UNIT SHOWN, ADDITIONAL FLAT CAP UNITS USED AS NECESSARY.


- * U-1 WALL=2' BENCH AT 5.0%
- * U-2 WALL=3'-6" BENCH AT 5.0%

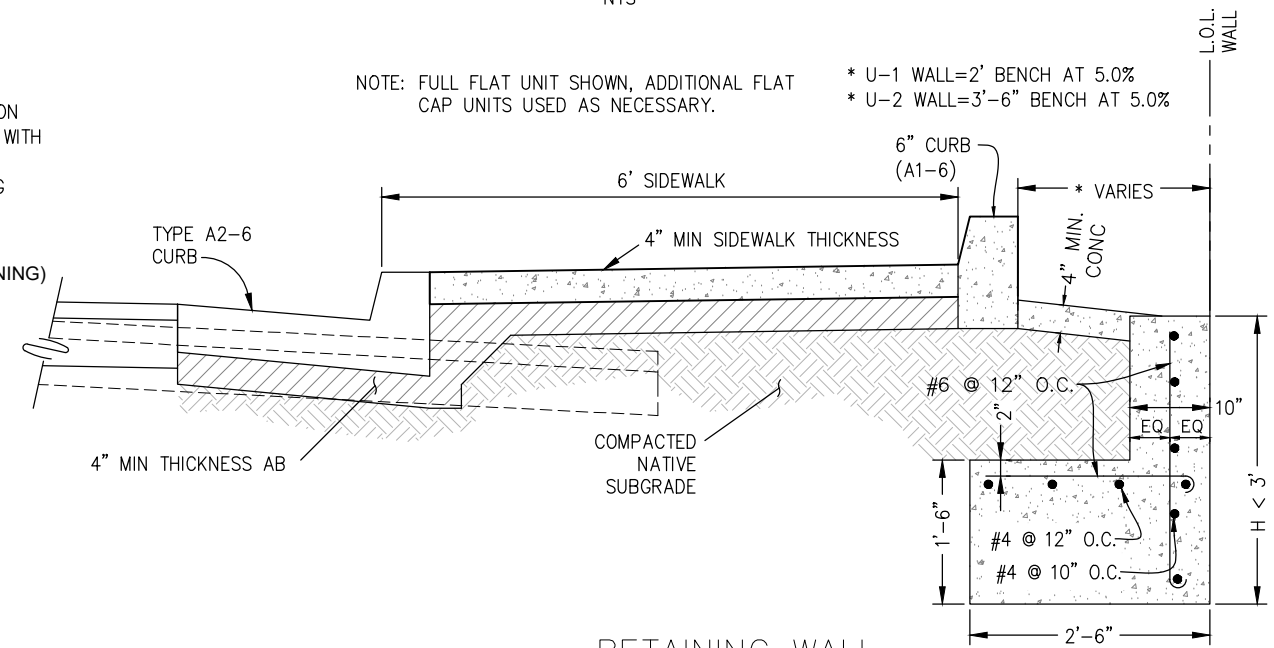

RETAINING WALL
MODIFIED TYPE 5 WALL ALTERNATIVE
NTS

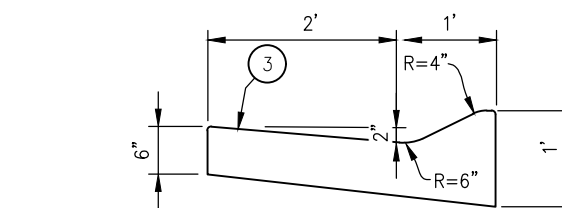


TYPE E CURB
NTS
NOTE: VARIOUS DRIVEWAYS ON RIGHT SIDE

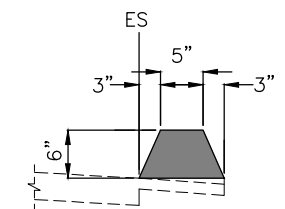

TYPE A ASPHALT DIKE
NTS
NOTE: VARIOUS DRIVEWAYS ON RIGHT SIDE

TYPICAL SECTIONS
SCALE : NONE

REVISION	NUMBER	DATE	DESCRIPTION	BY
1				
2				
3				
4				
5				

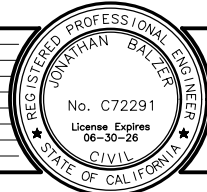

PREPARED UNDER THE SUPERVISION OF:
REGISTERED CIVIL ENGINEER
02/19/25

DESIGNED: JB
DRAWN: DJ
CHECKED: JB
DATE: 2/14/25
ROAD NUMBER: 005





COUNTY OF EL DORADO
DEPARTMENT OF TRANSPORTATION

PONDEROSA ROAD CLASS II
BIKE PATH AND SIDEWALK

25-0282 Revised C 3 of 15



SHEET
X-1
03 OF 46
W.O. No. 36109009

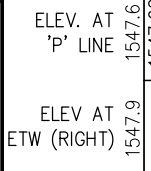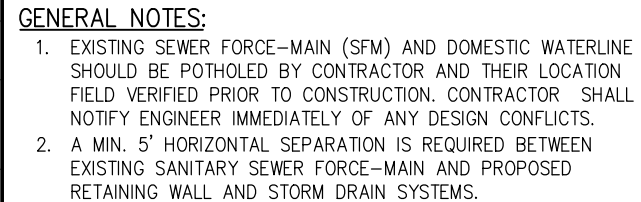

SCALE: 1"=20' H,V

LAYOUT
S SHOWN

 SHEET
L-1
04 OF 46
O. No.
36109009

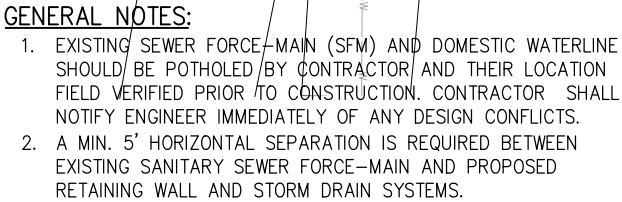

FOR REDUCED PLANS
ORIGINAL SCALE IS IN INCHES
Drawing name: Z:\Civil_3D Projects\97018 Ponderosa Class II Sidewalk\CADD Files\Sheets\L-Sheets2.DWG Layout Tab: L-3 Feb 20,2025 -- 11:05am dmankowski

GENERAL NOTES:

1. EXISTING SEWER FORCE-MAIN (SFM) AND DOMESTIC WATERLINE SHOULD BE POTHOLED BY CONTRACTOR AND THEIR LOCATION FIELD VERIFIED PRIOR TO CONSTRUCTION. CONTRACTOR SHALL NOTIFY ENGINEER IMMEDIATELY OF ANY DESIGN CONFLICTS.
2. A MIN. 5' HORIZONTAL SEPARATION IS REQUIRED BETWEEN EXISTING SANITARY SEWER FORCE-MAIN AND PROPOSED RETAINING WALL AND STORM DRAIN SYSTEMS.

CARLTON
APN 070-240-012


BOYER
APN 070-240-001

WARNER
APN 070-240-013

BANNER
APN 070-240-045


JARRETT
APN 070-240-003

BUCKOVECZ
APN 070-240-002

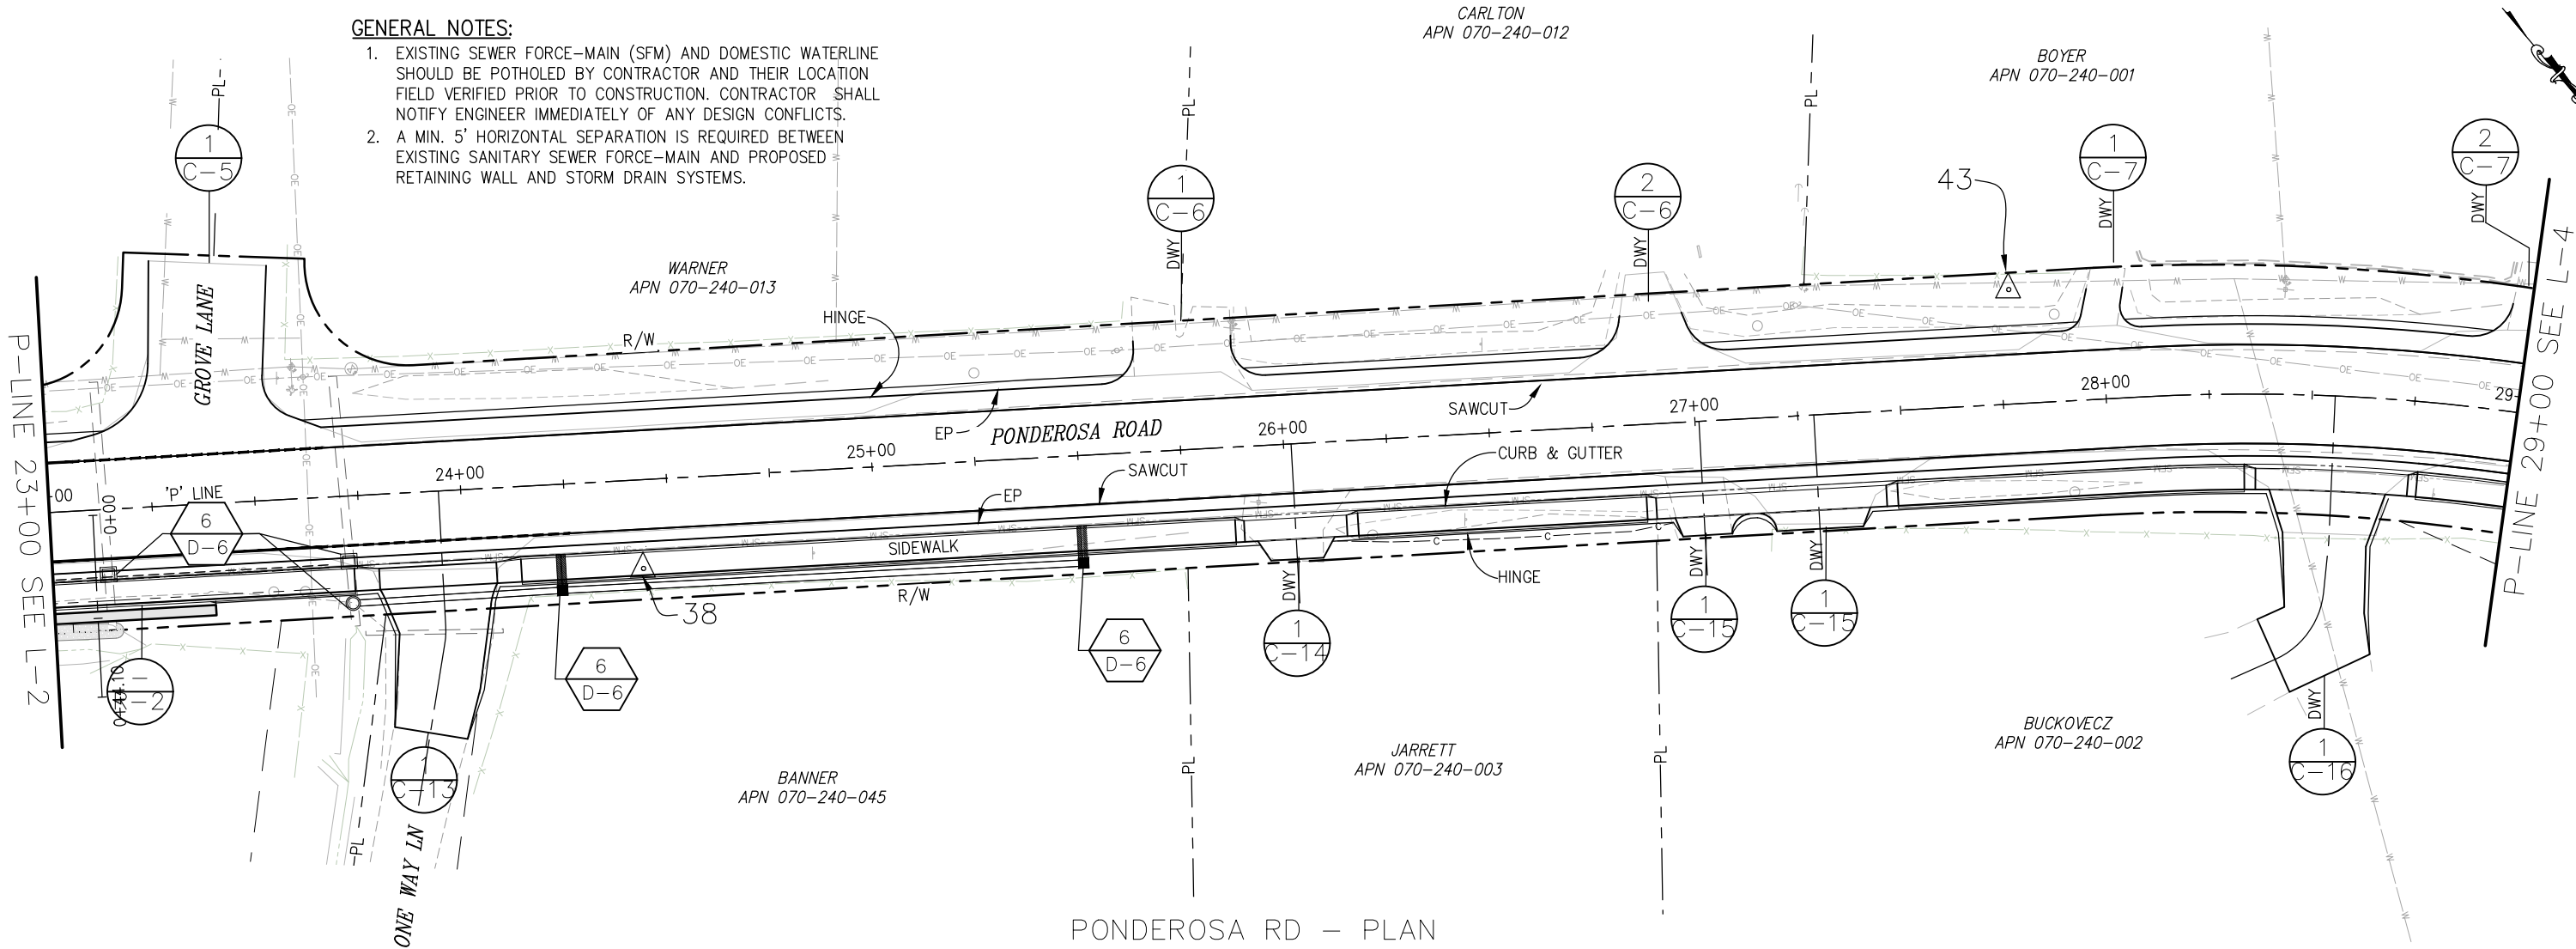

PONDEROSA RD - PLAN


SCALE: 1"=20'

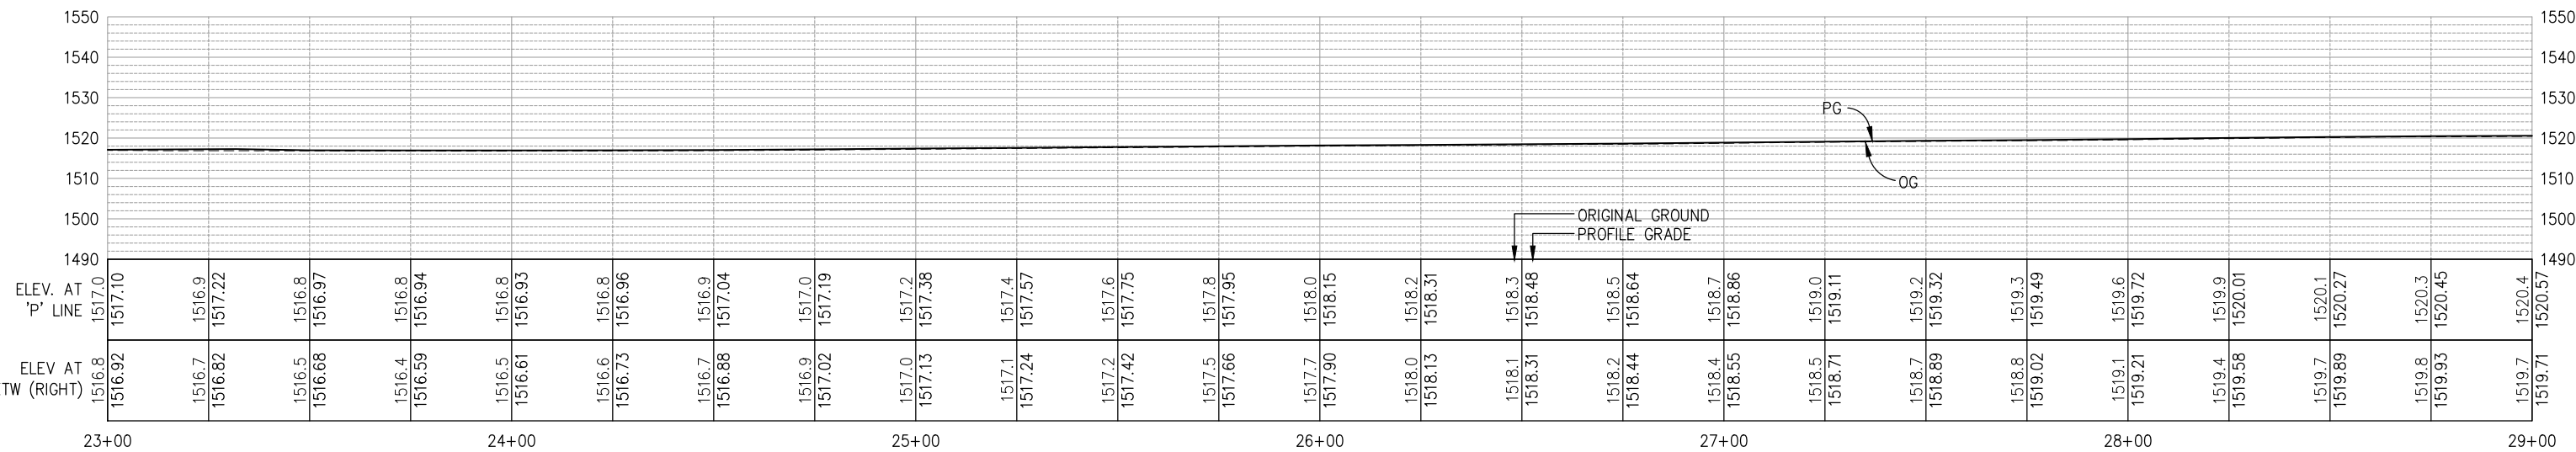

PONDEROSA RD - PROFILE

SCALE: 1"=20' H,V

LAYOUT
SCALE : AS SHOWN

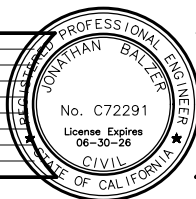

PREPARED UNDER THE SUPERVISION OF :

REGISTERED CIVIL ENGINEER
DATE: 02/19/25

DESIGNED: JB
CHECKED: JB
ROAD NUMBER: 005
DRAWN: DJ
DATE: 2/12/25




COUNTY OF EL DORADO
DEPARTMENT OF TRANSPORTATION


PONDEROSA ROAD BICYCLE AND
PEDESTRIAN IMPROVEMENTS

25-0282 Revised C 6 of 15

SHEET
L-3
06 OF 46
W.D. No. 36109009

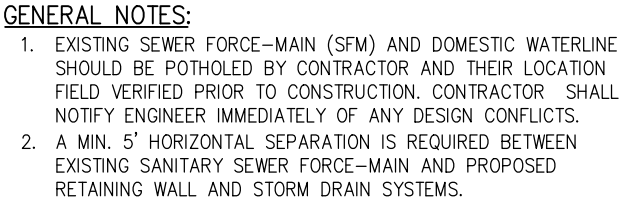

SCALE: 1"=20'

 

DESIGNED: JB	DRAWN: DJ
CHECKED: JB	DATE: 2/12/25
ROAD NUMBER: 005	




PONDEROSA ROAD BICYCLE AND PEDESTRIAN IMPROVEMENTS

25-0282 Revised C 7 of 15


SHEET
L-4
07 OF 46
W.O. No.
36109009

ORIGINAL SCALE: 1"=5' H, V
Drawing name: Z:\Civil 3D Projects\97018 Ponderosa Class II Sidewalk\CADD Files\Sheets\P-SHEET.dwg
Layout Tab: MS-1 & MS-2
Feb 20, 2025 — 11:05am dmankowski

FOR REDUCED PLANS
0 1 2

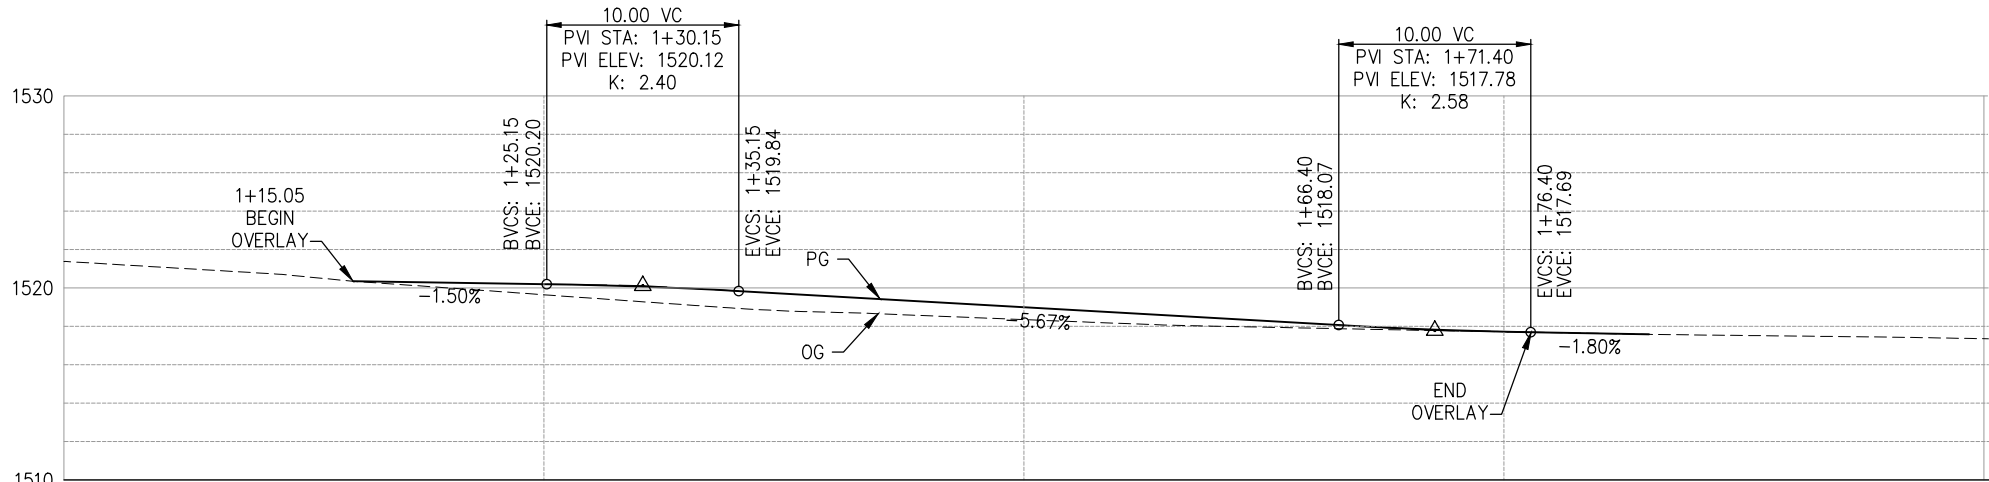

PROFILE — 'MS-1'
SCALE: 1"=5' H,V

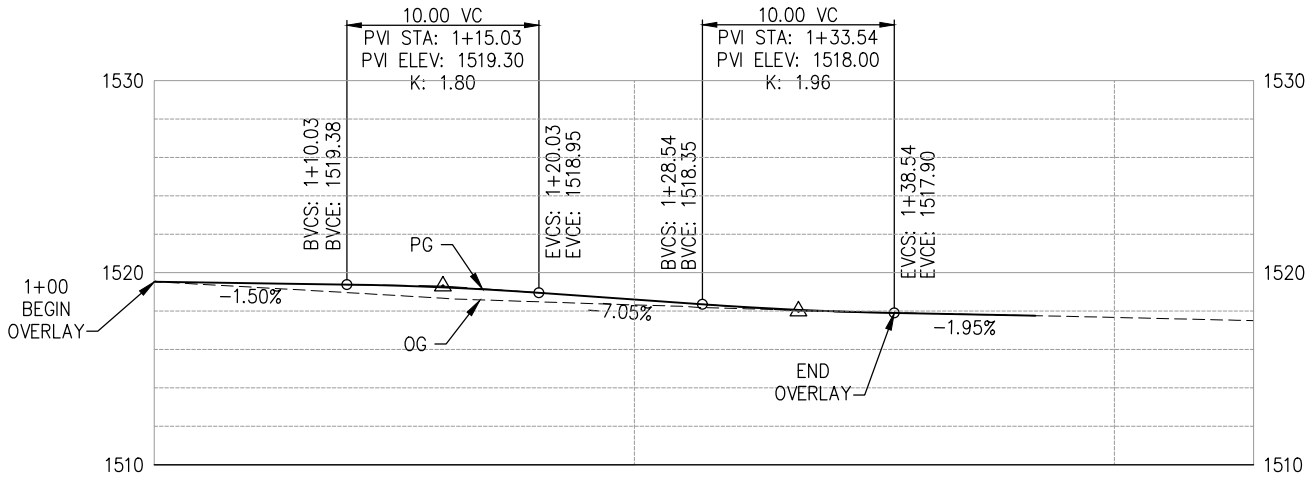

PROFILE — 'MS-2'
SCALE: 1"=5' H,V

MS-1 & MS-2 PROFILE
PONDEROSA ROAD / MINESHFT LANE
SCALE : AS NOTED



PREPARED UNDER THE SUPERVISION OF :
REGISTERED CIVIL ENGINEER
02/19/25
DATE:

DESIGNED: JB
DRAWN: DJ
CHECKED: JB
DATE: 2/6/25
ROAD NUMBER: 005



COUNTY OF EL DORADO
DEPARTMENT OF TRANSPORTATION


PONDEROSA RD CLASS II
BIKE PATH AND SIDEWALK

25-0282 Revised C 8 of 15


SHEET
P-1
08 OF 46
W.O. No. 97018

ORIGINAL SCALE IS IN INCHES
Drawing name: Z:\Civil 3D Projects\97018 Ponderosa Class II Sidewalk\CADD Files\Sheets\C-SHEETS.dwg Layout Tab: C-1 Feb 20,2025 -- 11:06am dmarkowski

FOR REDUCED PLANS

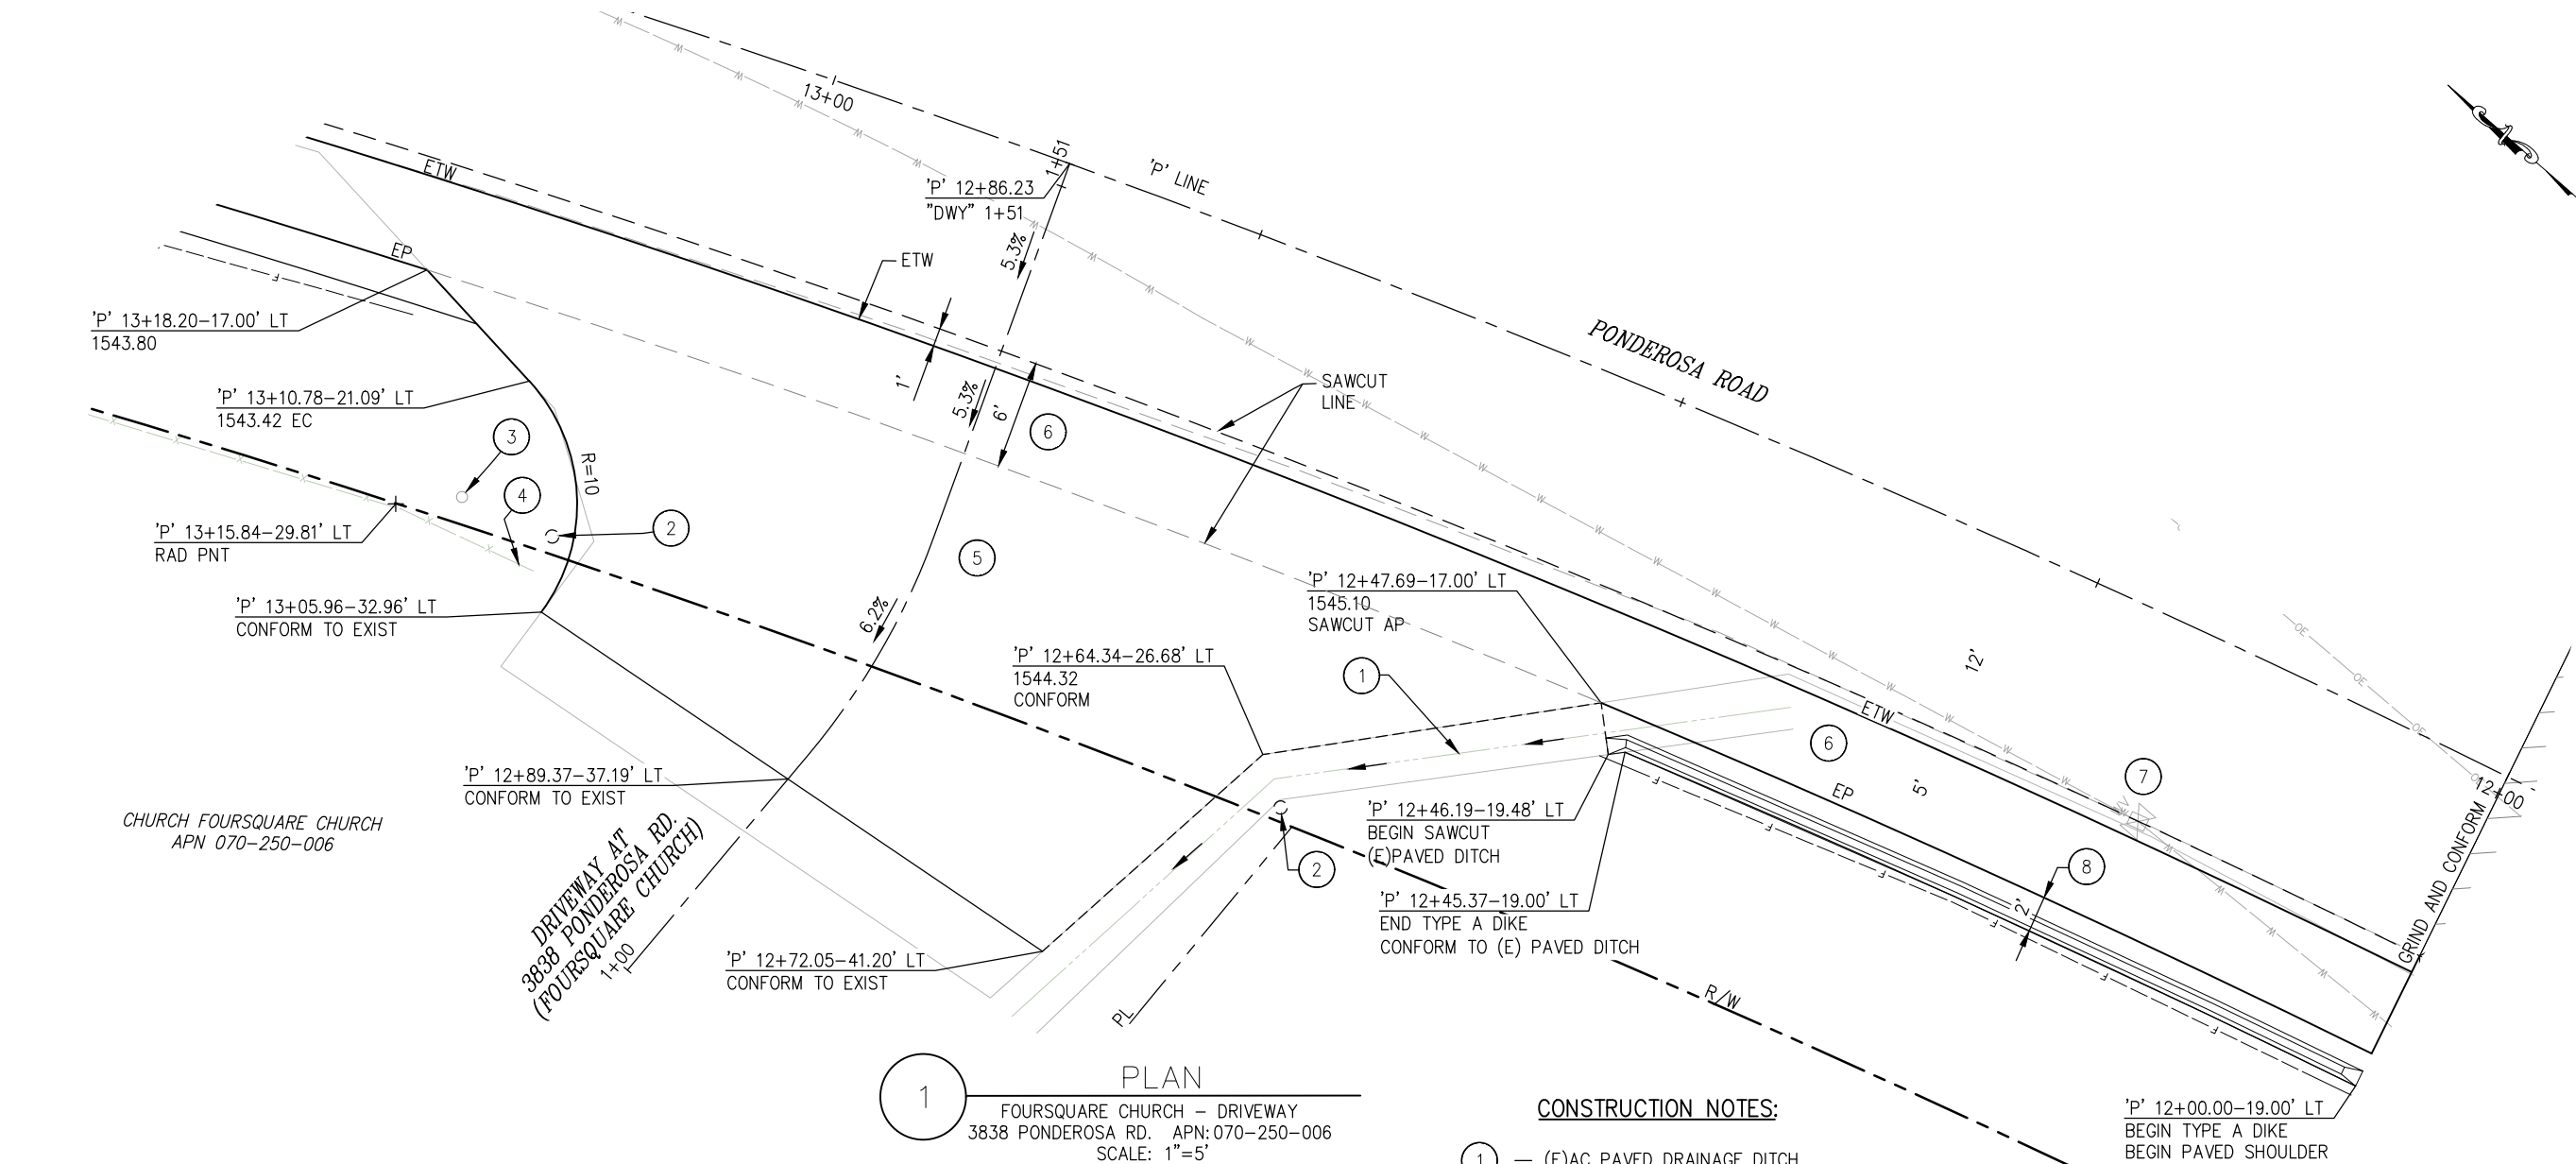

1 PLAN
FOURSQUARE CHURCH - DRIVEWAY
3838 PONDEROSA RD. APN:070-250-006
SCALE: 1"=5'

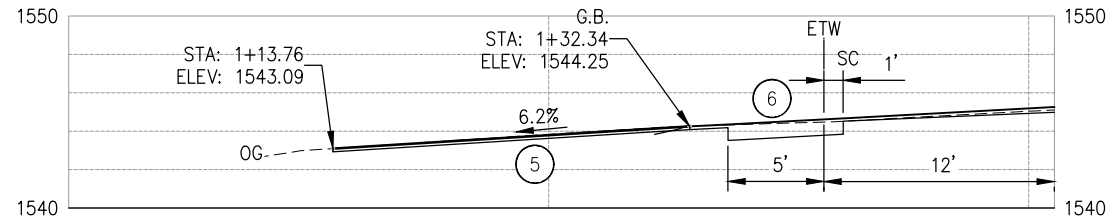

PROFILE
FOURSQUARE CHURCH - DRIVEWAY
3838 PONDEROSA RD. APN:070-250-006
NTS

- CONSTRUCTION NOTES:**
- 1 - (E)AC PAVED DRAINAGE DITCH, MAINTAIN EXISTING FLOWLINE
 - 2 - (E)ELECTRIC LIGHT, PROTECT IN PLACE (EACH SIDE OF DWY)
 - 3 - (E)MAILBOX, PROTECT IN PLACE
 - 4 - (E)WOOD SPLITRAIL FENCE, PROTECT IN PLACE
 - 5 - 2" HMA, GRIND AND OVERLAY
 - 6 - 4" HMA, OVER (E) AB
 - 7 - (E)WATER VALVE, PROTECT IN PLACE AND ADJUST TO GRADE
 - 8 - 2' WIDE PAVED SHOULDER w/ TYPE A DIKE, 2" HMA OVER COMPACTED NATIVE

- NOTES:**
- 1. STATION OFFSET CALLOUTS PER 'P' ALIGNMENT.
 - 2. UNLESS NOTED, CUT/FILL SLOPES TO BE 2:1.

DRIVEWAY
CONSTRUCTION DETAILS
SCALE : AS NOTED



PREPARED UNDER THE SUPERVISION OF :
REGISTERED CIVIL ENGINEER
02/19/25
DATE:

DESIGNED: JB
DRAWN: DJ
CHECKED: JB
DATE: 2/12/25
ROAD NUMBER: 005



COUNTY OF EL DORADO
DEPARTMENT OF TRANSPORTATION

PONDEROSA ROAD BICYCLE AND
PEDESTRIAN IMPROVEMENTS

25-0282 Revised C 9 of 15


SHEET
C-1
09 OF 46
W.O. No. 36109009

ORIGINAL SCALE IS IN INCHES
Drawing name: Z:\Civil 3D Projects\97018 Ponderosa Class II Sidewalk\CADD Files\Sheets\C-SHEETS.dwg Layout Tab: C-2 Feb 20,2025 -- 11:06am dmarkowski

FOR REDUCED PLANS

2
1
0

- CONSTRUCTION NOTES:**
- ① — (E)MAILBOX, PROTECT IN PLACE
 - ② — 2" HMA, GRIND AND OVERLAY
 - ③ — 4" HMA, OVER EXISTING AB

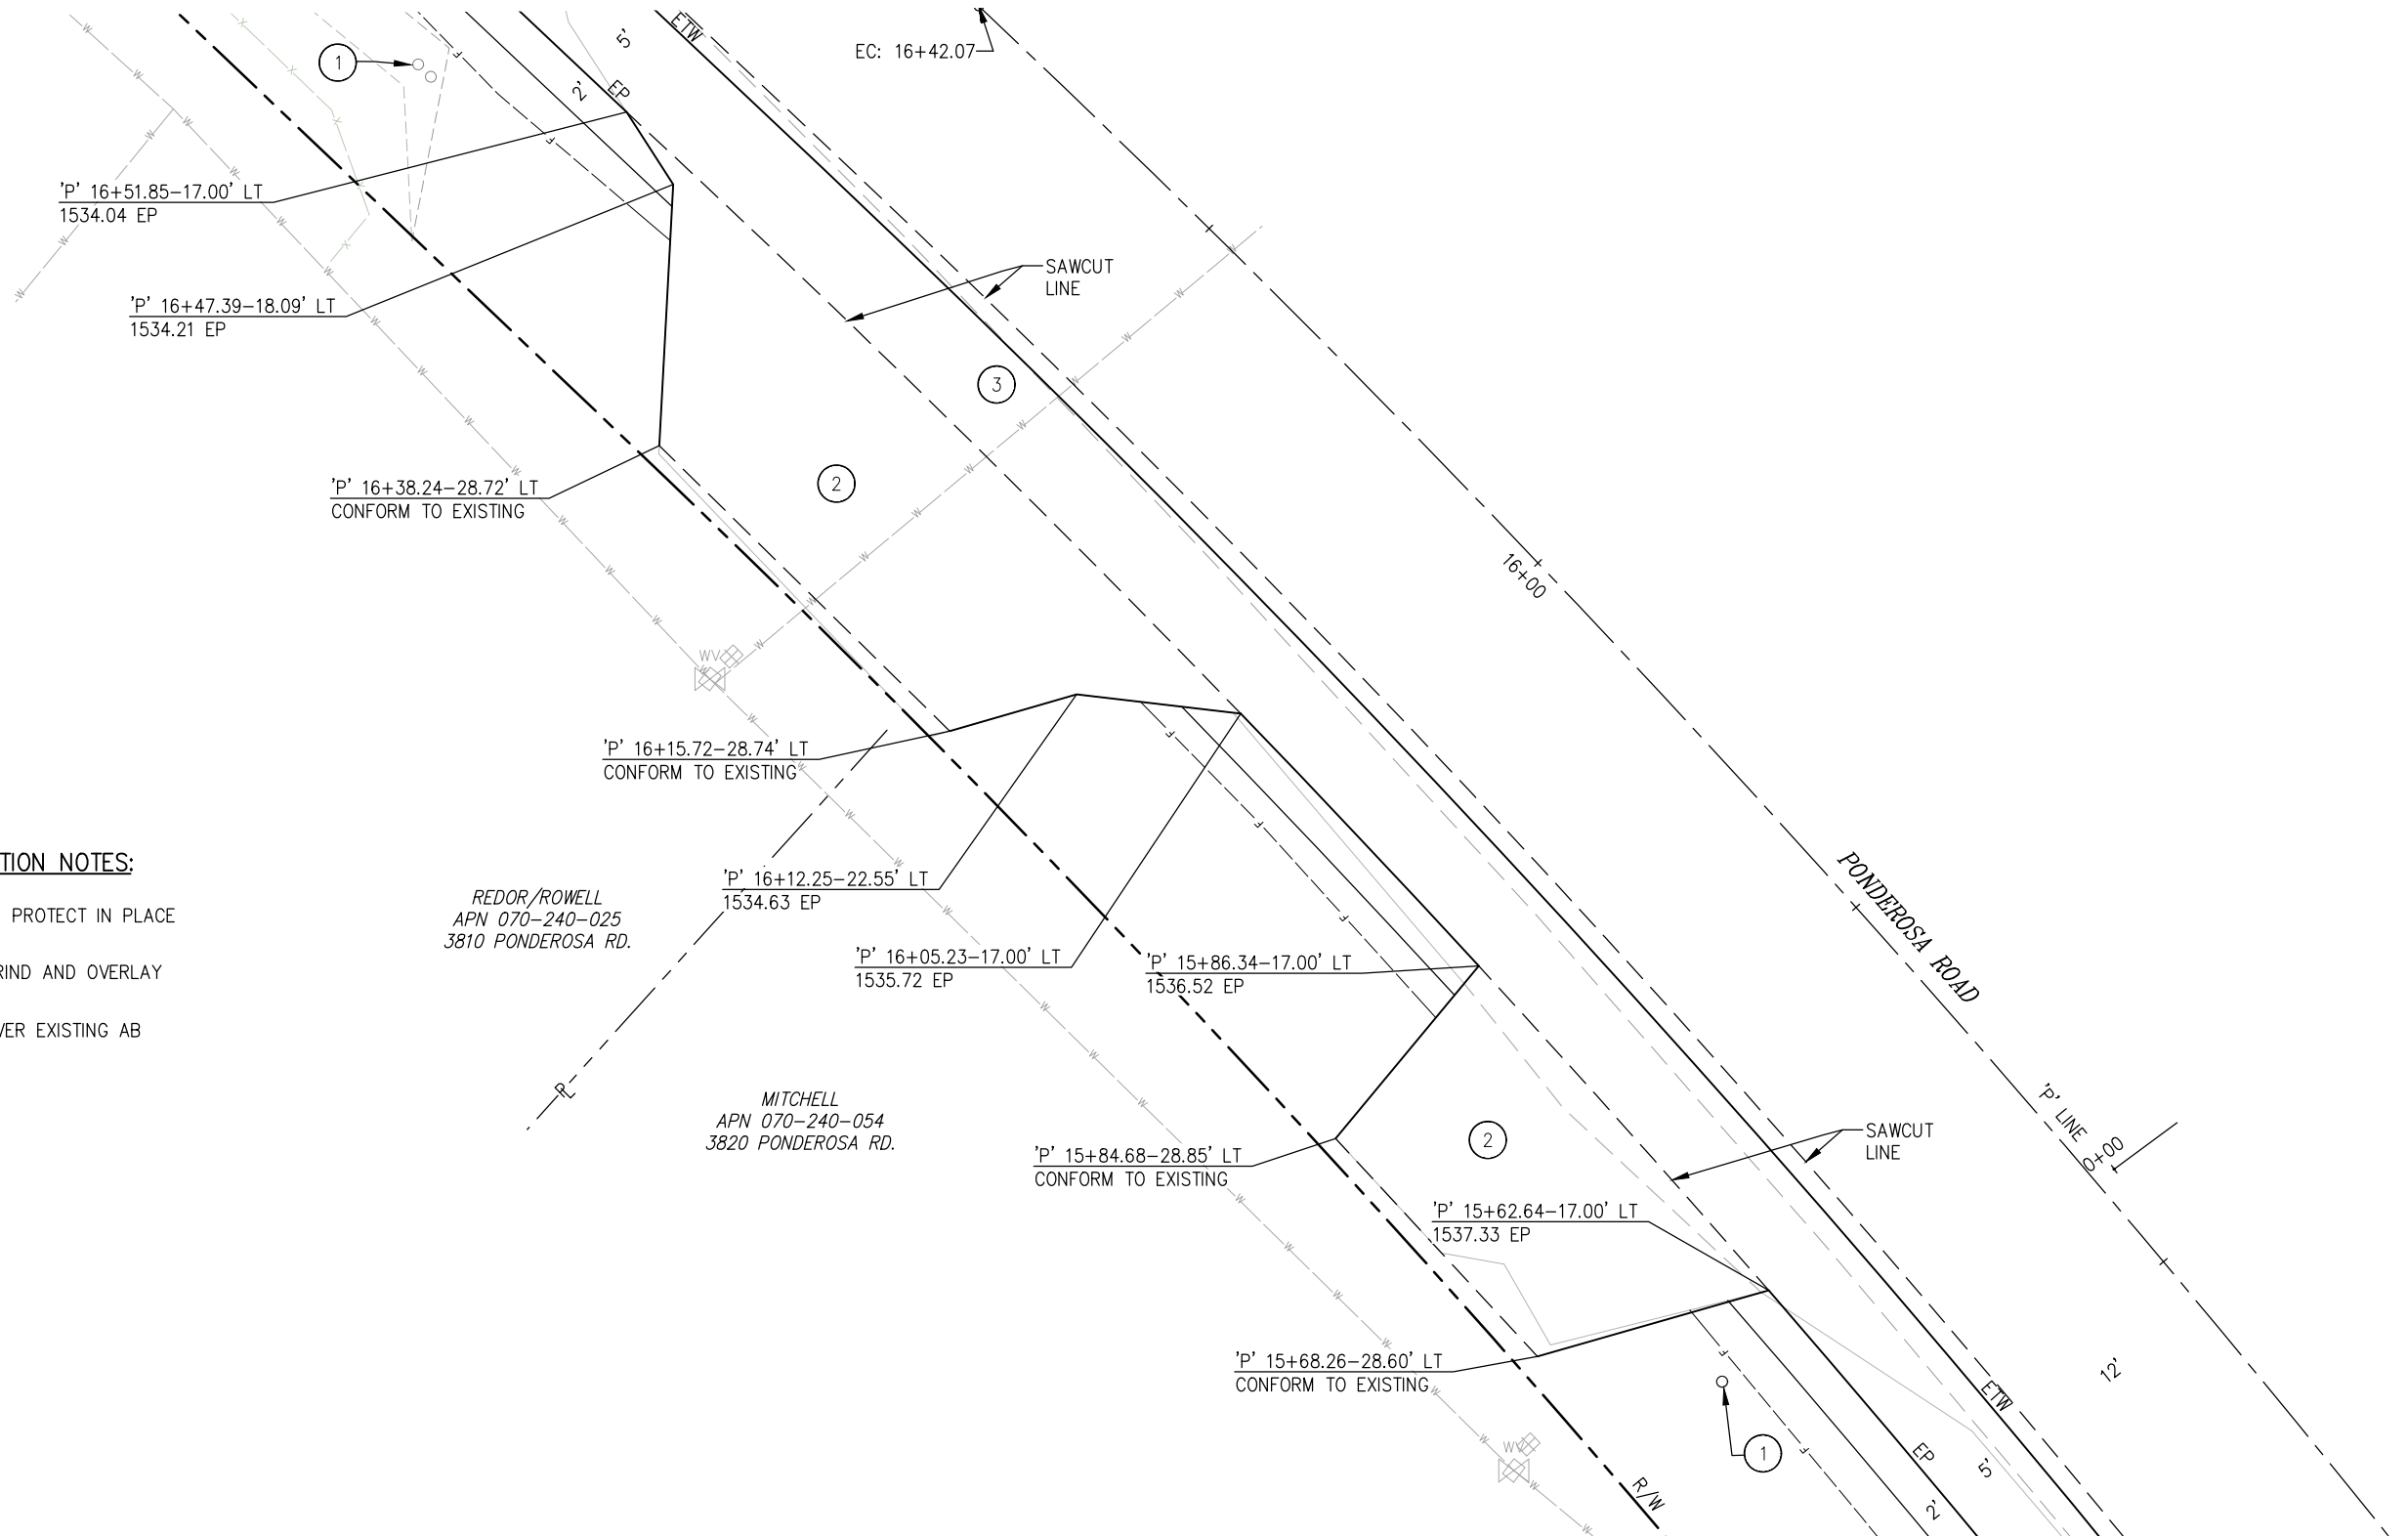

1 PLAN
DRIVEWAYS AT
3810 & 3820 PONDEROSA RD.
APN: 070-240-025 & 054
SCALE: 1"=5'

- NOTES:**
1. STATION OFFSET CALLOUTS PER 'P' ALIGNMENT.
 2. UNLESS NOTED, CUT/FILL SLOPES TO BE 2:1.

DRIVEWAY
CONSTRUCTION DETAILS
SCALE : AS NOTED

REVISION	NUMBER	DATE	DESCRIPTION	BY



PREPARED UNDER THE SUPERVISION OF :

REGISTERED CIVIL ENGINEER
02/19/25
DATE:

DESIGNED: JB
DRAWN: DJ
CHECKED: JB
DATE: 2/12/25
ROAD NUMBER: 005



COUNTY OF EL DORADO
DEPARTMENT OF TRANSPORTATION



PONDEROSA ROAD BICYCLE AND
PEDESTRIAN IMPROVEMENTS

25-0282 Revised C 10 of 15

SHEET
C-2
10 OF 46
W.O. No.
36109009

ORIGINAL SCALE: 1"=5' IN INCHES
Drawing name: Z:\Civil 3D Projects\97018 Ponderosa Class II Sidewalk\CADD Files\SHEETS.dwg Layout Tab: C-3 Feb 20, 2025 -- 11:06am dmarkowski

FOR REDUCED PLANS

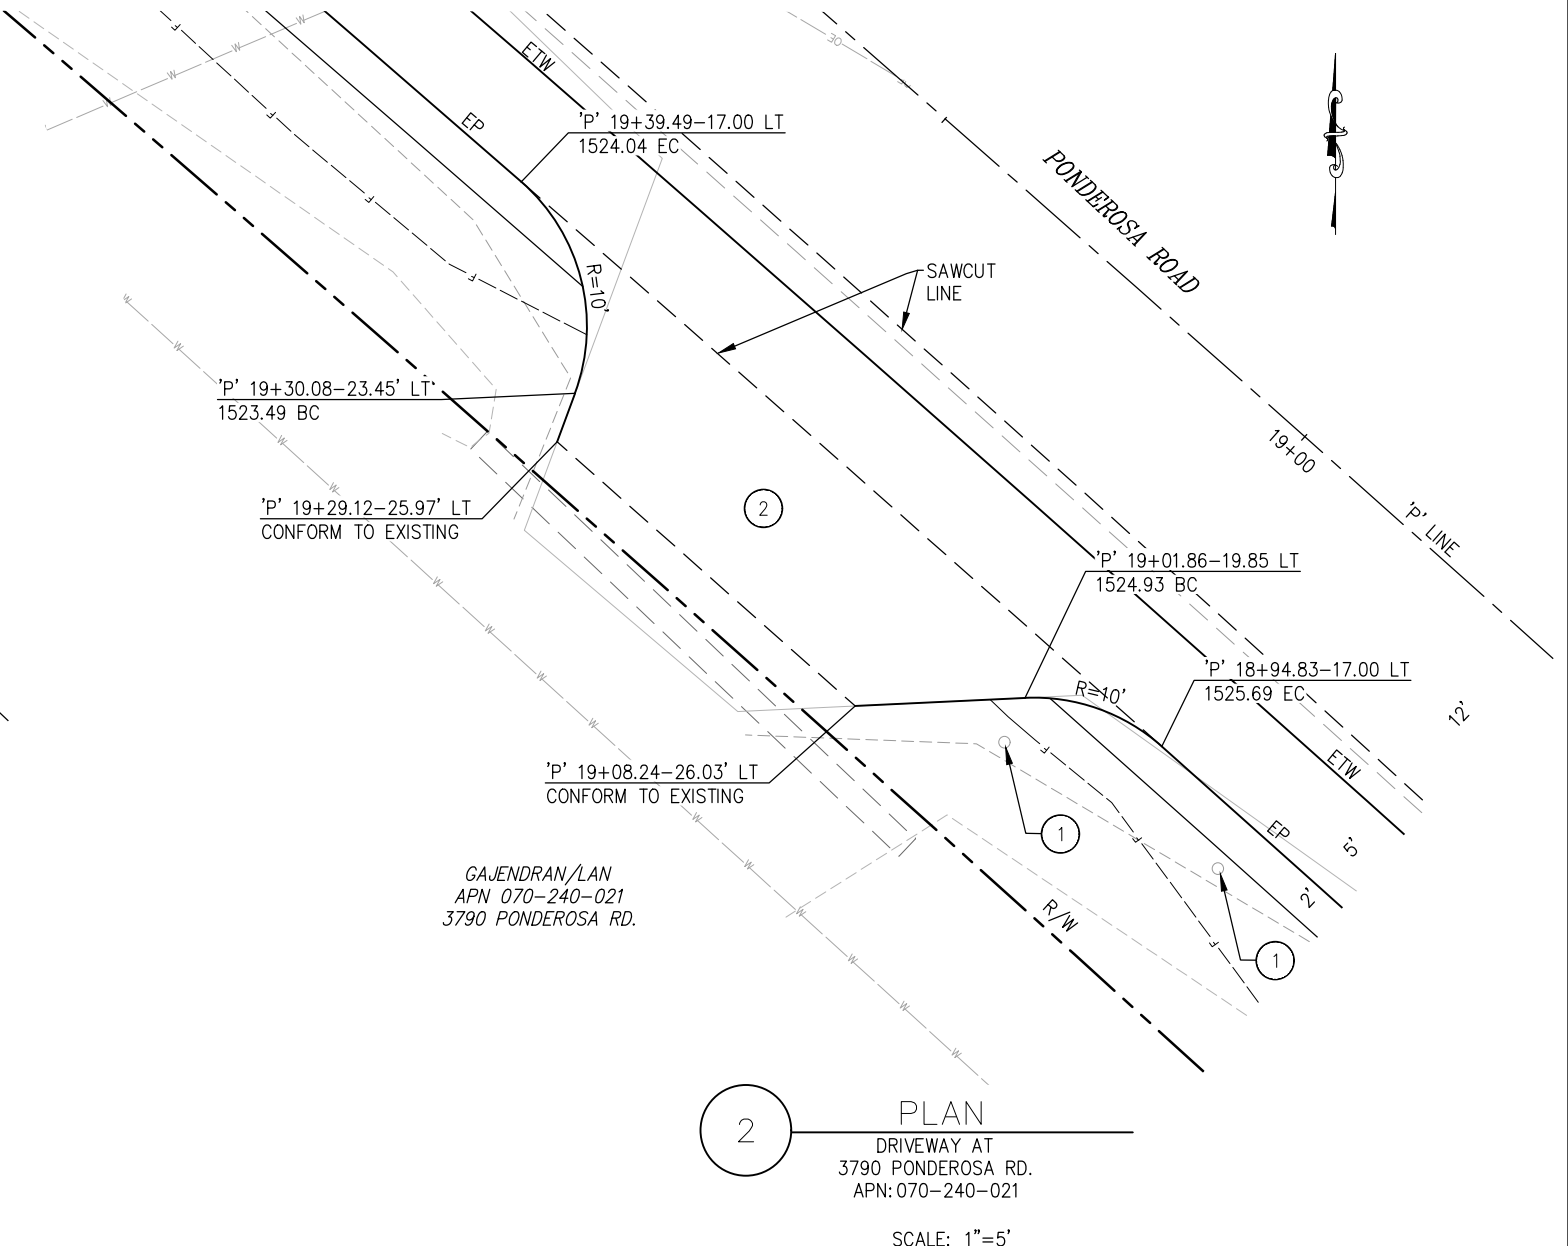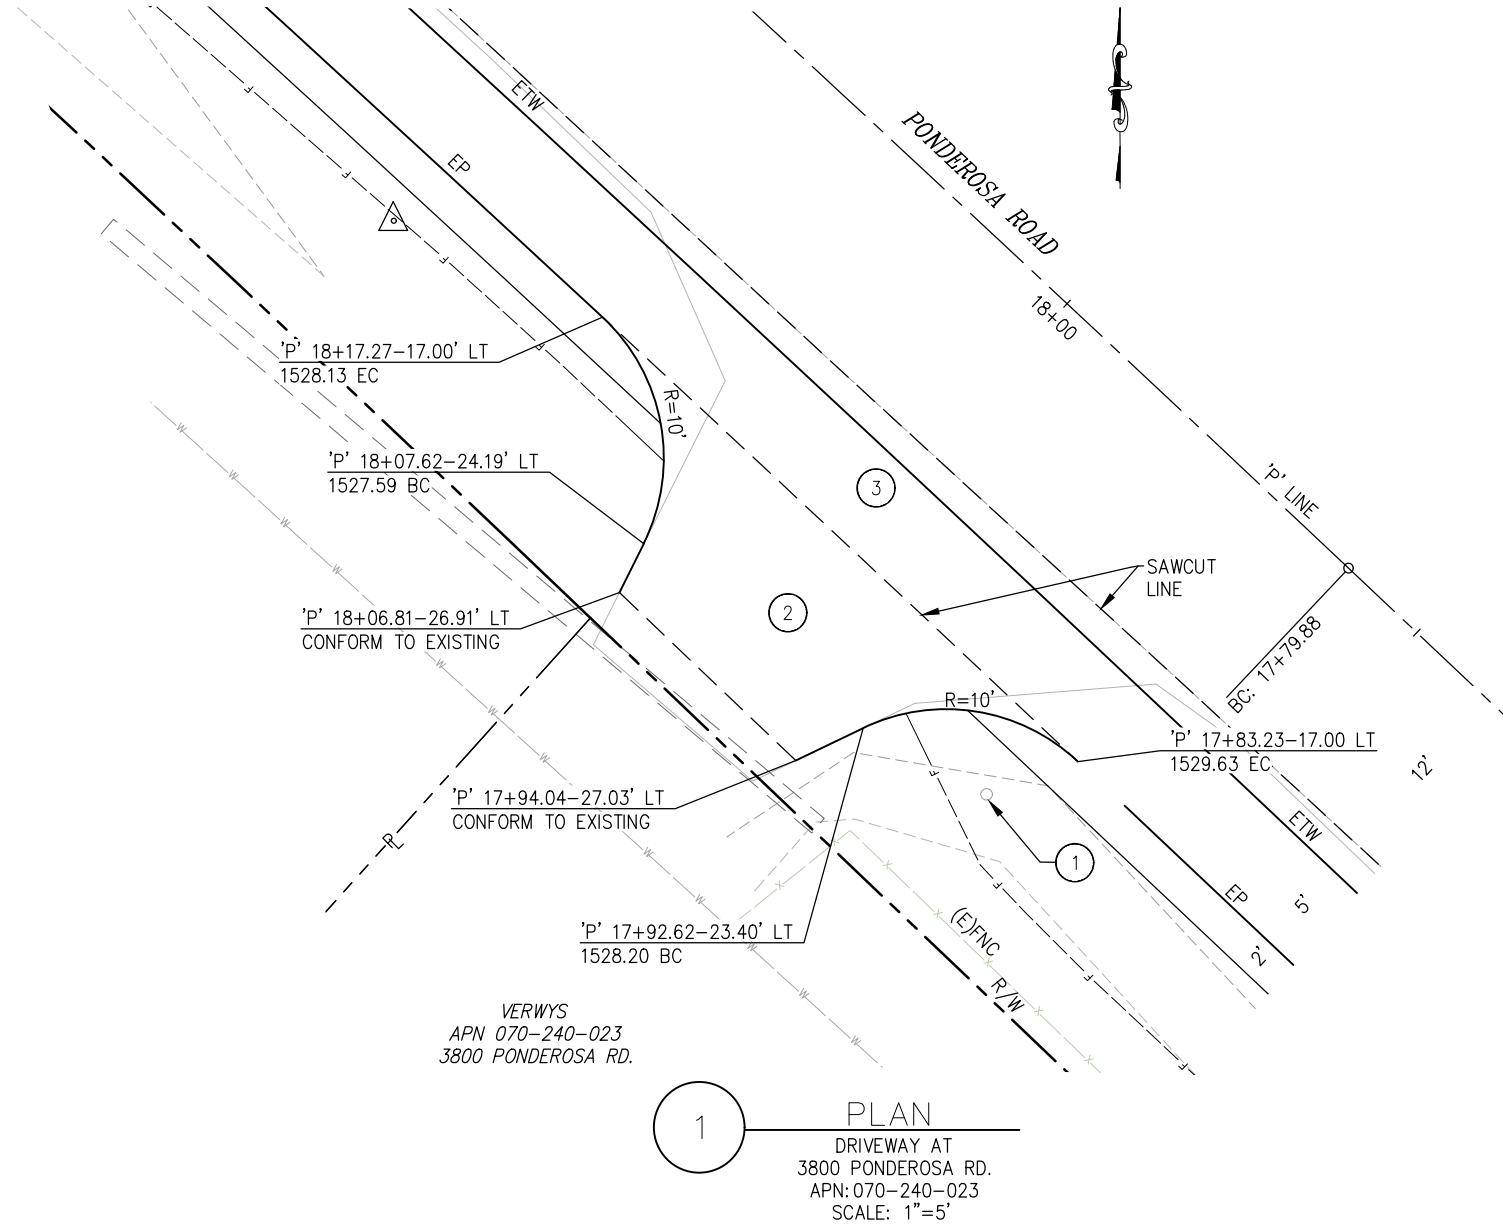

- CONSTRUCTION NOTES:
- 1 — (E)MAILBOX, PROTECT IN PLACE
 - 2 — 2" HMA, GRIND AND OVERLAY
 - 3 — 4" HMA, OVER EXISTING AB


- NOTES:
- 1. STATION OFFSET CALLOUTS PER 'P' ALIGNMENT.
 - 2. UNLESS NOTED, CUT/FILL SLOPES TO BE 2:1.

DRIVEWAY
CONSTRUCTION DETAILS
SCALE : AS NOTED

REVISION				PREPARED UNDER THE SUPERVISION OF : REGISTERED CIVIL ENGINEER 02/19/25 DATE: 02/19/25	DESIGNED: JB	DRAWN: DJ	COUNTY OF EL DORADO DEPARTMENT OF TRANSPORTATION	PONDEROSA ROAD BICYCLE AND PEDESTRIAN IMPROVEMENTS 25-0282 Revised C 11 of 15	SHEET C-3 11 OF 46 W.O. No. 36109009
					CHECKED: JB	DATE: 2/12/25			
					ROAD NUMBER: 005				
NUMBER	DATE	DESCRIPTION	BY						

ORIGINAL SCALE IS IN INCHES
Drawing name: Z:\Civil 3D Projects\97018 Ponderosa Class II Sidewalk\CADD Files\Sheets\C-SHEETS.dwg Layout Tab: C-4 Feb 20,2025 -- 11:06am dmarkowski

FOR REDUCED PLANS

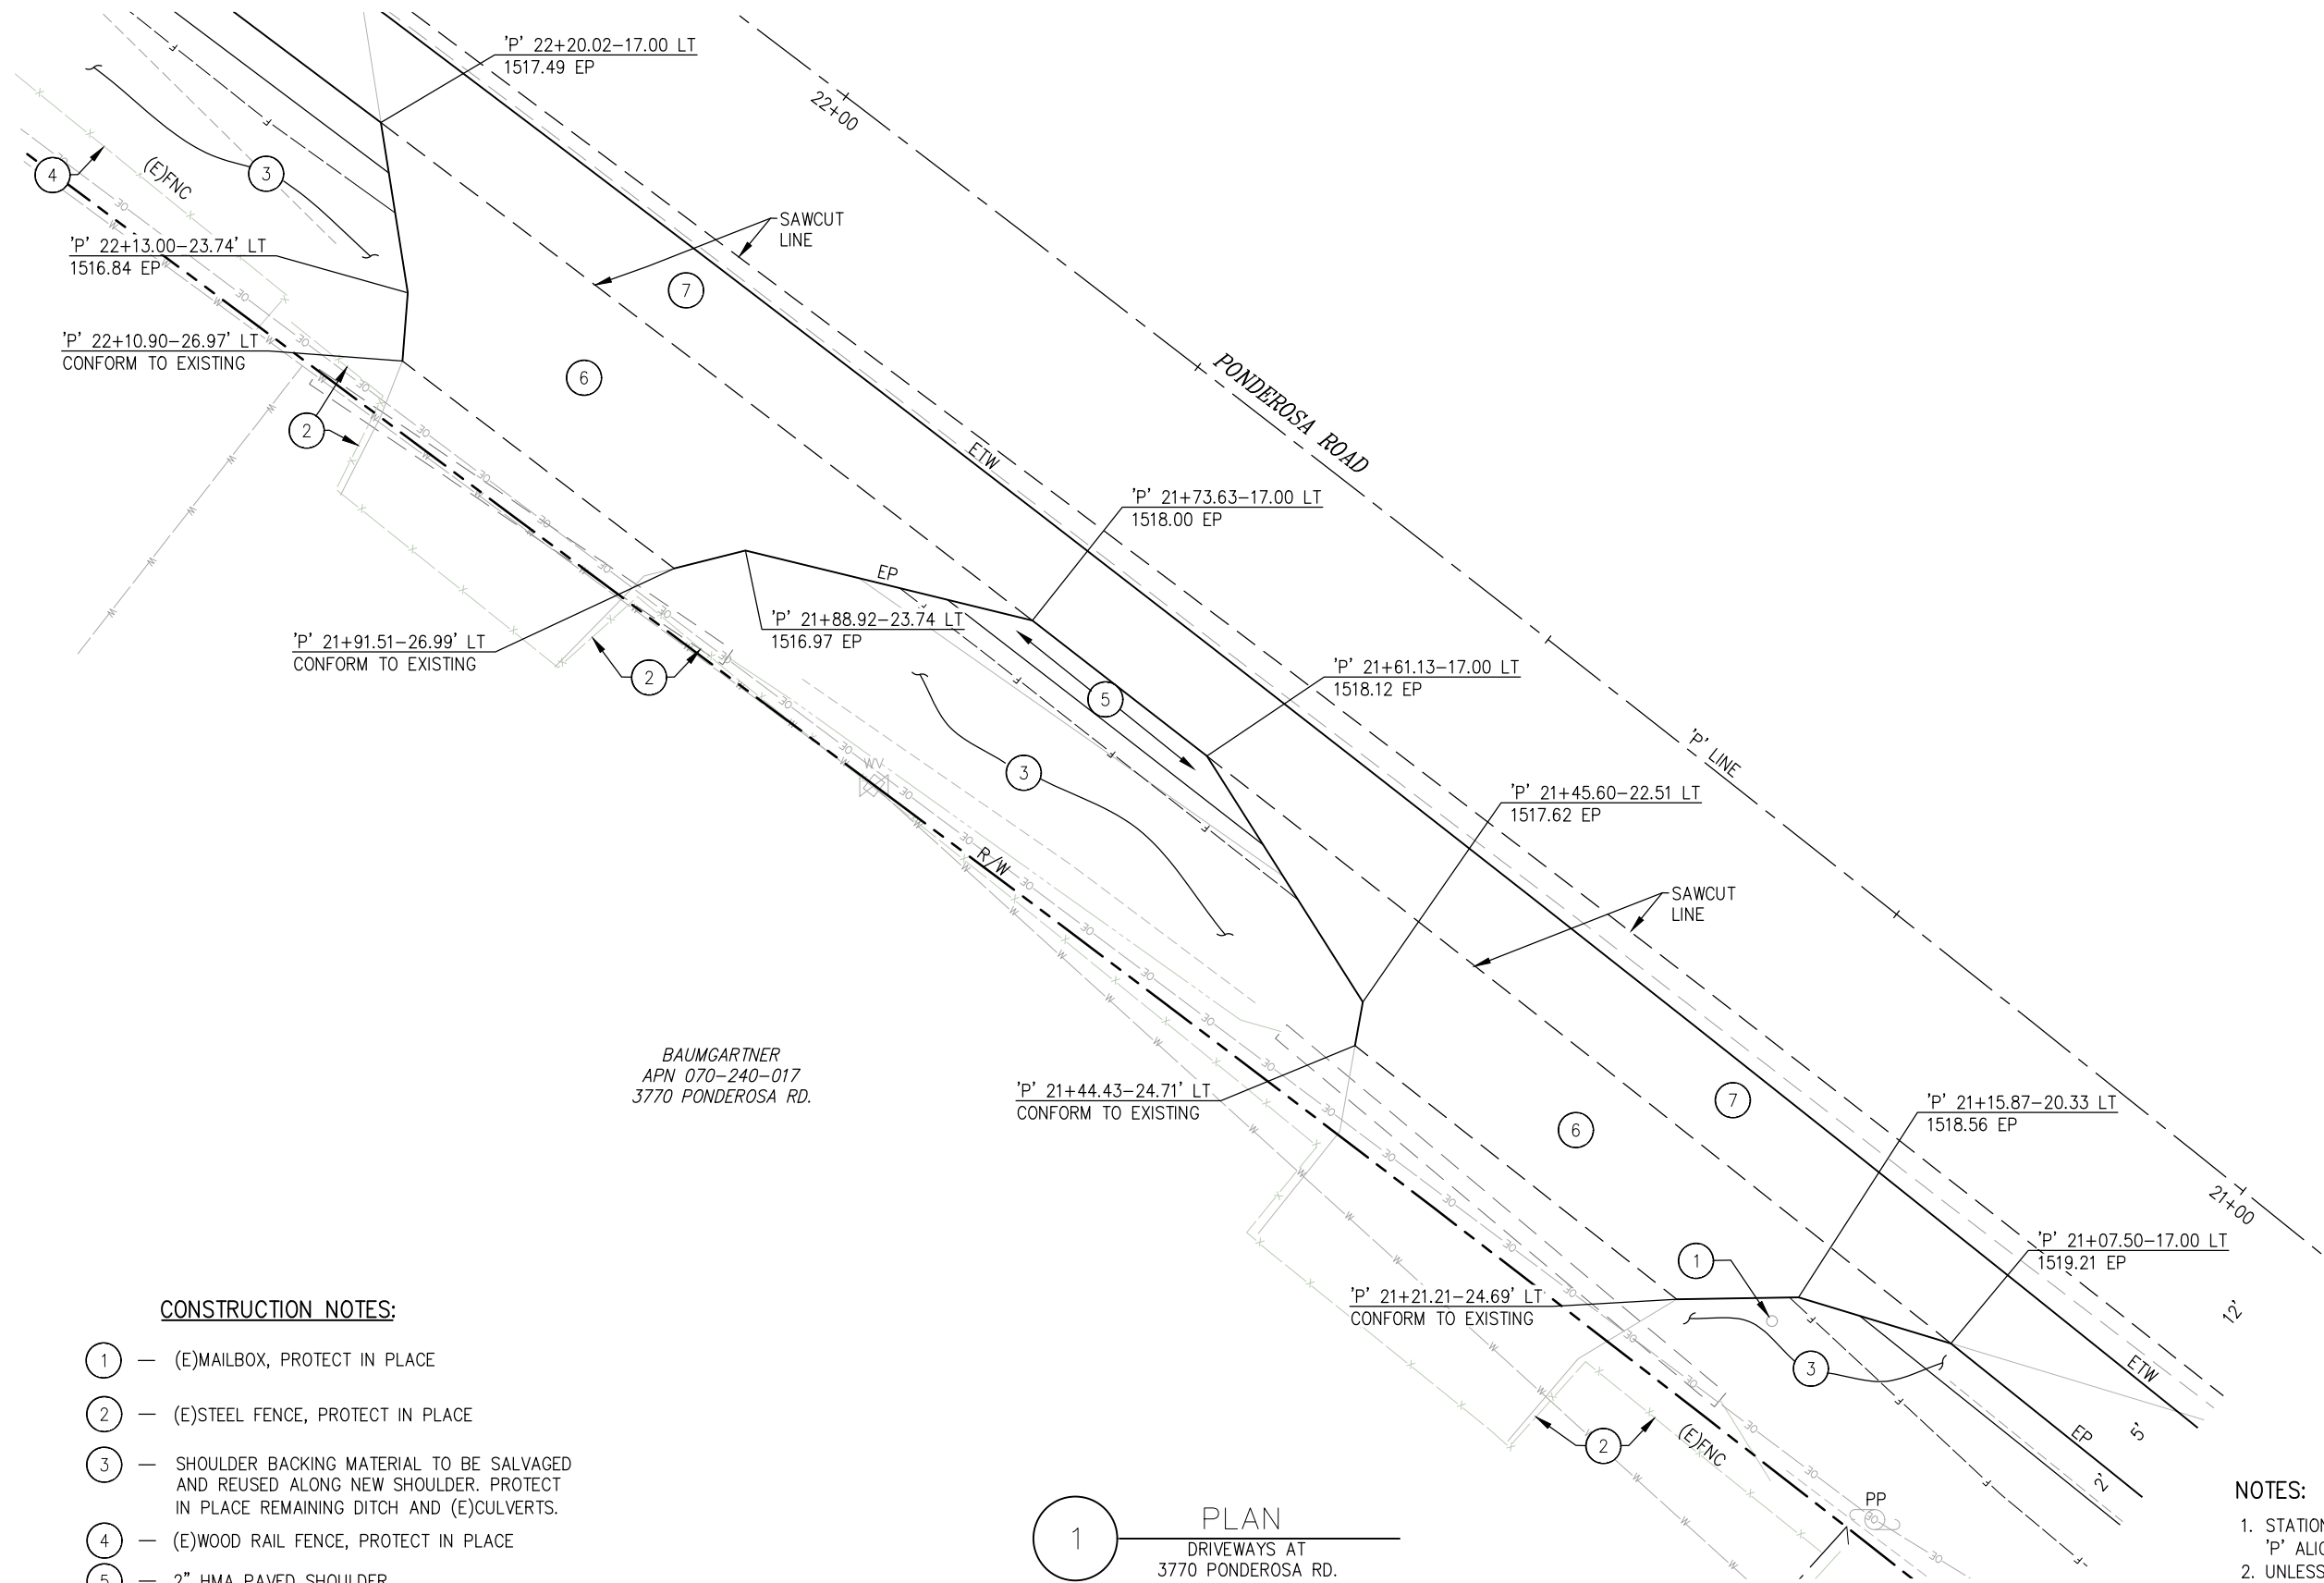

CONSTRUCTION NOTES:

- ① — (E)MAILBOX, PROTECT IN PLACE
- ② — (E)STEEL FENCE, PROTECT IN PLACE
- ③ — SHOULDER BACKING MATERIAL TO BE SALVAGED AND REUSED ALONG NEW SHOULDER. PROTECT IN PLACE REMAINING DITCH AND (E)CULVERTS.
- ④ — (E)WOOD RAIL FENCE, PROTECT IN PLACE
- ⑤ — 2" HMA PAVED SHOULDER
- ⑥ — 2" HMA, GRIND AND OVERLAY
- ⑦ — 4" HMA, OVER EXISTING AB

1 PLAN
DRIVEWAYS AT
3770 PONDEROSA RD.
APN: 070-240-017
SCALE: 1"=5'

- NOTES:**
- 1. STATION OFFSET CALLOUTS PER 'P' ALIGNMENT.
 - 2. UNLESS NOTED, CUT/FILL SLOPES TO BE 2:1.

DRIVEWAY
CONSTRUCTION DETAILS
SCALE : AS NOTED



PREPARED UNDER THE SUPERVISION OF :

REGISTERED CIVIL ENGINEER
02/19/25
DATE:

DESIGNED: JB
DRAWN: DJ
CHECKED: JB
DATE: 2/12/25
ROAD NUMBER: 005



COUNTY OF EL DORADO
DEPARTMENT OF TRANSPORTATION

PONDEROSA ROAD BICYCLE AND
PEDESTRIAN IMPROVEMENTS
25-0282 Revised C 12 of 15

SHEET
C-4
12 OF 46
W.O. No.
36109009

ORIGINAL SCALE IS IN INCHES
Drawing name: Z:\Civil 3D Projects\97018 Ponderosa Class II Sidewalk\CADD Files\Sheets\C-SHEETS.dwg Layout Tab: C-5 Feb 20,2025 -- 11:06am dmarkowski

FOR REDUCED PLANS

WARNER
APN 070-240-013
3750 PONDEROSA RD.

CONSTRUCTION NOTES:

- 1 — (E)CULVERT MARKER, PROTECT IN PLACE
- 2 — (E)FIRE HYDRANT, PROTECT IN PLACE
- 3 — (E)ROAD SIGN, PROTECT IN PLACE
- 4 — 2" HMA, GRIND AND OVERLAY
- 5 — 4" HMA, OVER EXISTING AB

1 PLAN
GROVE LANE
SCALE: 1"=5'

BAUMGARTNER
APN 070-240-017
3770 PONDEROSA RD.

- NOTES:
- 1. STATION OFFSET CALLOUTS PER 'P' ALIGNMENT.
 - 2. UNLESS NOTED, CUT/FILL SLOPES TO BE 2:1.
 - 3. PROTECT EXIST. 24" CMP

GROVE LANE
CONSTRUCTION DETAILS
SCALE : AS NOTED

REVISION	NUMBER	DATE	DESCRIPTION	BY



PREPARED UNDER THE SUPERVISION OF :
REGISTERED CIVIL ENGINEER
02/19/25
DATE:

DESIGNED: JB
CHECKED: JB
DATE: 2/12/25
ROAD NUMBER: 005




COUNTY OF EL DORADO
DEPARTMENT OF TRANSPORTATION

PONDEROSA ROAD BICYCLE AND
PEDESTRIAN IMPROVEMENTS
25-0282 Revised C 13 of 15

SHEET
C-5
13 OF 46
W.O. No.
36109009


ORIGINAL SCALE IS IN INCHES
Drawing name: Z:\Civil 3D Projects\97018 Ponderosa Class II Sidewalk\CADD Files\Sheets\C-SHEETS.dwg Layout Tab: C-6 Feb 20, 2025 -- 11:06am dmarkowski

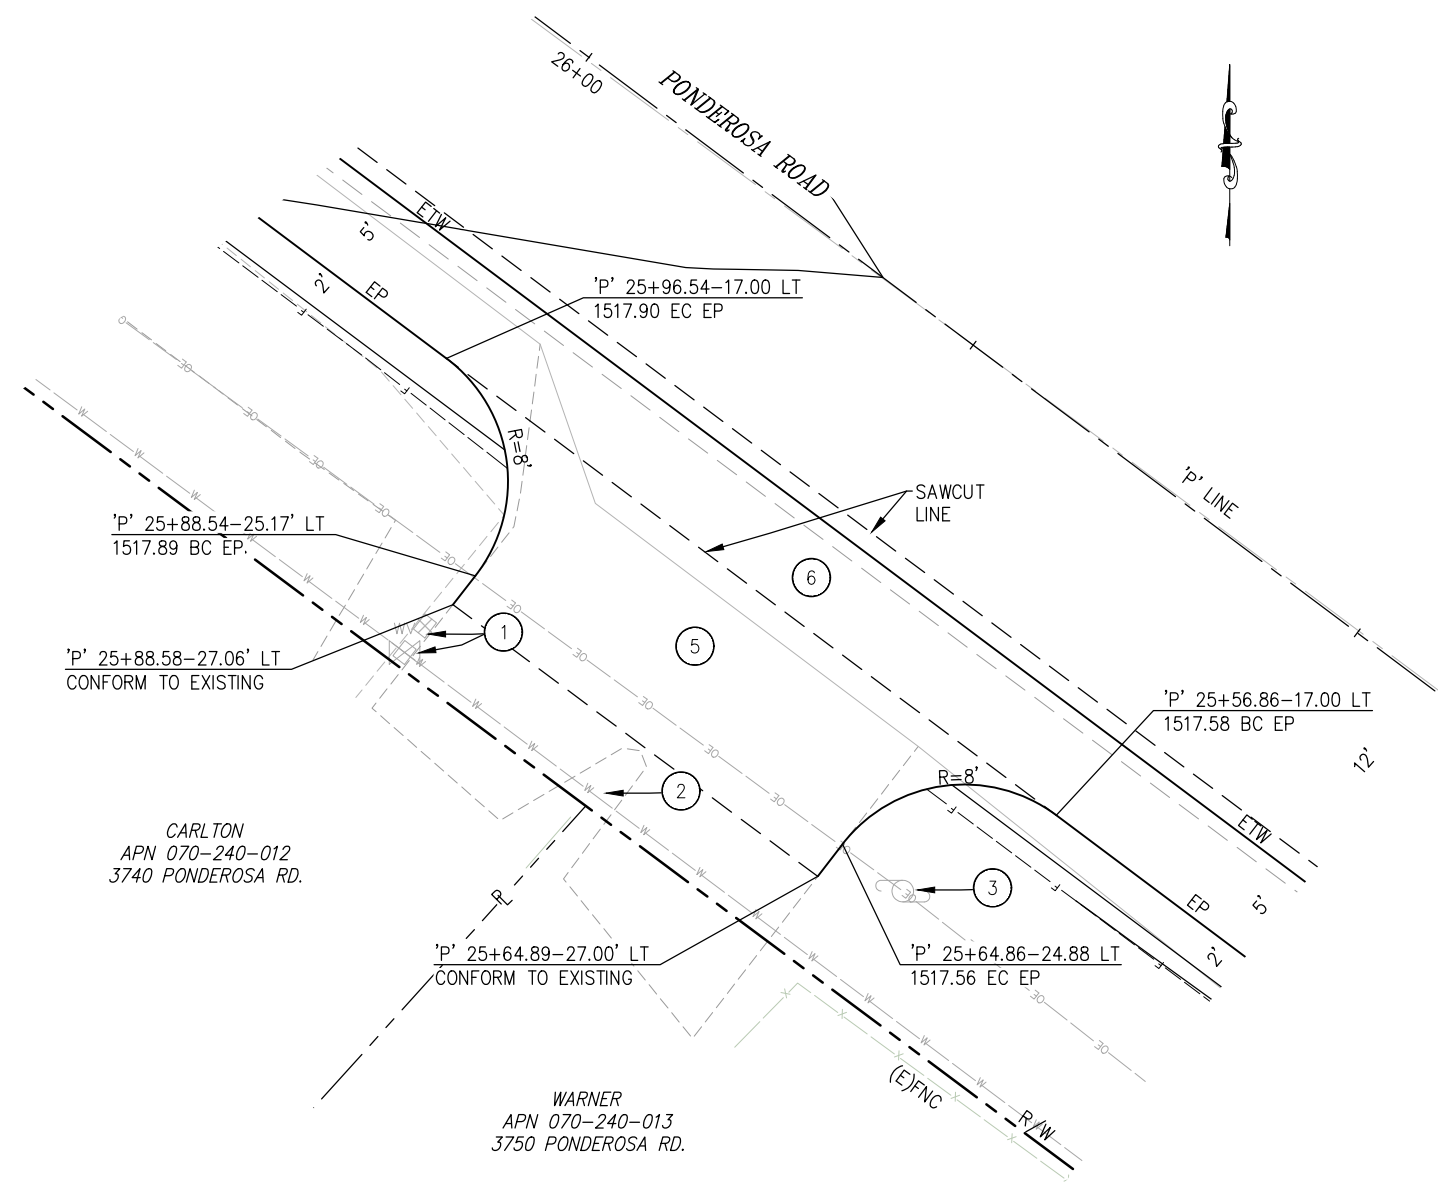

1 PLAN
DRIVEWAYS AT
3740 & 3750 PONDEROSA RD.
APN: 070-240-012 & 013
SCALE: 1"=5'

CONSTRUCTION NOTES:

- ① — (E)WATER VALVE, PROTECT IN PLACE
- ② — (E)FENCE AND GATE, PROTECT IN PLACE
- ③ — (E)POWER POLE, PROTECT IN PLACE
- ④ — (E)MAILBOX, PROTECT IN PLACE
- ⑤ — 2" HMA, GRIND AND OVERLAY
- ⑥ — 4" HMA, OVER EXISTING AB

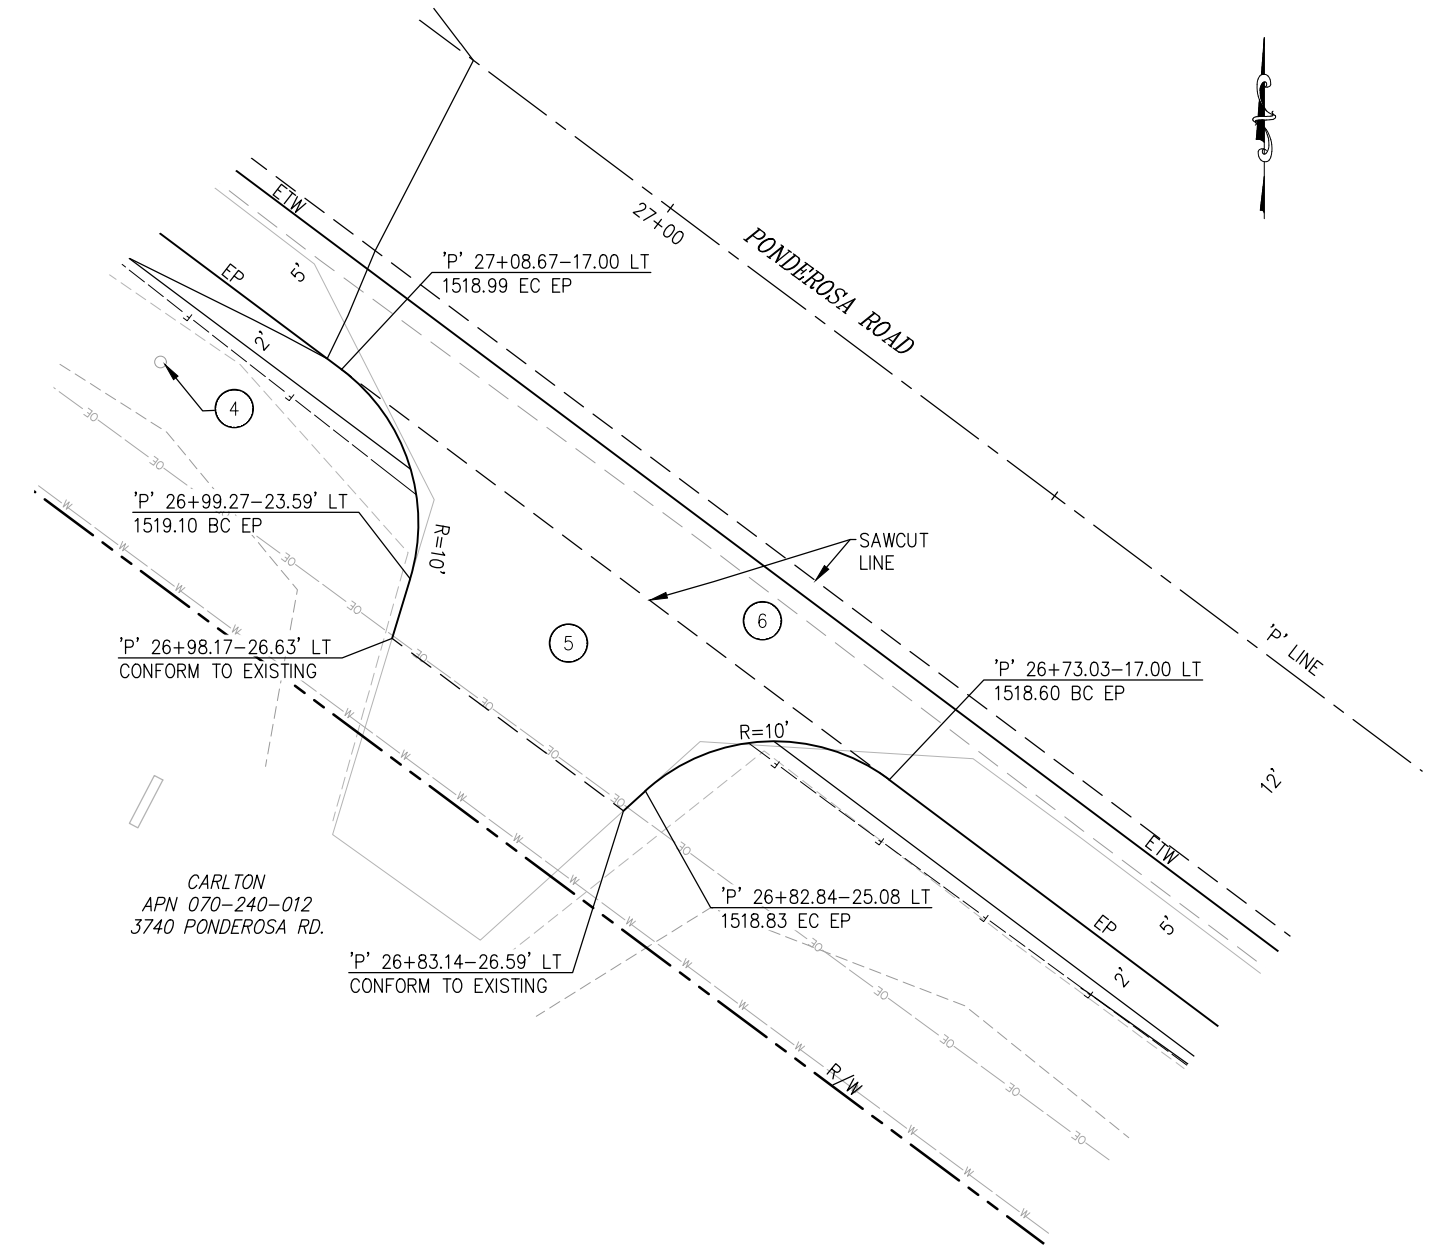

2 PLAN
DRIVEWAY AT
3740 PONDEROSA RD.
APN: 070-240-012
SCALE: 1"=5'

NOTES:

- 1. STATION OFFSET CALLOUTS PER 'P' ALIGNMENT.
- 2. UNLESS NOTED, CUT/FILL SLOPES TO BE 2:1.

DRIVEWAY
CONSTRUCTION DETAILS
SCALE : AS NOTED

REVISION	NUMBER	DATE	DESCRIPTION	BY

PREPARED UNDER THE SUPERVISION OF :

REGISTERED CIVIL ENGINEER
DATE: 02/19/25

DESIGNED: JB
CHECKED: JB
ROAD NUMBER: 005


DRAWN: DJ
DATE: 2/12/25

COUNTY OF EL DORADO
DEPARTMENT OF TRANSPORTATION

25-0282 Revised C 14 of 15

SHEET
C-6
14 OF 46
W.O. No. 36109009


ORIGINAL SCALE IS IN INCHES
Drawing name: Z:\Civil 3D Projects\97018 Ponderosa Class II Sidewalk\CADD Files\Sheets\C-SHEETS.dwg Layout Tab: C-7 Feb 20, 2025 -- 11:06am dmarkowski

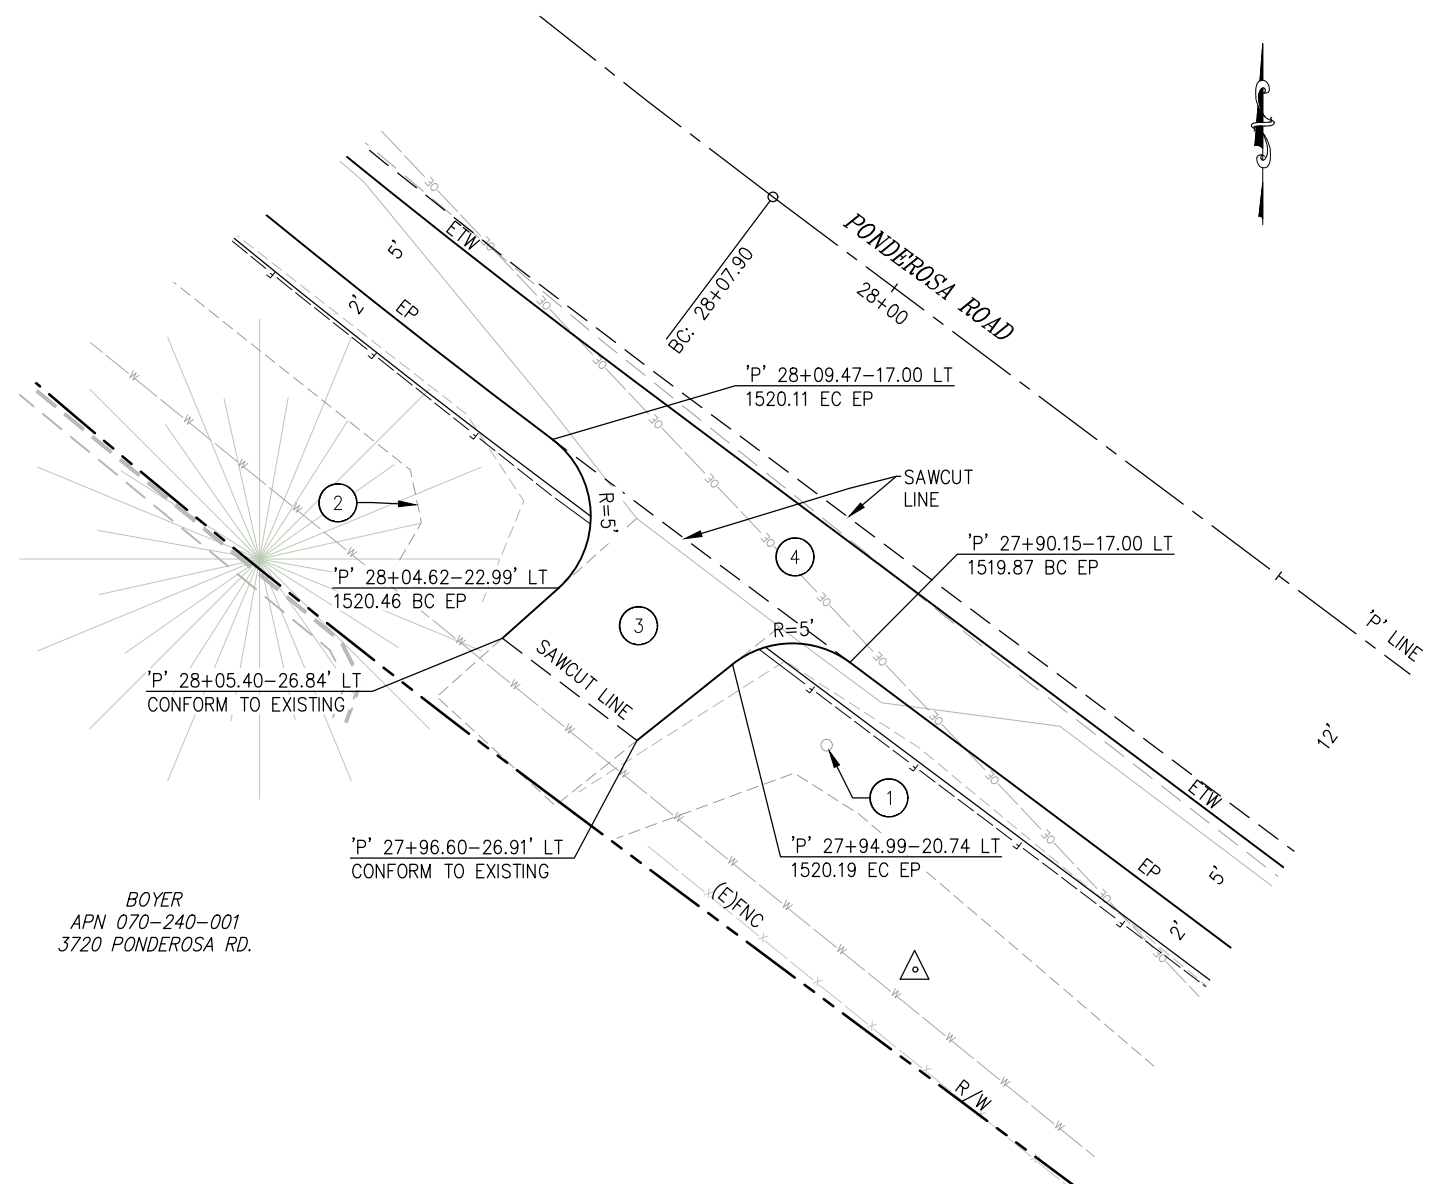

1 PLAN
DRIVEWAY AT
3720 PONDEROSA RD.
APN: 070-240-001
SCALE: 1"=5'

CONSTRUCTION NOTES:

- 1 (E)MAILBOX, PROTECT IN PLACE
- 2 (E)RETAINING WALL, PROTECT IN PLACE
- 3 2" HMA, GRIND AND OVERLAY
- 4 4" HMA, OVER EXISTING AB

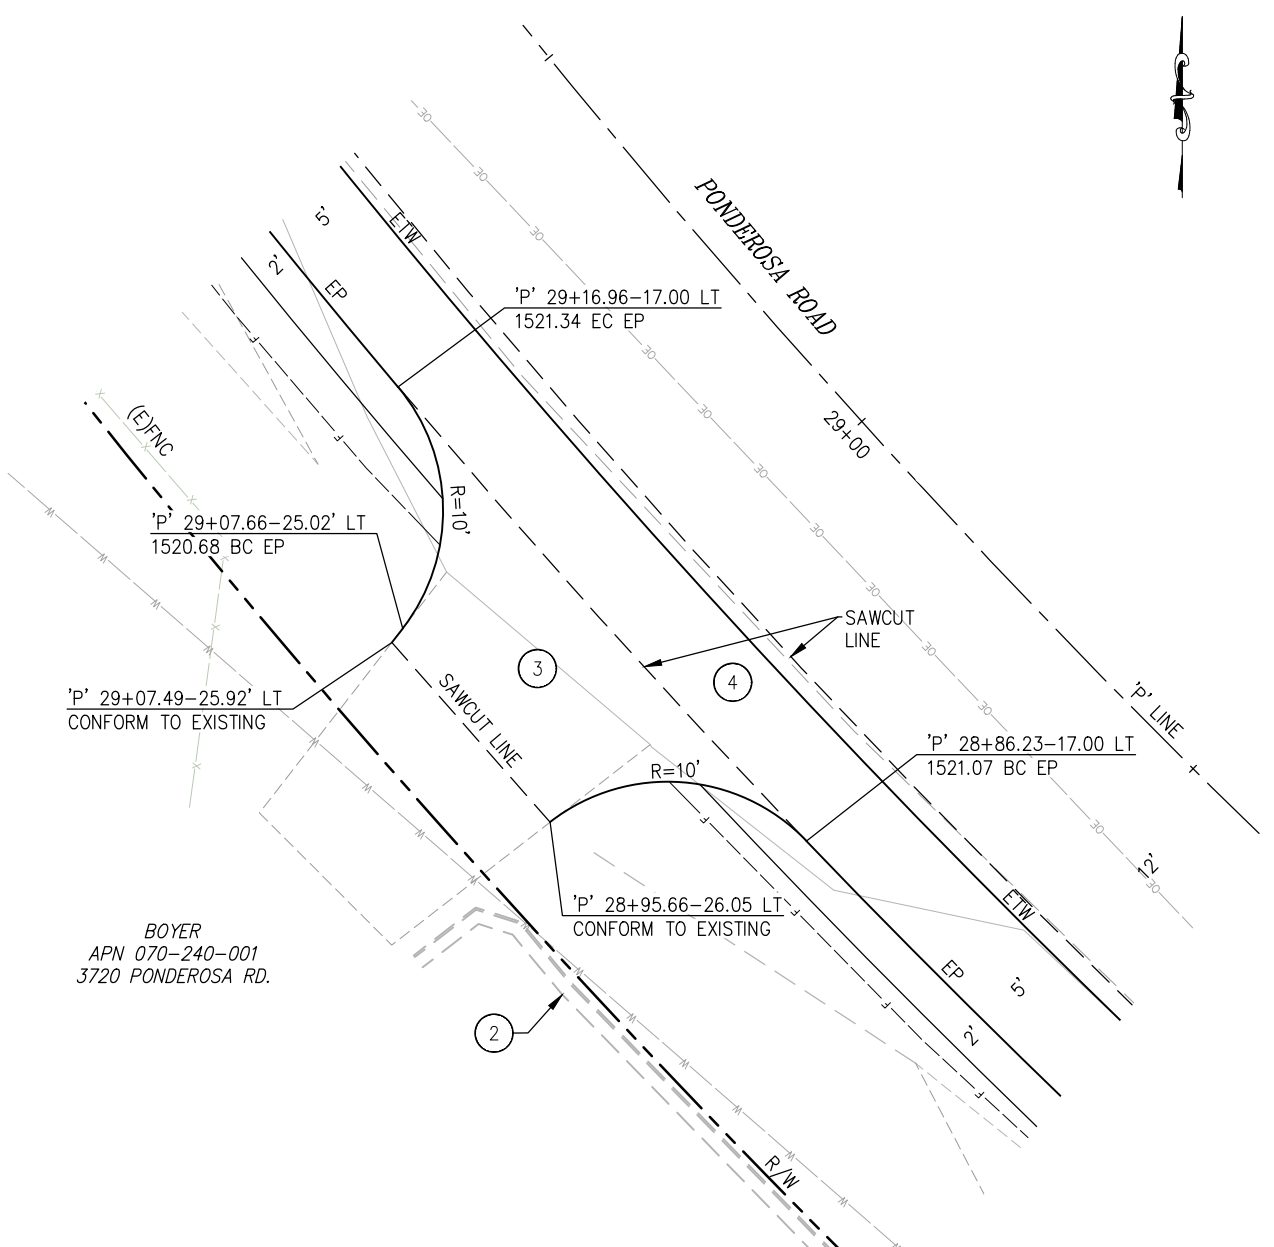

2 PLAN
DRIVEWAY AT
3720 PONDEROSA RD.
APN: 070-240-001
SCALE: 1"=5'

- NOTES:
- 1. STATION OFFSET CALLOUTS PER 'P' ALIGNMENT.
 - 2. UNLESS NOTED, CUT/FILL SLOPES TO BE 2:1.

DRIVEWAY
CONSTRUCTION DETAILS
SCALE : AS NOTED

REVISION	NUMBER	DATE	DESCRIPTION	BY

PREPARED UNDER THE SUPERVISION OF :

REGISTERED CIVIL ENGINEER
DATE: 02/19/25

DESIGNED: JB
CHECKED: JB
ROAD NUMBER: 005

DRAWN: DJ
DATE: 2/12/25

COUNTY OF EL DORADO
DEPARTMENT OF TRANSPORTATION

25-0282 Revised C 15 of 15

SHEET
C-7
15 OF 46
W.O. No.
36109009