

INDEX OF SHEETS


SHEET	PLAN SHEET	TITLE
1		TITLE SHEET
2-6	CD-1 THRU CD-6	SURVEY CONTROL DIAGRAM
7-10	X-1 THRU X-4	TYPICAL SECTIONS
11-31	L-1 THRU L-21	LAYOUT AND PROFILE
32-35	C-1 THRU C-4	CONSTRUCTION DETAILS
36-37	SC-1 THRU SC-2	CONSTRUCTION AREA SIGNS
38-49	D-1 THRU D-12	DRAINAGE PLAN & PROFILE
50-51	DQ-1 THRU DQ-2	DRAINAGE QUANTITIES
52-61	RW-1 THRU RW-10	RETAINING WALL PLAN AND PROFILE
62-72	SPD-1 THRU SPD-11	PAVEMENT & SIGN DELINEATION
73	SPD-12	SIGNING DETAILS
74-75	SPD-13 THRU SPD-14	PAVEMENT & SIGN QUANTITIES
76-85	TR-1 THRU TR-10	TREE REMOVAL PLAN
86-88	TR-11 THRU TR-13	TREE REMOVAL QUANTITIES
89-98	EC-1 THRU EC-10	EROSION CONTROL
99-103	E-1 THRU E-5	ELECTRICAL PLAN

COUNTY OF EL DORADO, CA
DEPARTMENT OF TRANSPORTATION

PROJECT PLANS FOR THE CONSTRUCTION OF
EL DORADO TRAIL EXTENSION
MISSOURI FLAT ROAD TO EL DORADO

IN THE COUNTY OF EL DORADO, DISTRICT III


To be supplemented with Standard Plans and Specifications dated 2015, including the 2015 Revised Standard Specifications, of the California Department of Transportation, unless otherwise noted.

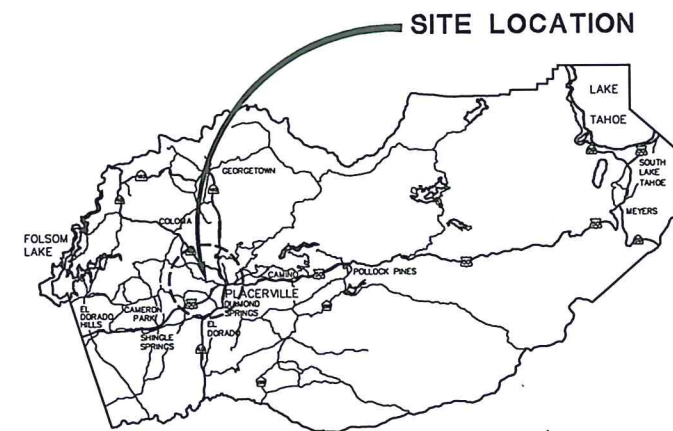

VICINITY MAP
COUNTY OF EL DORADO

BOARD OF SUPERVISORS
JOHN HIDAH
SHIVA FRENTZEN
BRIAN VEERKAMP
LORI PARLIN
SUE NOVASEL


COUNTY OF EL DORADO
DEPARTMENT OF TRANSPORTATION
(530) 621-5900
2850 FAIRLANE CT
PLACERVILLE, CA 95667

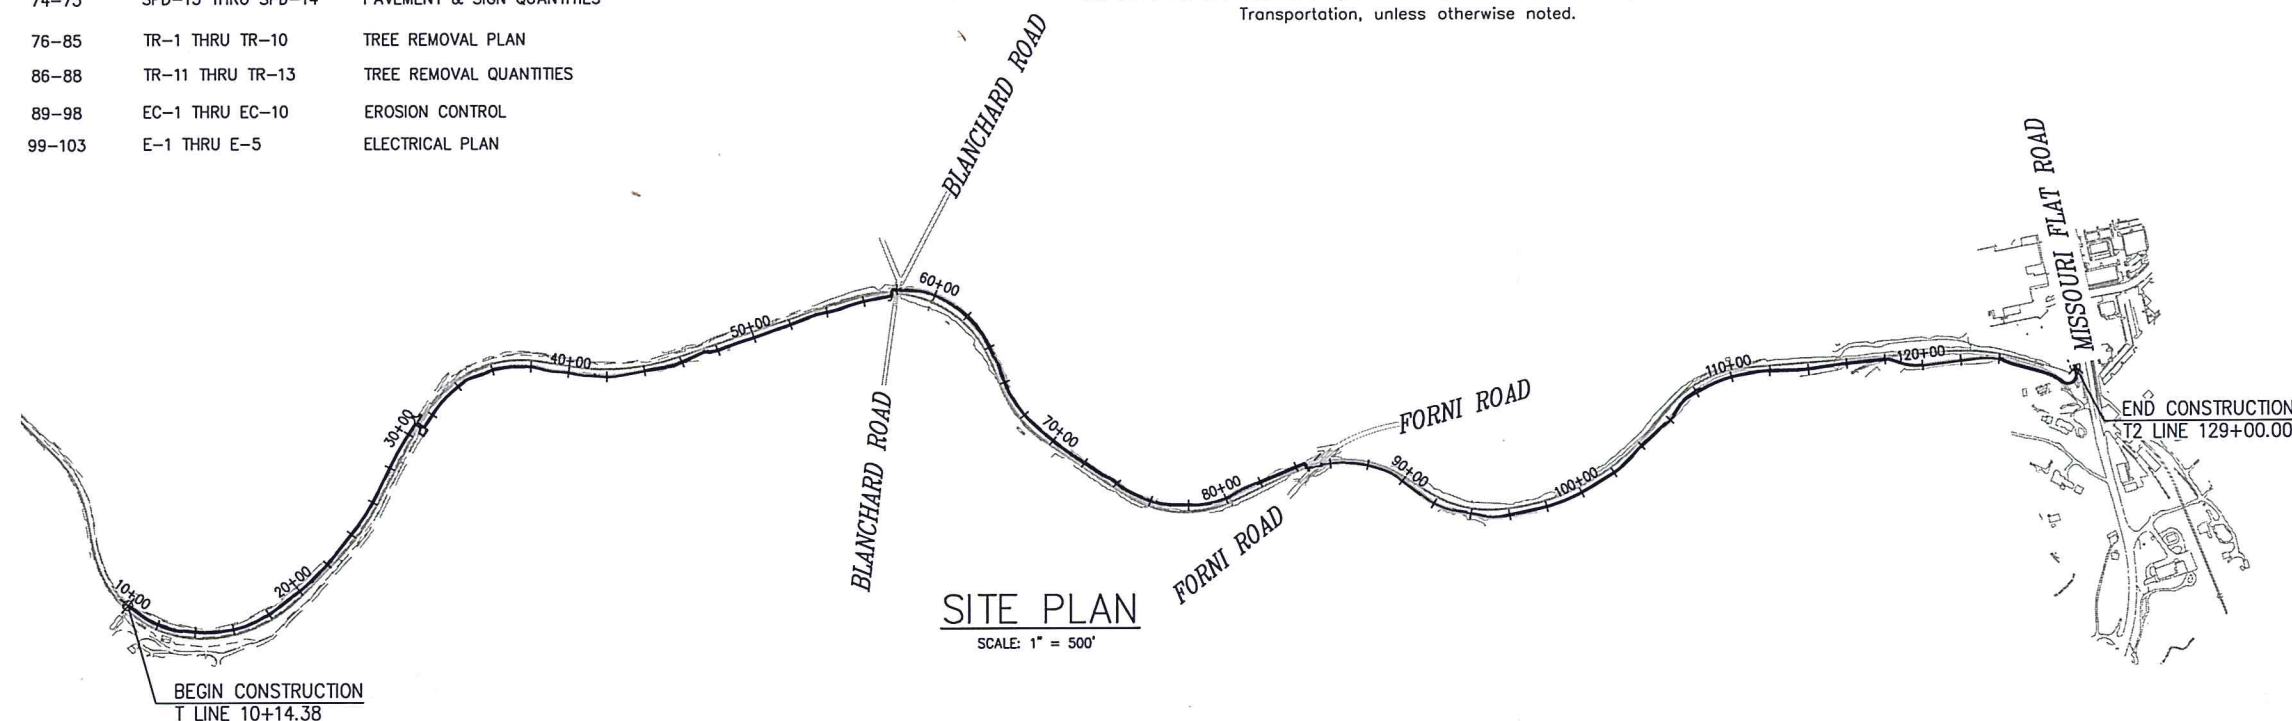

SITE PLAN
SCALE: 1" = 500'

PROJECT DESCRIPTION:

CONSTRUCTION OF APPROXIMATELY 2.2 MILES OF AN 8-FOOT WIDE PAVED CLASS 1 MULTI-USE BICYCLE AND PEDESTRIAN TRAIL, WITH SIGNAGE AND ROAD CROSSING AT BLANCHARD ROAD AND FORNI ROAD.

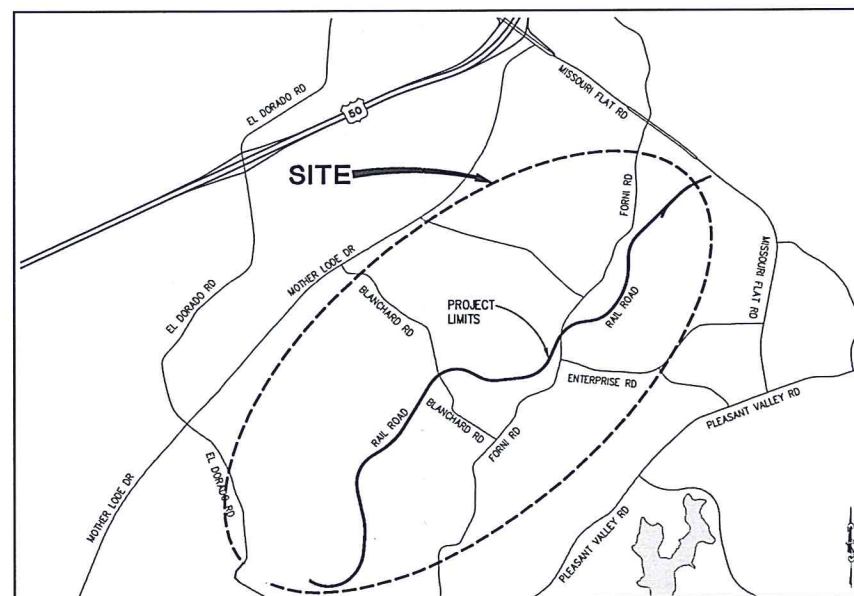

LOCATION MAP
NOT TO SCALE

FEDERAL AID PROJECT
CML 5925 (129)

CONTRACTOR'S LICENSE CLASSIFICATION: Bidders shall be properly licensed to perform the Work pursuant to the State Contractor's License Act (Business and Professions Code section 7000 et seq.) and shall possess a CLASS A LICENSE or equivalent combination of Classes required by the categories and type of Work included in the Contract Documents and Plans. Failure of the successful Bidder to obtain proper and adequate licensing at the time bids are submitted shall constitute a failure to execute the Contract, and forfeiture as provided under that section.

REVISIONS

MARK	DATE	BY



SUBMITTED BY: *[Signature]* DATE: 3/5/2019
DUSTIN W. HARRINGTON
REGISTERED CIVIL ENGINEER No. 71517

ADOPTED AND APPROVED BY: *[Signature]* DATE: 3/5/2019
SUE NOVASEL, CHAIR, EL DORADO COUNTY BOARD OF SUPERVISORS
APPROVED BY: *[Signature]* DATE: 3/7/19
RAFAEL MARTINEZ, DIRECTOR, DEPARTMENT OF TRANSPORTATION
MATTHEW D. SWEETZER, P.E. No. C58532, DEPUTY DIRECTOR, ENGINEER

CONTRACT NO. 2778 PROJECT NO. 97014
EL DORADO TRAIL EXTENSION
MISSOURI FLAT ROAD
TO EL DORADO
TITLE SHEET
SHEET 1 OF 103