


COUNTY OF EL DORADO, CA
DEPARTMENT OF TRANSPORTATION

PROJECT PLANS FOR THE CONSTRUCTION OF
PONDEROSA ROAD CLASS II
BIKE PATH AND SIDEWALK

IN THE COUNTY OF EL DORADO, DISTRICT 4
IN THE TOWN OF SHINGLE SPRINGS, ON PONDEROSA ROAD,
BETWEEN FOXWOOD LANE AND MINESHAFT LANE

To be supplemented with Standard Plans and Specifications dated 2024, including
the amendments to the 2024 Revised Standard Specifications, of the California
Department of Transportation, unless otherwise noted.

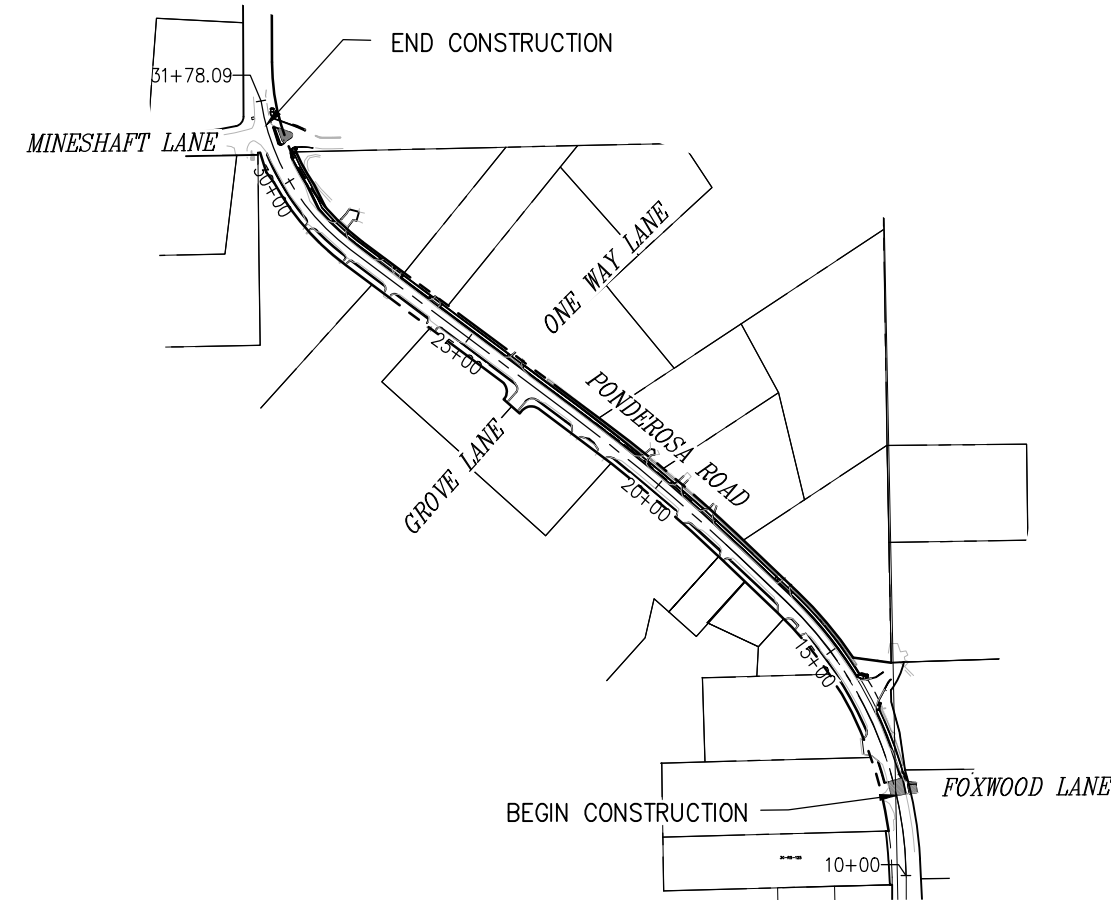


SITE PLAN

SCALE: 1"=200'




CONTRACTOR'S LICENSE CLASSIFICATION: Bidders shall be properly licensed to perform the Work pursuant to the State Contractor's License Act (Business and Professions Code section 7000 et seq.) and shall possess a CLASS A LICENSE or equivalent combination of Classes required by the categories and type of Work included in the Contract Documents and Plans. Failure of the successful Bidder to obtain proper and adequate licensing at the time bids are submitted shall constitute a failure to execute the Contract, and forfeiture as provided under that section.

REVISIONS		
MARK	DATE	BY

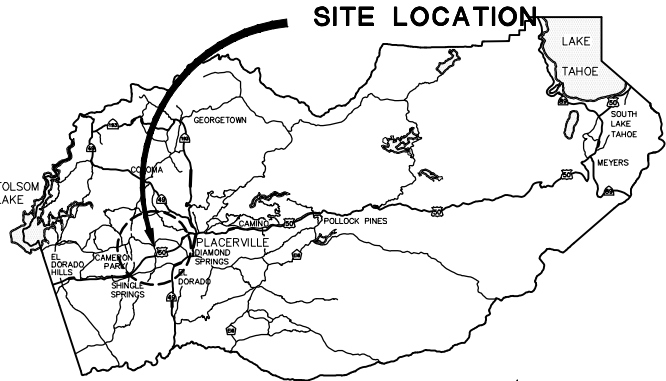

VICINITY MAP
COUNTY OF EL DORADO

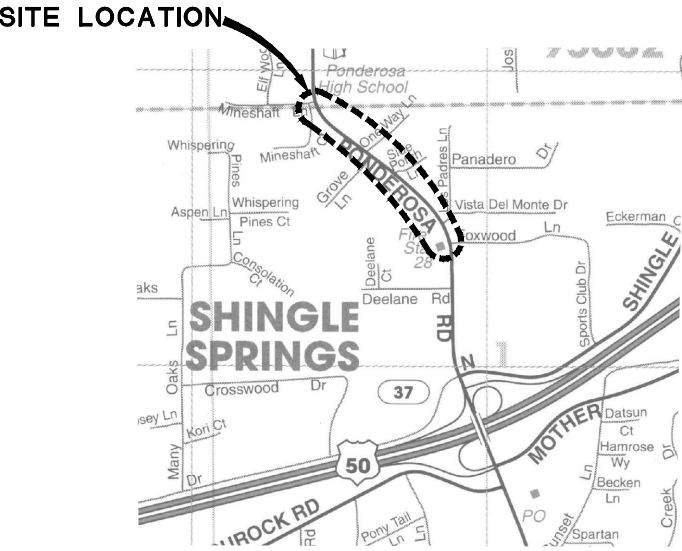

LOCATION MAP
NOT TO SCALE

FUNDING AGENCY

FEDERAL AID NUMBER IS CML 5925 (175)

SUBMITTED BY: JON BALZER P.E. DATE
CIVIL ENGINEER
STATE OF CALIFORNIA NO. C272291



BOARD OF SUPERVISORS		I	II	III	IV	V
GREG FERRO	GEORGE TURNBOO	BRIAN VEERKAMP	LORI PARLIN	BROOKE LAINE		

COUNTY OF EL DORADO
DEPARTMENT OF TRANSPORTATION
(530) 621-5900
2850 FAIRLANE CT
PLACERVILLE, CA 95667

ADOPTED AND APPROVED BY:	DATE
GEORGE TURNBOO CHAIR, EL DORADO COUNTY BOARD OF SUPERVISORS	
APPROVED BY:	DATE
RAFAEL MARTINEZ, DIRECTOR DEPARTMENT OF TRANSPORTATION	
MATTHEW D. SMELTZER P.E. NO. C56832 DEPUTY DIRECTOR, ENGINEERING	

CONTRACT NO. 9275	CIP NO. 36109009
PONDEROSA ROAD CLASS II BIKE PATH AND SIDEWALK	
TITLE SHEET	
SHEET 1	OF 46

 2 ORIGINAL SCALE IS IN INCHES
FOR REDUCED PLANS
Drawing name: Z:\Civil 3D Projects\97018 Ponderosa Class II Sidewalk\CADD Files\Sheets\CD-1.dwg Layout Tab: CD-1 Feb. 06, 2025 -- 8:35am Ddelich

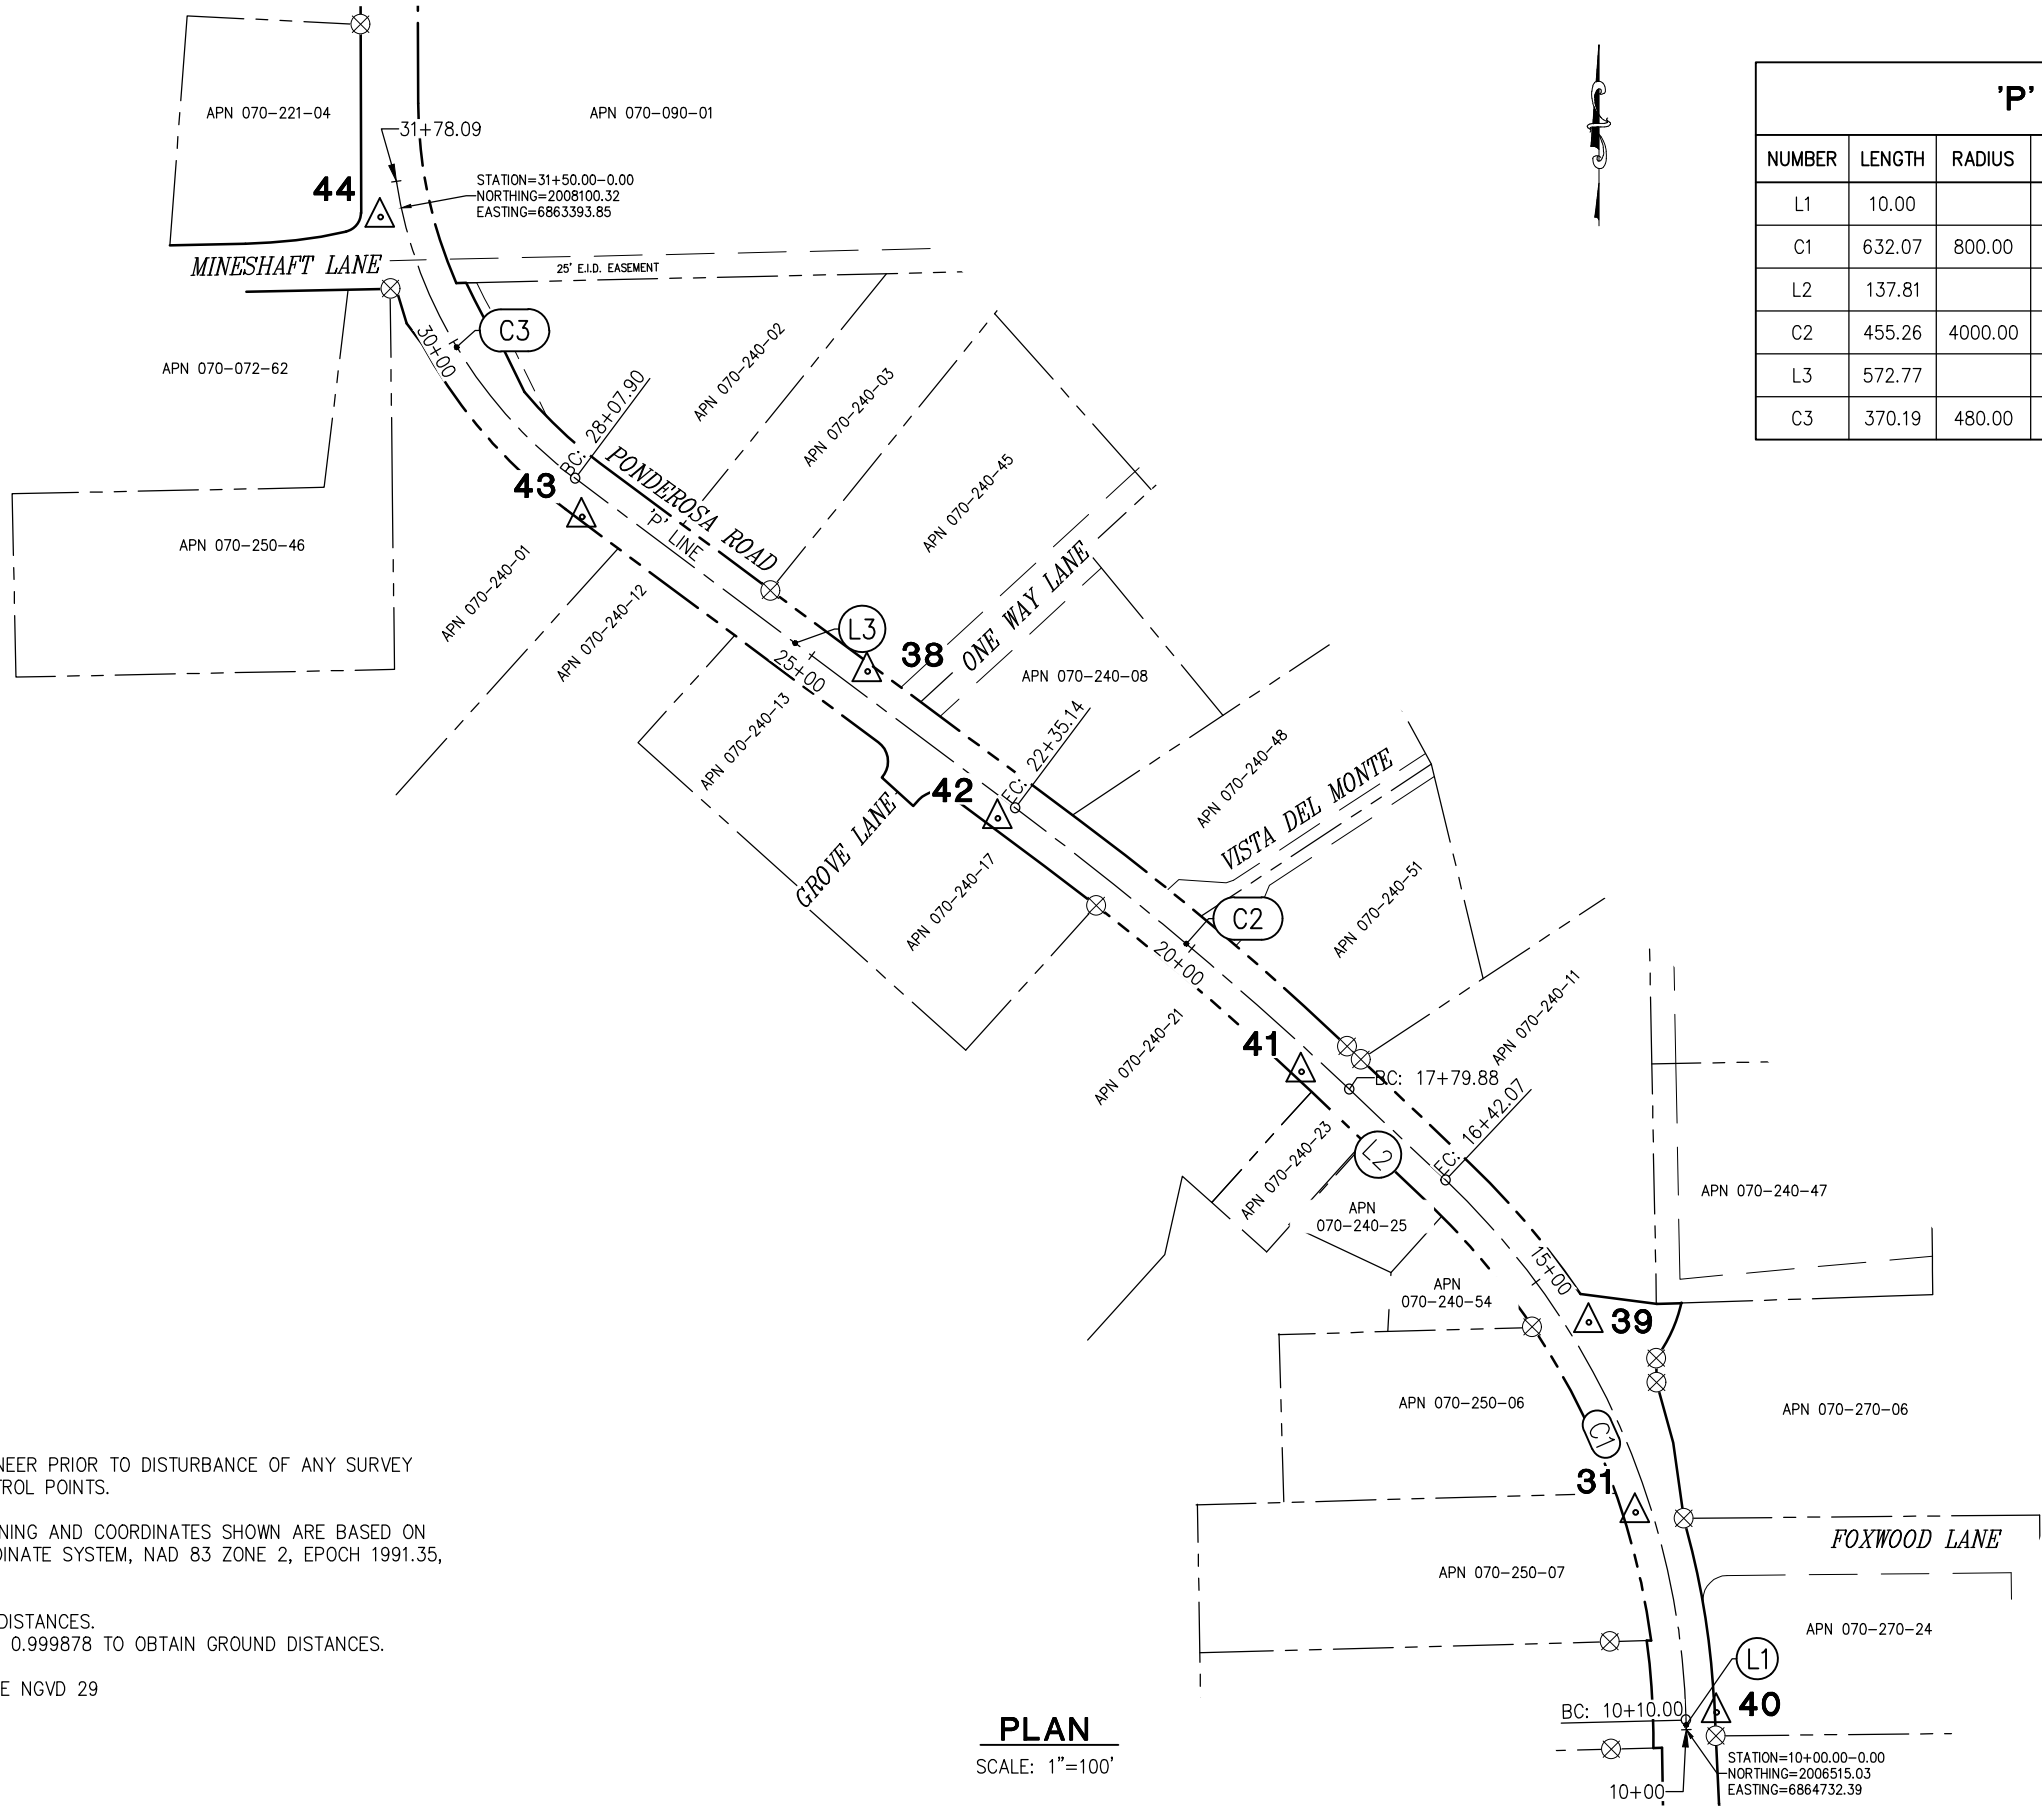

'P' ALIGNMENT				
NUMBER	LENGTH	RADIUS	LINE / CHORD DIRECTION & LENGTH	DELTA
L1	10.00		N 1° 22' 17" W	
C1	632.07	800.00	N 24° 00' 21" W - 615.76	45° 16' 08"
L2	137.81		N 46° 38' 25" W	
C2	455.26	4000.00	N 49° 54' 03" W - 455.01	6° 31' 16"
L3	572.77		N 53° 09' 41" W	
C3	370.19	480.00	N 31° 04' 03" W - 361.08	44° 11' 17"

CONTROL TABLE		
CONTROL NUMBER	ELEVATION	DESCRIPTION
31	1544.96	CP SPIKE
38	1515.98	CP SPIKE
39	1541.52	CP SPIKE
40	1548.86	CP SPIKE
41	1526.91	CP SPIKE
42	1516.47	CP SPIKE
43	1521.23	CP SPIKE
44	1521.30	CP SPIKE

LEGEND

△ (E) SURVEY CONTROL

⊗ (E) SURVEY MONUMENT

NOTES:

CONTRACTOR TO NOTIFY ENGINEER PRIOR TO DISTURBANCE OF ANY SURVEY MONUMENTS OR SURVEY CONTROL POINTS.

BEARINGS, DISTANCES, STATIONING AND COORDINATES SHOWN ARE BASED ON THE CALIFORNIA STATE COORDINATE SYSTEM, NAD 83 ZONE 2, EPOCH 1991.35, U.S. SURVEY FEET.

DISTANCES SHOWN ARE GRID DISTANCES.
DIVIDE DISTANCES SHOWN BY 0.999878 TO OBTAIN GROUND DISTANCES.

ELEVATIONS SHOWN REFERENCE NGVD 29

PLAN
SCALE: 1"=100'

REVISION			
NUMBER	DATE	DESCRIPTION	BY

PREPARED UNDER THE SUPERVISION OF :	
LICENSED LAND SURVEYOR	DATE:

DESIGNED: JCN	DRAWN: CAD
CHECKED: JCN	DATE: 12/10/24
ROAD NUMBER: 005	



COUNTY OF EL DORADO
DEPARTMENT OF TRANSPORTATION


PONDEROSA ROAD CLASS II
BIKE PATH AND SIDEWALK

25-0282 C 2 of 15


SHEET
CD-1
02 OF 46
W.O. No. 36109009

SURVEY CONTROL DIAGRAM
SCALE : AS NOTED


ORIGINAL SCALE: 1" = 10' INCHES
Drawing Name: Z:\Civil 3D Projects\97018 Ponderosa Class II Sidewalk\CADD Files\Sheets\X-Sheets.dwg Layout Tab: X-1 Feb 05/2025 - 5:40pm Duetlich
FOR REDUCED PLANS

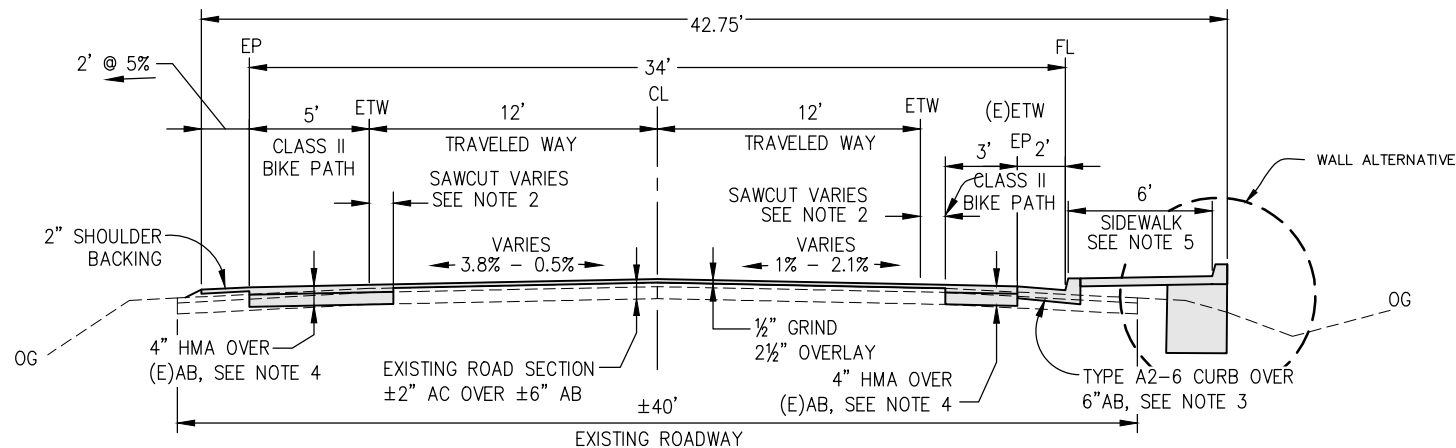

'P' 15+65.00 TO 'P' 16+47.00
'P' 20+75.15 TO 'P' 23+39.18

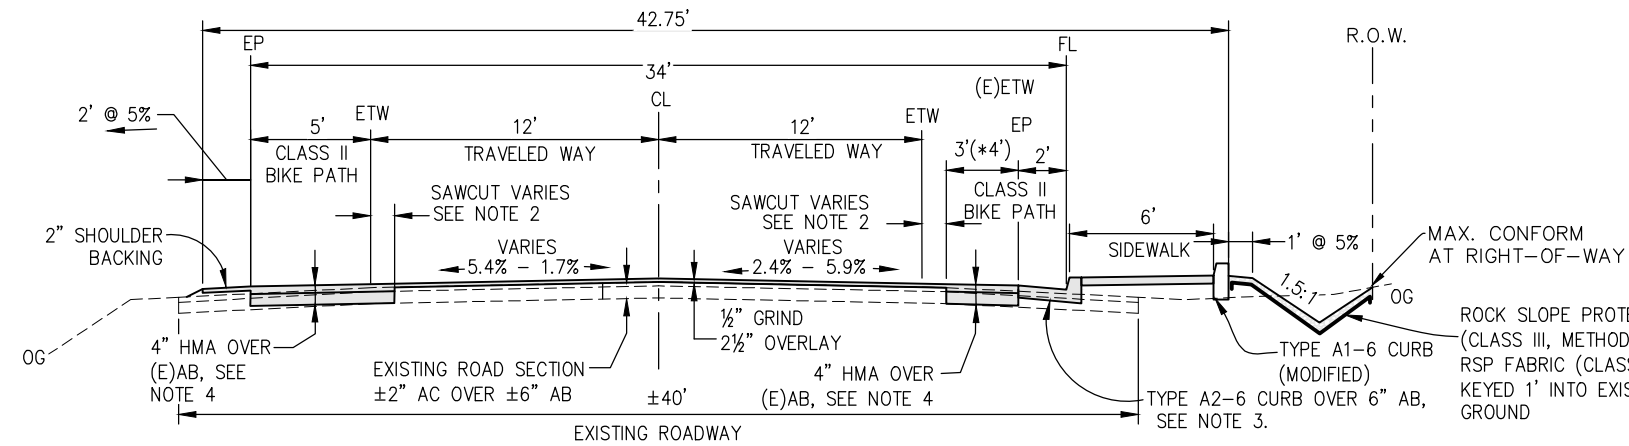

'P' 12+00.00 TO 'P' 15+65.00* (4' WIDE FULL PAVEMENT SHOULDER SECTION THROUGH STATIONING)
'P' 16+92.00 TO 'P' 18+71.82
'P' 18+94.70 TO 'P' 19+57.91

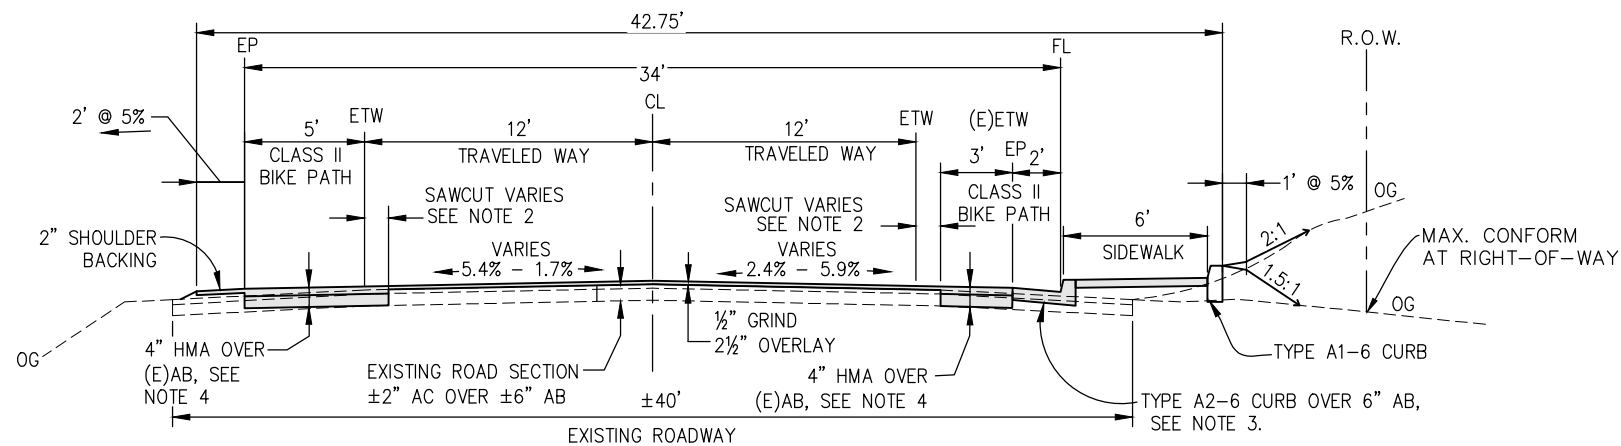


NOTES:

- SEE SHEET C-17 FOR TYPICAL SECTIONS AT RIGHT TURN LANE AT MINESHAFT DRIVE.
- SEE TYPICAL SECTIONS DETAILS FOR RESPECTIVE DRIVEWAYS ON C-SHEETS

'P' 18+71.91 TO 'P' 20+75.16
'P' 19+57.91 TO 'P' 20+75.16
'P' 23.39.19 TO 'P' 23.73.00
'P' 24.14.95 TO 'P' 28.74.92


CONSTRUCTION NOTES:

- RETAINING WALL, (2 LOCATIONS) FROM STA 15+65 TO 16+47, STA 20+75.15± TO 23+39.18± SEE R-SHEETS FOR WALL LAYOUTS.
- RT SIDE SAWCUT TO FOLLOW EXISTING ETW
LT SIDE SAWCUT VARIES 0'-2' FROM EXISTING ETW
- TYPE E CURB (MOD) AT VARIOUS DRIVEWAYS, SEE C-SHEETS.
- SCARIFY, RE-COMPACT, AND PLACE ADDITIONAL AB AS NEEDED TO MAKE GRADE
- 4" PCC OVER 4" AB

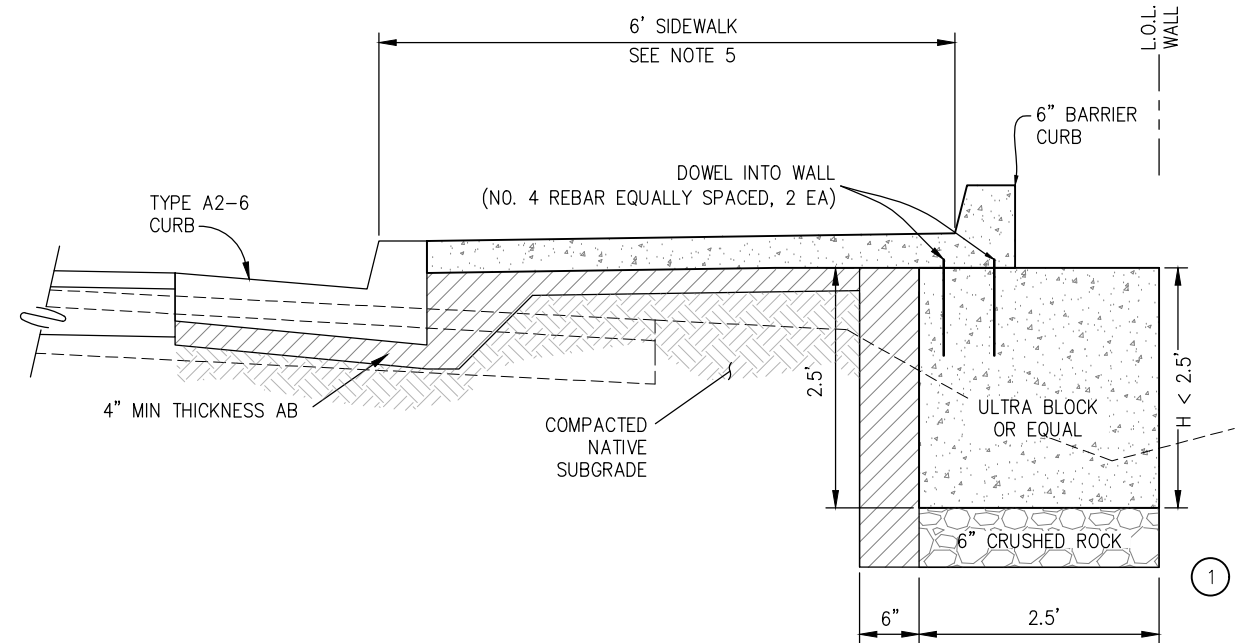


RETAINING WALL BLOCK WALL ALTERNATIVE

NTS
NOTE: FULL FLAT UNIT SHOWN,
ADDITIONAL FLAT CAP UNITS USED AS NECESSARY.

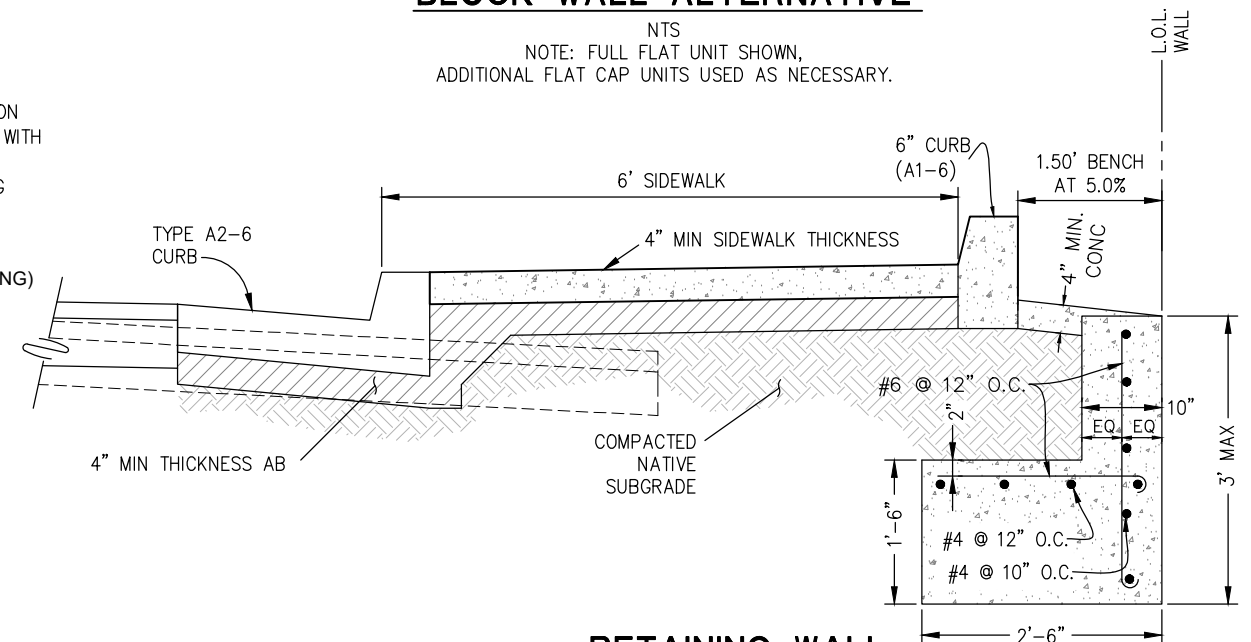


RETAINING WALL MODIFIED TYPE 5 WALL ALTERNATIVE

NTS

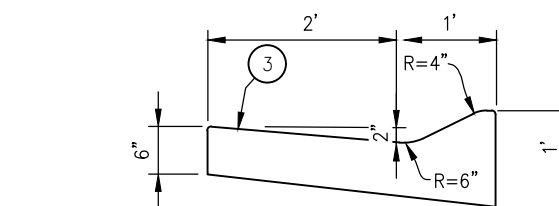

TYPE E CURB

NTS
NOTE: VARIOUS DRIVEWAYS ON RIGHT SIDE

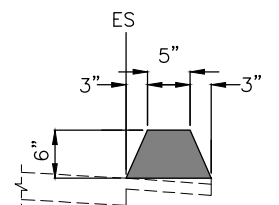

TYPE A ASPHALT DIKE

NTS
NOTE: VARIOUS DRIVEWAYS ON RIGHT SIDE

TYPICAL SECTIONS
SCALE : NONE

REVISION	NUMBER	DATE	DESCRIPTION	BY

PREPARED UNDER THE SUPERVISION OF :	DESIGNED: JB	DRAWN: CAD
	CHECKED: JB	DATE: 3/2/21
REGISTERED CIVIL ENGINEER	ROAD NUMBER: 005	
DATE:		



COUNTY OF EL DORADO
DEPARTMENT OF TRANSPORTATION

PONDEROSA ROAD CLASS II
BIKE PATH AND SIDEWALK

25-0282 C 3 of 15

SHEET
X-1
03 OF 46
W.O. No. 36109009

[illegible]

PREPARED UNDER THE SUPERVISION OF : _____

REGISTERED CIVIL ENGINEER _____

DATE: _____

DESIGNED:	DRAWN:	
JB	CAD	
CHECKED:	DATE:	
JB	3/3/21	
ROAD NUMBER:		
005		



COUNTY OF EL DORADO
DEPARTMENT OF TRANSPORTATION

**PONDEROSA ROAD BICYCLE AND
PEDESTRIAN IMPROVEMENTS**


25-0282 C 4 of 15

L-1

SHEET


04 OF 46

36109009

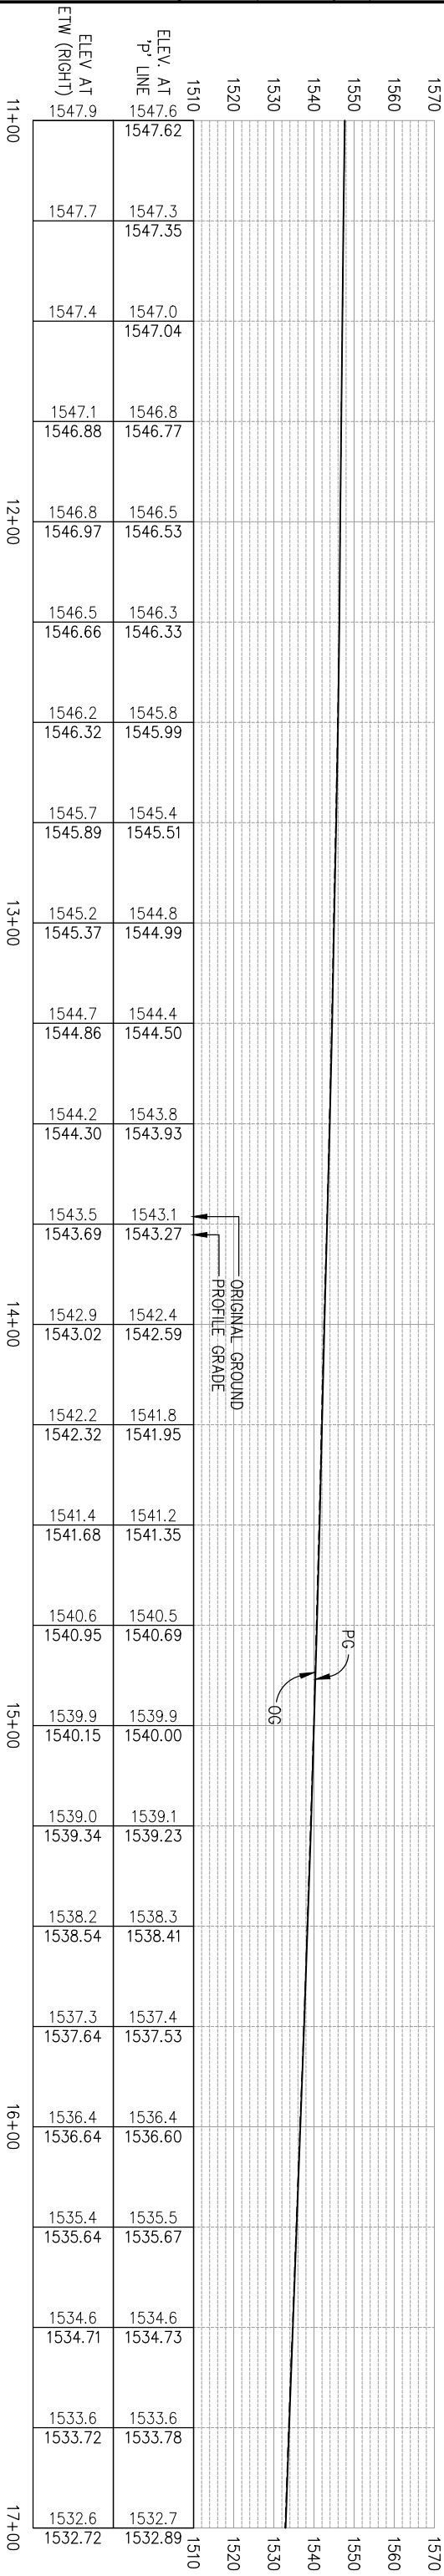


PONDEROSA RD - PLAN

SCALE: 1"=20'

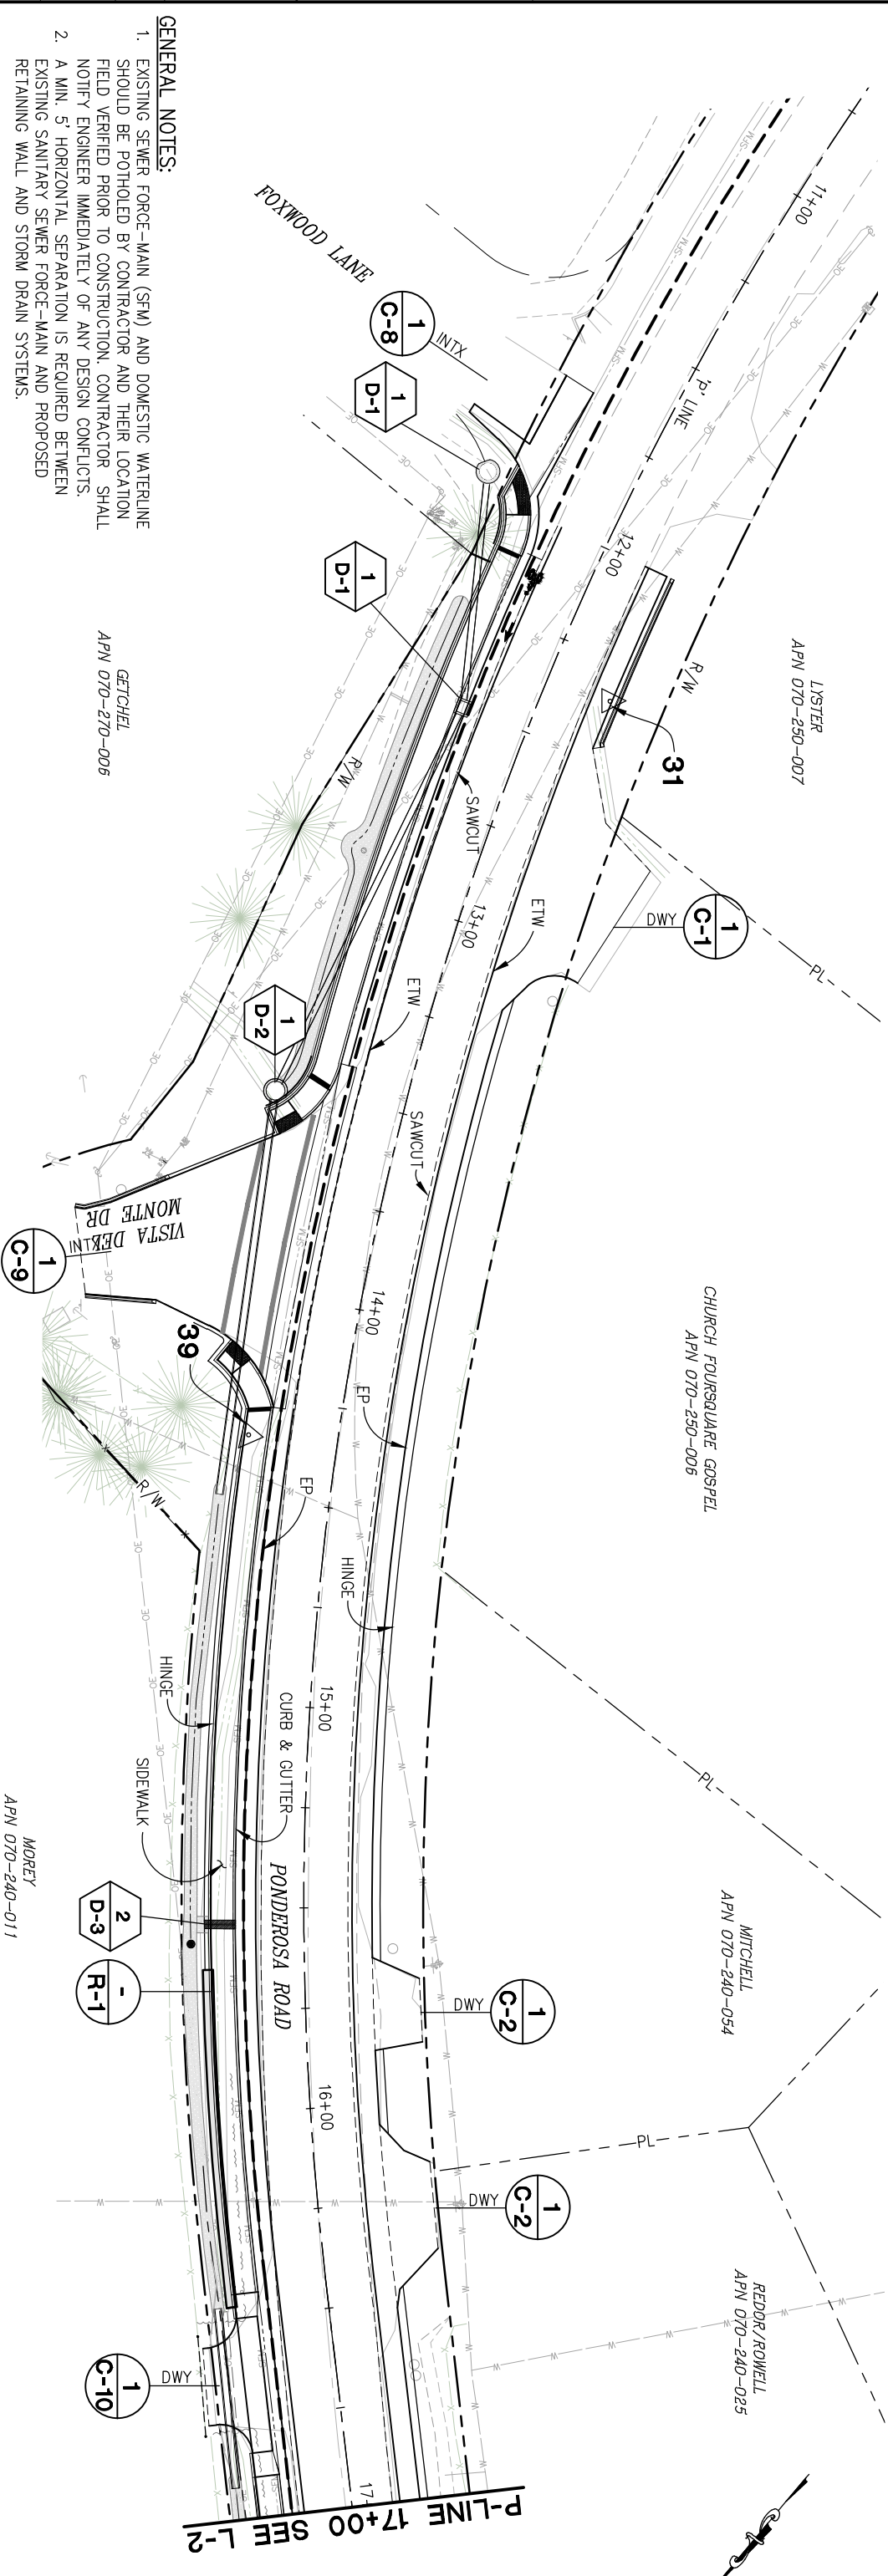



PREPARED UNDER THE SUPERVISION OF : _____ REGISTERED CIVIL ENGINEER _____ DATE: _____	DESIGNED: JB	DRAWN: CAD
	CHECKED: JB	DATE: 3/3/21
	ROAD NUMBER: 005	

 


25-0282 C 5 of 15

FOR REDUCED PLANS
ORIGINAL SCALE IS IN INCHES
Drawing name: Z:\Civil_3D Projects\97018 Ponderosa Class II Sidewalk\CADD Files\Sheets\L-Sheets2.DWG Layout Tab: L-3 Feb 05,2025 -- 5:41pm D.Jelich


GENERAL NOTES:

1. EXISTING SEWER FORCE-MAIN (SFM) AND DOMESTIC WATERLINE SHOULD BE POTHOLED BY CONTRACTOR AND THEIR LOCATION FIELD VERIFIED PRIOR TO CONSTRUCTION. CONTRACTOR SHALL NOTIFY ENGINEER IMMEDIATELY OF ANY DESIGN CONFLICTS.
2. A MIN. 5' HORIZONTAL SEPARATION IS REQUIRED BETWEEN EXISTING SANITARY SEWER FORCE-MAIN AND PROPOSED RETAINING WALL AND STORM DRAIN SYSTEMS.

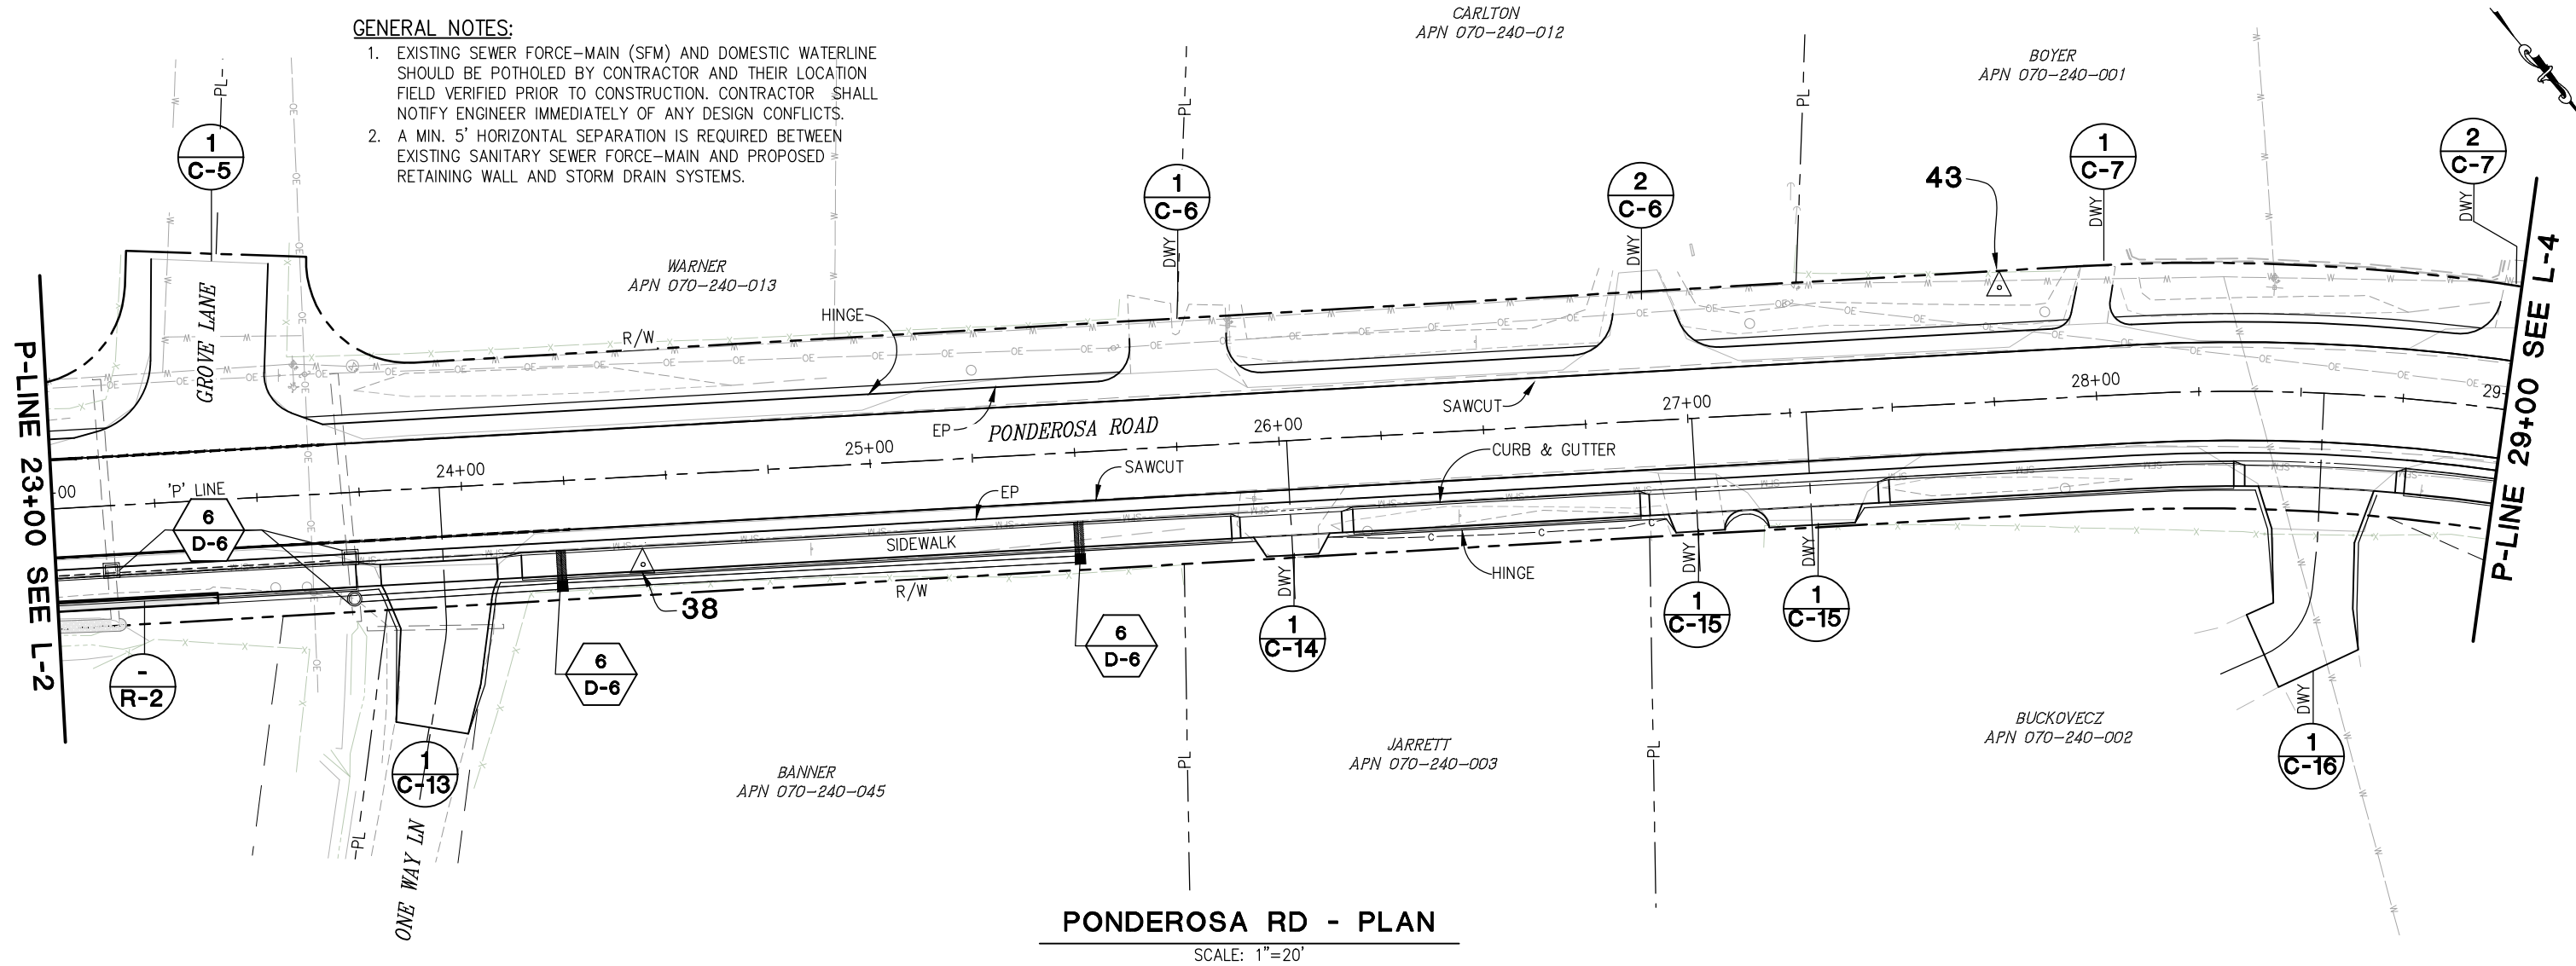

PONDEROSA RD - PLAN

SCALE: 1"=20'

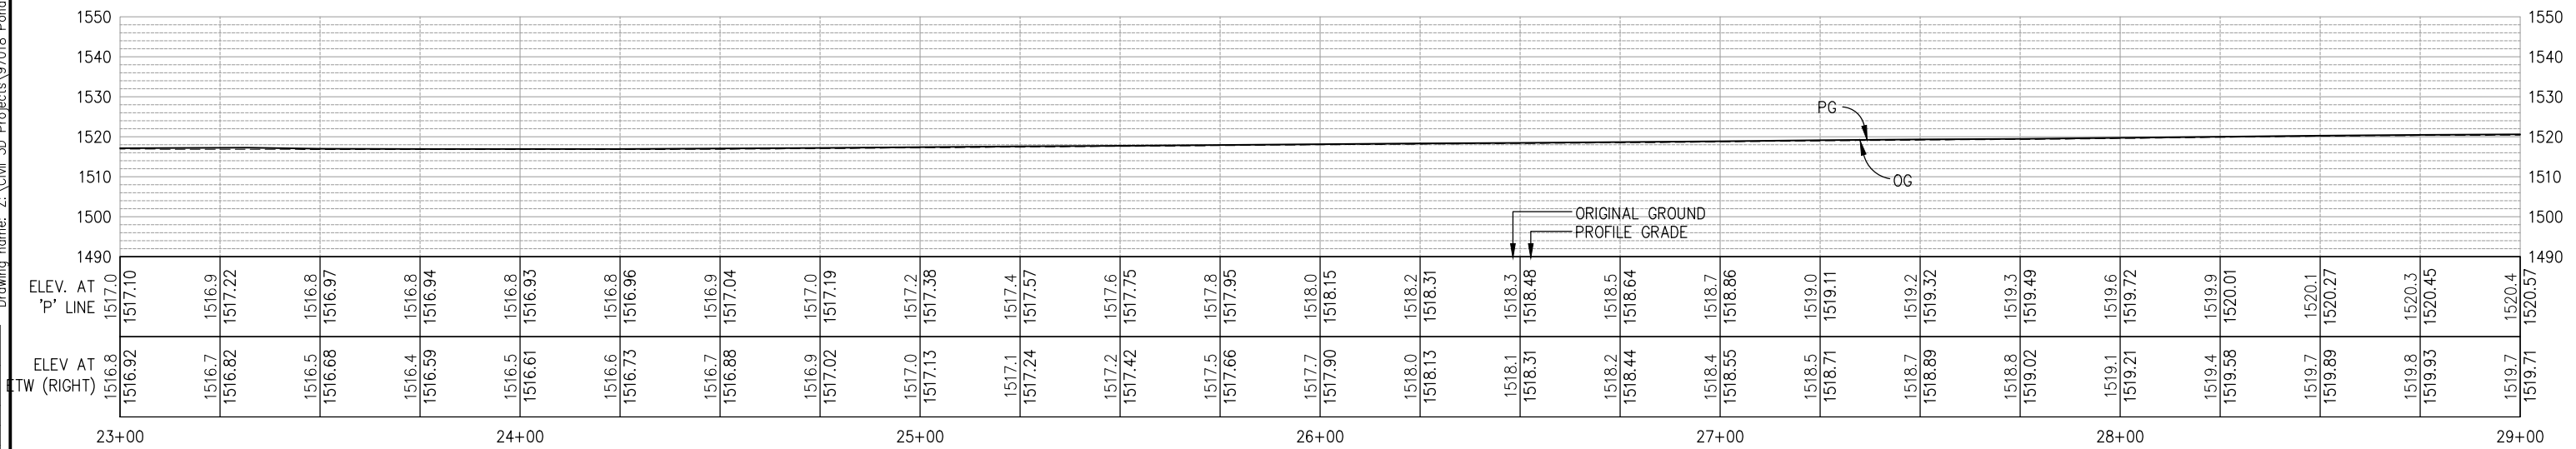

PONDEROSA RD - PROFILE

SCALE: 1"=20' H,V

REVISION	NUMBER	DATE	DESCRIPTION	BY

PREPARED UNDER THE SUPERVISION OF :

REGISTERED CIVIL ENGINEER

DATE:

DESIGNED: JB

CHECKED: JB

DATE: 3/3/21

ROAD NUMBER: 005




COUNTY OF EL DORADO
DEPARTMENT OF TRANSPORTATION

PONDEROSA ROAD BICYCLE AND
PEDESTRIAN IMPROVEMENTS


25-0282 C 6 of 15

LAYOUT
SCALE : AS SHOWN

SHEET
L-3
06 OF 46
W.O. No. 36109009

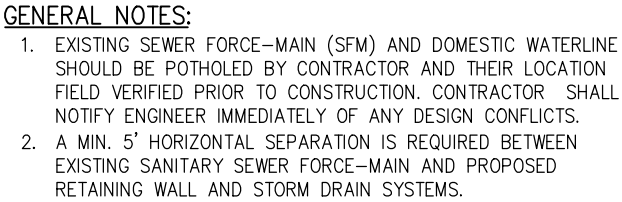

SCALE: 1"=20'

 

PREPARED UNDER THE SUPERVISION OF : _____

REGISTERED CIVIL ENGINEER _____

DATE: _____

The seal of El Dorado County, California, is a circular emblem. It features a central figure, likely a Native American, holding a bow and arrow. The figure is surrounded by a wreath. The words "EL DORADO COUNTY" are inscribed in a circle around the top, and "CALIFORNIA" is at the bottom. There are stars on either side of the word "CALIFORNIA".

PONDEROSA ROAD BICYCLE AND PEDESTRIAN IMPROVEMENTS

25-0282 C 7 of 15

 
LAYOUT
AS SHOWN

SHEET
L-4

07 OF 46


W.O. No.
36109009

FOR REDUCED PLANS
ORIGINAL SCALE: 1/8"=1' H, V
Drawing name: Z:\Civil 3D Projects\97018 Ponderosa Class II Sidewalk\CADD Files\Sheets\P-SHEET.dwg
Layout Tab: MS-1 & MS-2
Feb 05, 2025
5:41pm
D.Jelich




REVISION

NUMBER	DATE	DESCRIPTION	BY

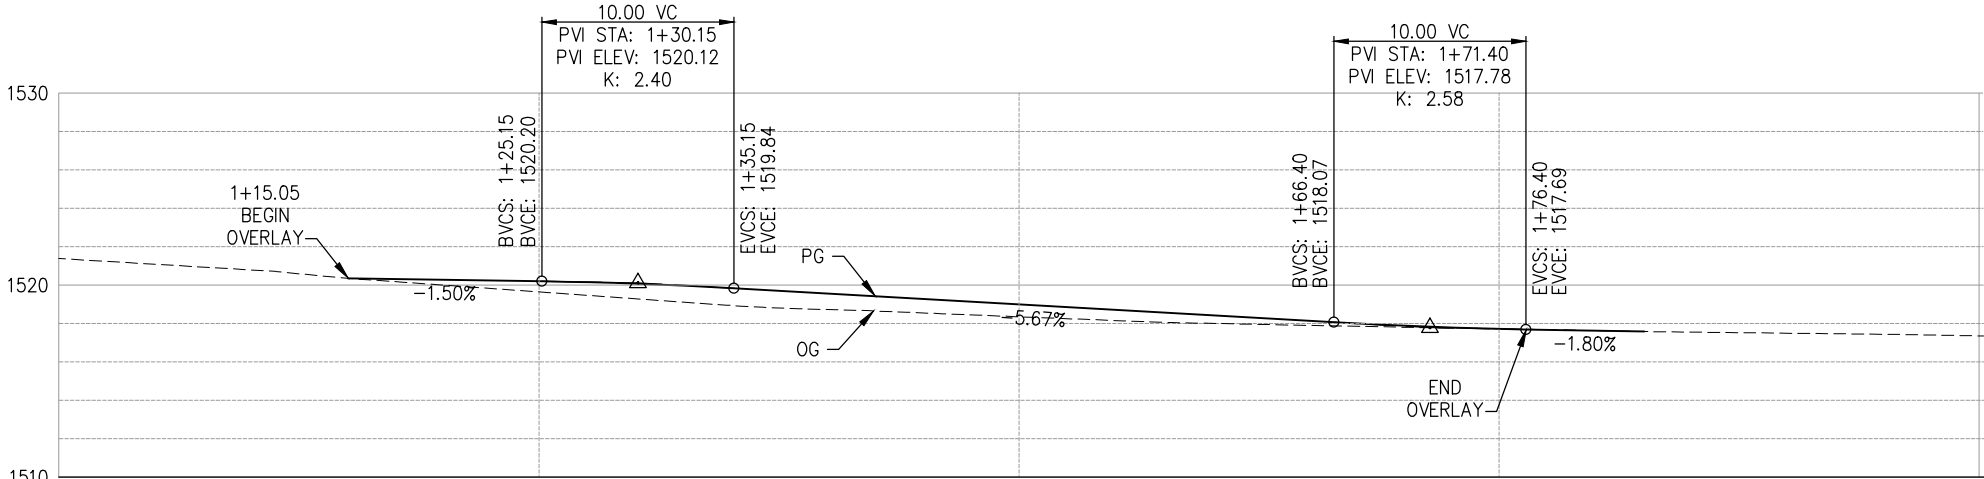

PROFILE - 'MS-1'

SCALE: 1"=5' H,V

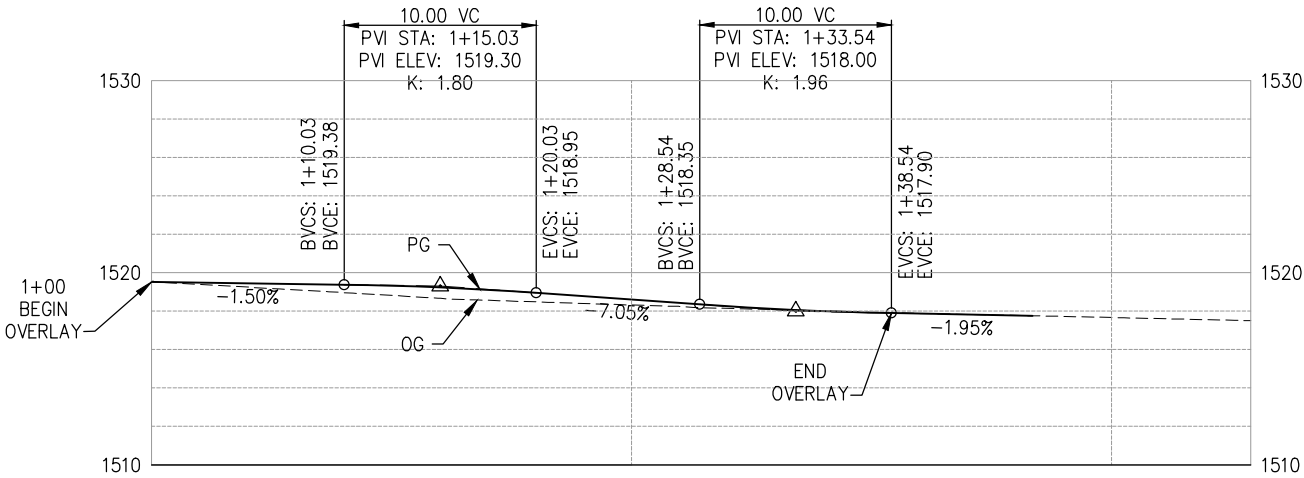

PROFILE - 'MS-2'

SCALE: 1"=5' H,V

MS-1 & MS-2 PROFILE
PONDEROSA ROAD / MINESHFT LANE
SCALE : AS NOTED



PREPARED UNDER THE SUPERVISION OF : REGISTERED CIVIL ENGINEER DATE: _____	DESIGNED: JB	DRAWN: CAD
	CHECKED: JB	DATE: 3/2/21
	ROAD NUMBER: 005	
		

COUNTY OF EL DORADO
DEPARTMENT OF TRANSPORTATION

PONDEROSA RD CLASS II
BIKE PATH AND SIDEWALK
25-0282 C 8 of 15

SHEET
P-1
08 OF 46
W.O. No. 97018

ORIGINAL SCALE IS IN INCHES
Drawing name: Z:\Civil 3D Projects\97018 Ponderosa Class II Sidewalk\CADD Files\Sheets\C-SHEETS.dwg Layout Tab: C-1 Feb 05/2025 - 5:41pm Ddelich
FOR REDUCED PLANS

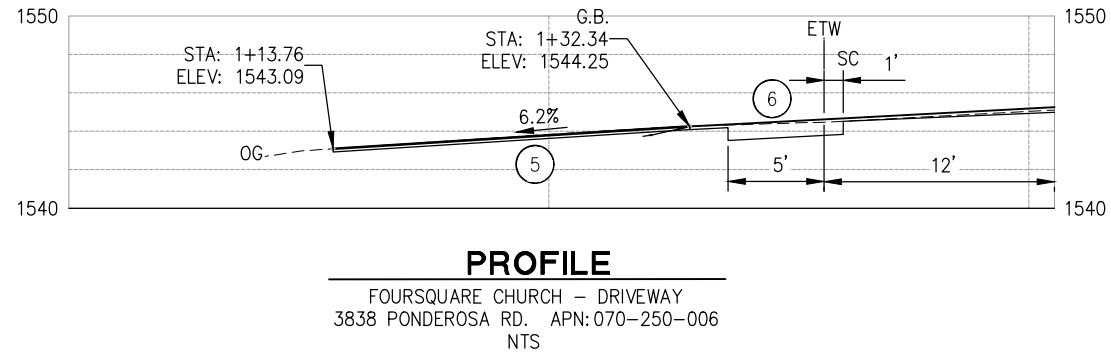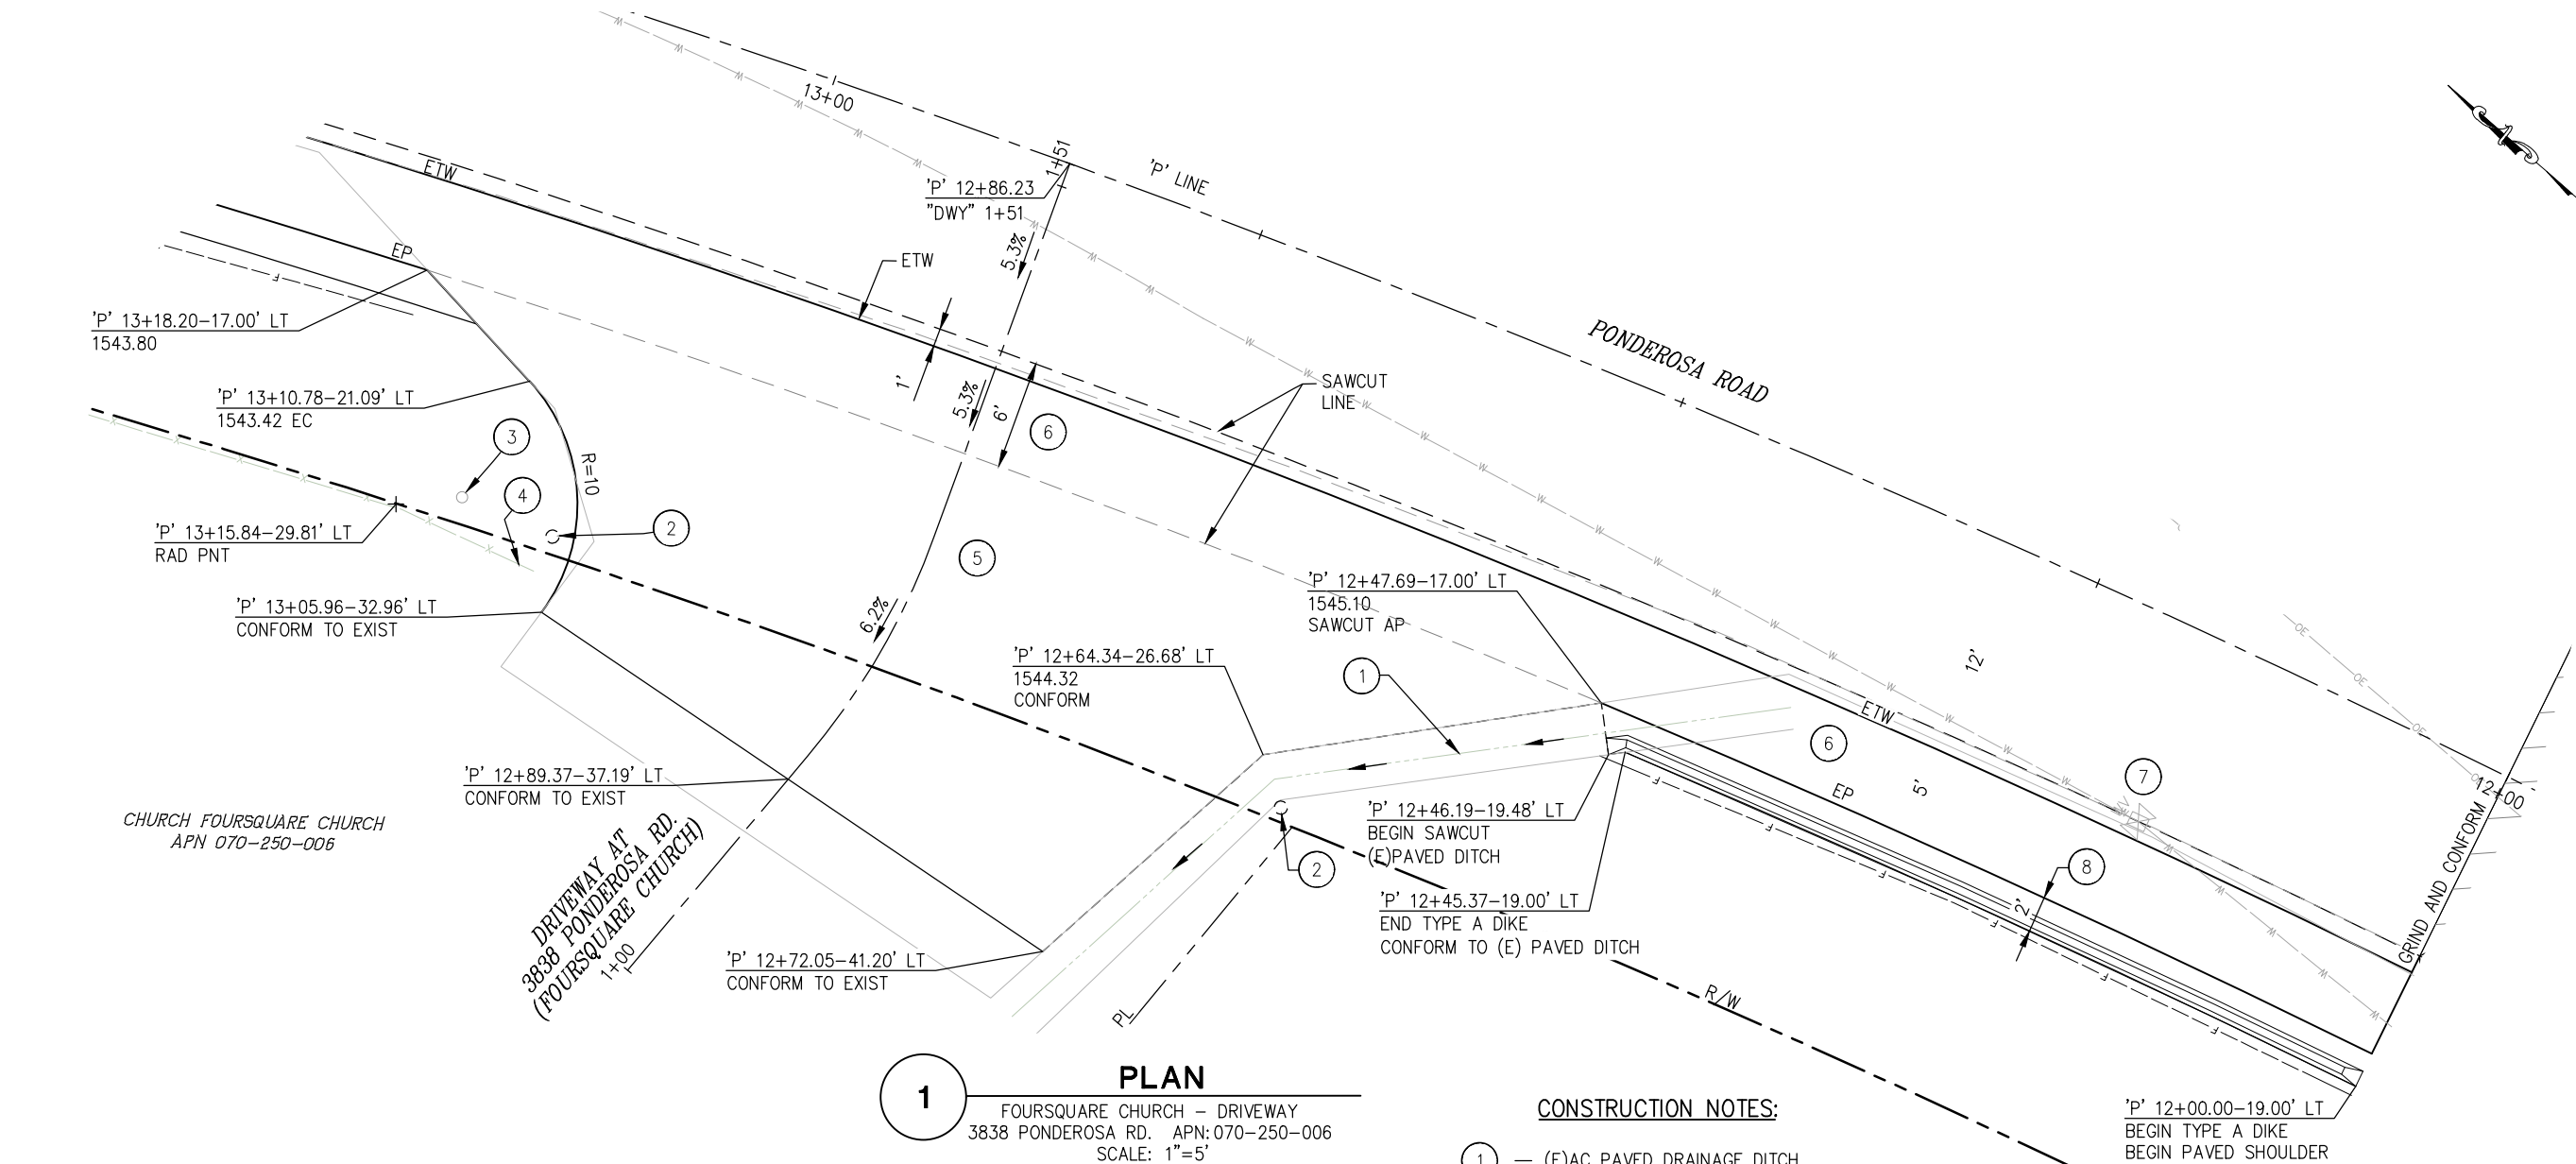

- CONSTRUCTION NOTES:**
- 1 - (E)AC PAVED DRAINAGE DITCH, MAINTAIN EXISTING FLOWLINE
 - 2 - (E)ELECTRIC LIGHT, PROTECT IN PLACE (EACH SIDE OF DWY)
 - 3 - (E)MAILBOX, PROTECT IN PLACE
 - 4 - (E)WOOD SPLITRAIL FENCE, PROTECT IN PLACE
 - 5 - 2" HMA, GRIND AND OVERLAY
 - 6 - 4" HMA, OVER (E) AB
 - 7 - (E)WATER VALVE, PROTECT IN PLACE AND ADJUST TO GRADE
 - 8 - 2' WIDE PAVED SHOULDER w/ TYPE A DIKE, 2" HMA OVER COMPACTED NATIVE

- NOTES:**
- 1. STATION OFFSET CALLOUTS PER 'P' ALIGNMENT.
 - 2. UNLESS NOTED, CUT/FILL SLOPES TO BE 2:1.

**DRIVEWAY
CONSTRUCTION DETAILS
SCALE : AS NOTED**

REVISION	NUMBER	DATE	DESCRIPTION	BY

PREPARED UNDER THE SUPERVISION OF :	DESIGNED: JB	DRAWN: CAD
	CHECKED: JB	DATE: 1/7/25
REGISTERED CIVIL ENGINEER	ROAD NUMBER: 005	
DATE:		




**COUNTY OF EL DORADO
DEPARTMENT OF TRANSPORTATION**

**PONDEROSA ROAD BICYCLE AND
PEDESTRIAN IMPROVEMENTS**

25-0282 C 9 of 15

SHEET	C-1
09 OF 46	
W.O. No.	36109009

 

- ① — (E)MAILBOX, PROTECT IN PLACE
- ② — 2" HMA, GRIND AND OVERLAY
- ③ — 4" HMA, OVER EXISTING AB

REDOR/ROWELL
APN 070-240-025
3810 PONDEROSA RD.

MITCHELL
APN 070-240-054
3820 PONDEROSA RD.

SAWCUT
LINE

'P' 15+84.68-28.85' L
CONFORM TO EXISTING

'P' 15+68.26-28.60' LT
CONFORM TO EXISTING

PONDEROSA ROAD

— SAWCUT
LINE

NOTES:

1. STATION OFFSET CALLOUTS PER 'P' ALIGNMENT.
2. UNLESS NOTED, CUT/FILL SLOPES TO BE 2:1.

**DRIVEWAY
CONSTRUCTION DETAILS
SCALE : AS NOTED**

[illegible]

PREPARED UNDER THE SUPERVISION OF :

REGISTERED CIVIL ENGINEER

DATE: _____

DESIGNED:	JB
-----------	----

CHECKED:
JB

ROAD NUMBER:

DRAWN:	CAD
--------	-----

DATE:	1/7/25
-------	--------

2:



COUNTY OF EL DORADO
DEPARTMENT OF TRANSPORTATION

PONDEROSA ROAD BICYCLE AND PEDESTRIAN IMPROVEMENTS

25-0282 C 10 of 15

SHEET
C-2


10 OF 46

No. **6109009**

ORIGINAL SCALE: 1"=5' IN INCHES
Drawing name: Z:\Civil 3D Projects\97018 Ponderosa Class II Sidewalk\CADD Files\Sheets\C-SHEETS.dwg Layout Tab: C-3 Feb 05,2025 -- 5:42pm Dujich

FOR REDUCED PLANS


0 1 2

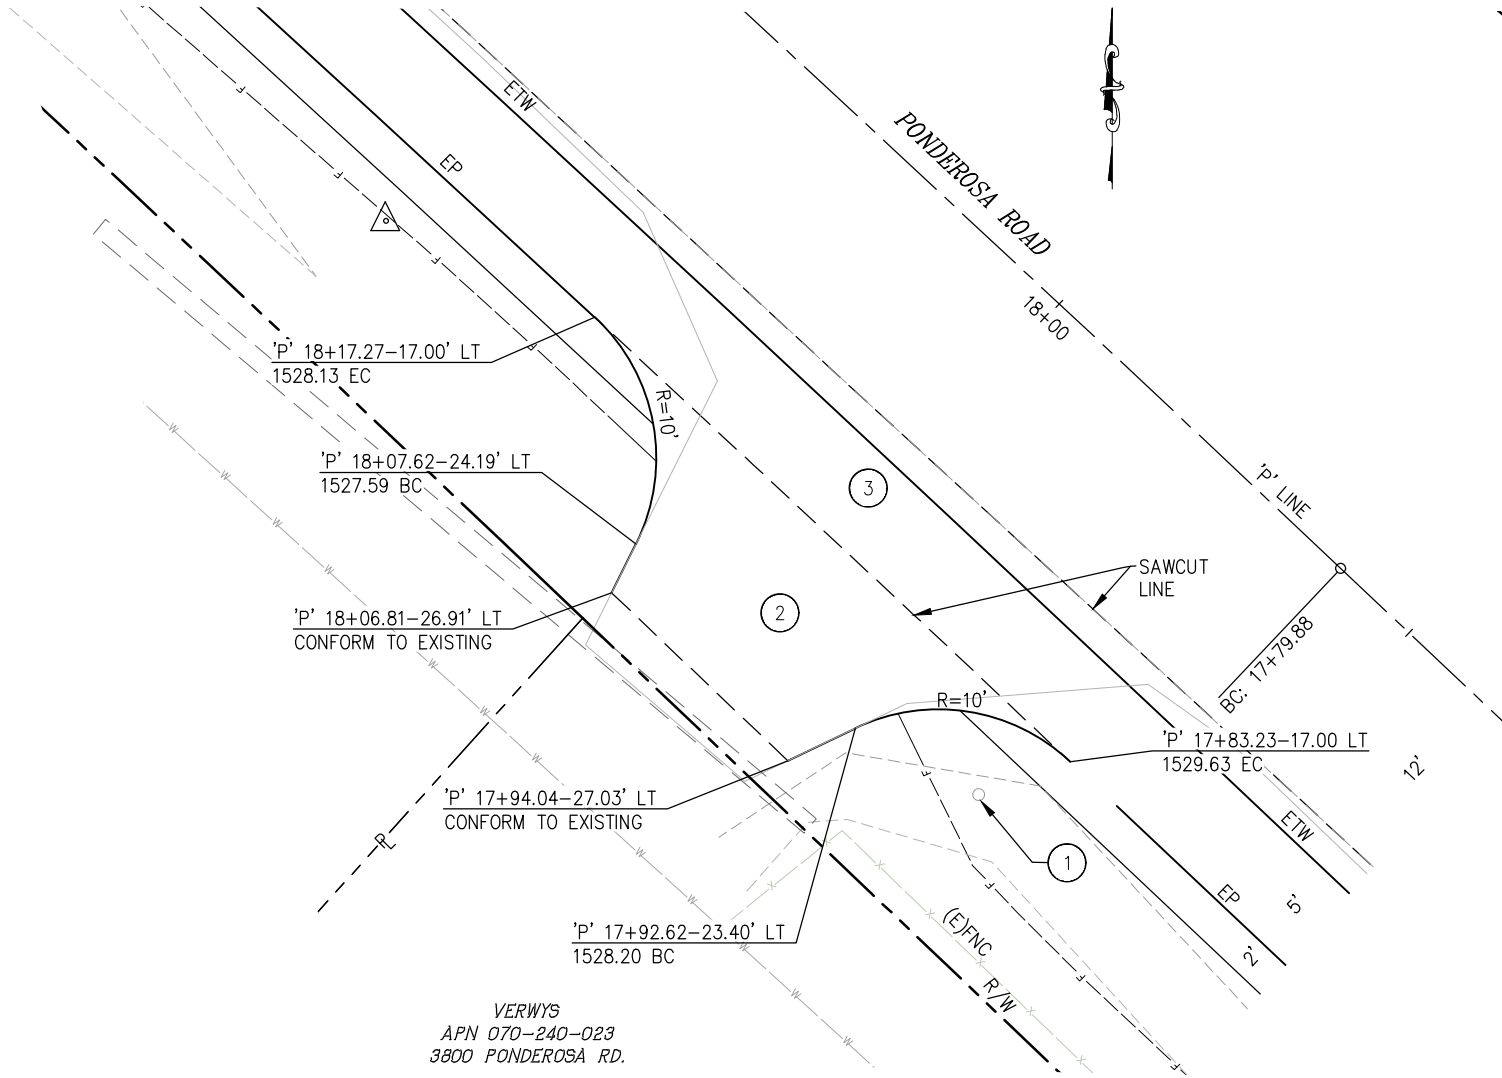

1 **PLAN**
DRIVEWAY AT
3800 PONDEROSA RD.
APN: 070-240-023
SCALE: 1"=5'

CONSTRUCTION NOTES:

- 1 — (E)MAILBOX, PROTECT IN PLACE
- 2 — 2" HMA, GRIND AND OVERLAY
- 3 — 4" HMA, OVER EXISTING AB

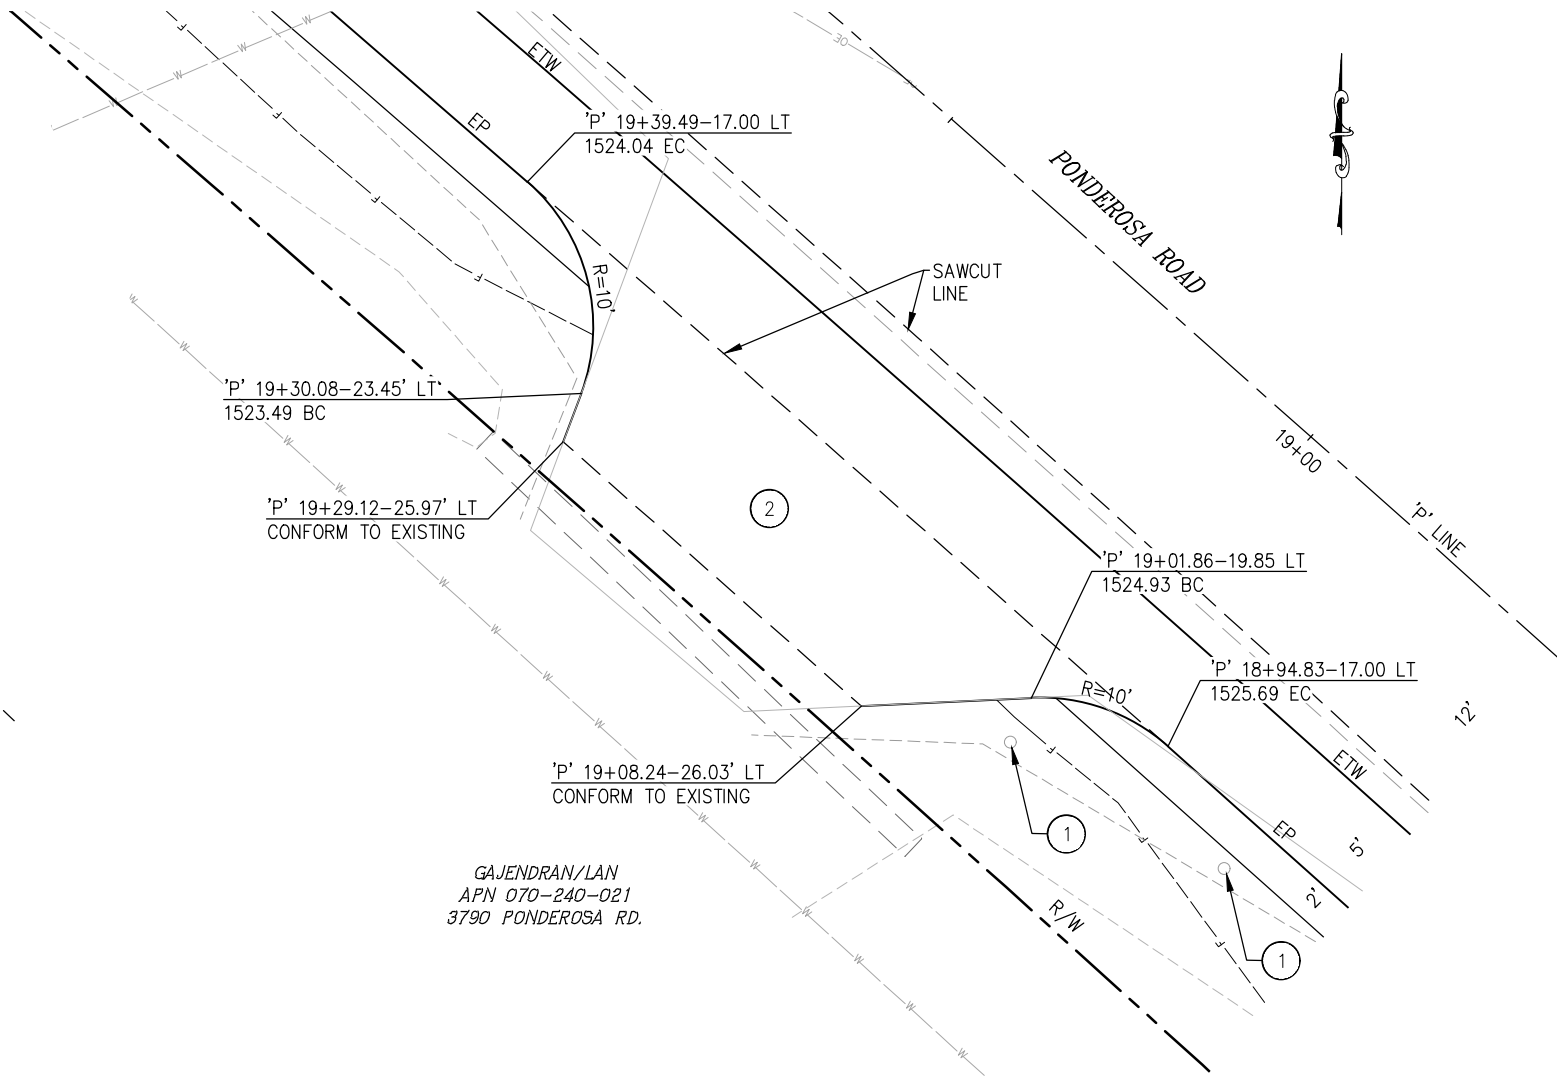

2 **PLAN**
DRIVEWAY AT
3790 PONDEROSA RD.
APN: 070-240-021
SCALE: 1"=5'

NOTES:

- 1. STATION OFFSET CALLOUTS PER 'P' ALIGNMENT.
- 2. UNLESS NOTED, CUT/FILL SLOPES TO BE 2:1.

**DRIVEWAY
CONSTRUCTION DETAILS
SCALE : AS NOTED**

REVISION	NUMBER	DATE	DESCRIPTION	BY

PREPARED UNDER THE SUPERVISION OF :	DESIGNED: JB	DRAWN: CAD
	CHECKED: JB	DATE: 1/27/25
REGISTERED CIVIL ENGINEER	ROAD NUMBER: 005	
DATE:		




COUNTY OF EL DORADO
DEPARTMENT OF TRANSPORTATION

PONDEROSA ROAD BICYCLE AND
PEDESTRIAN IMPROVEMENTS

25-0282 C 11 of 15

SHEET	C-3
11 OF 46	
W.D. No.	36109009

ORIGINAL SCALE: 1/8" = 1' IN INCHES
Drawing name: Z:\Civil 3D Projects\97018 Ponderosa Class II Sidewalk\CADD Files\Sheets\C-SHEETS.dwg Layout Tab: C-4 Feb 05,2025 -- 5:42pm Dujich
FOR REDUCED PLANS

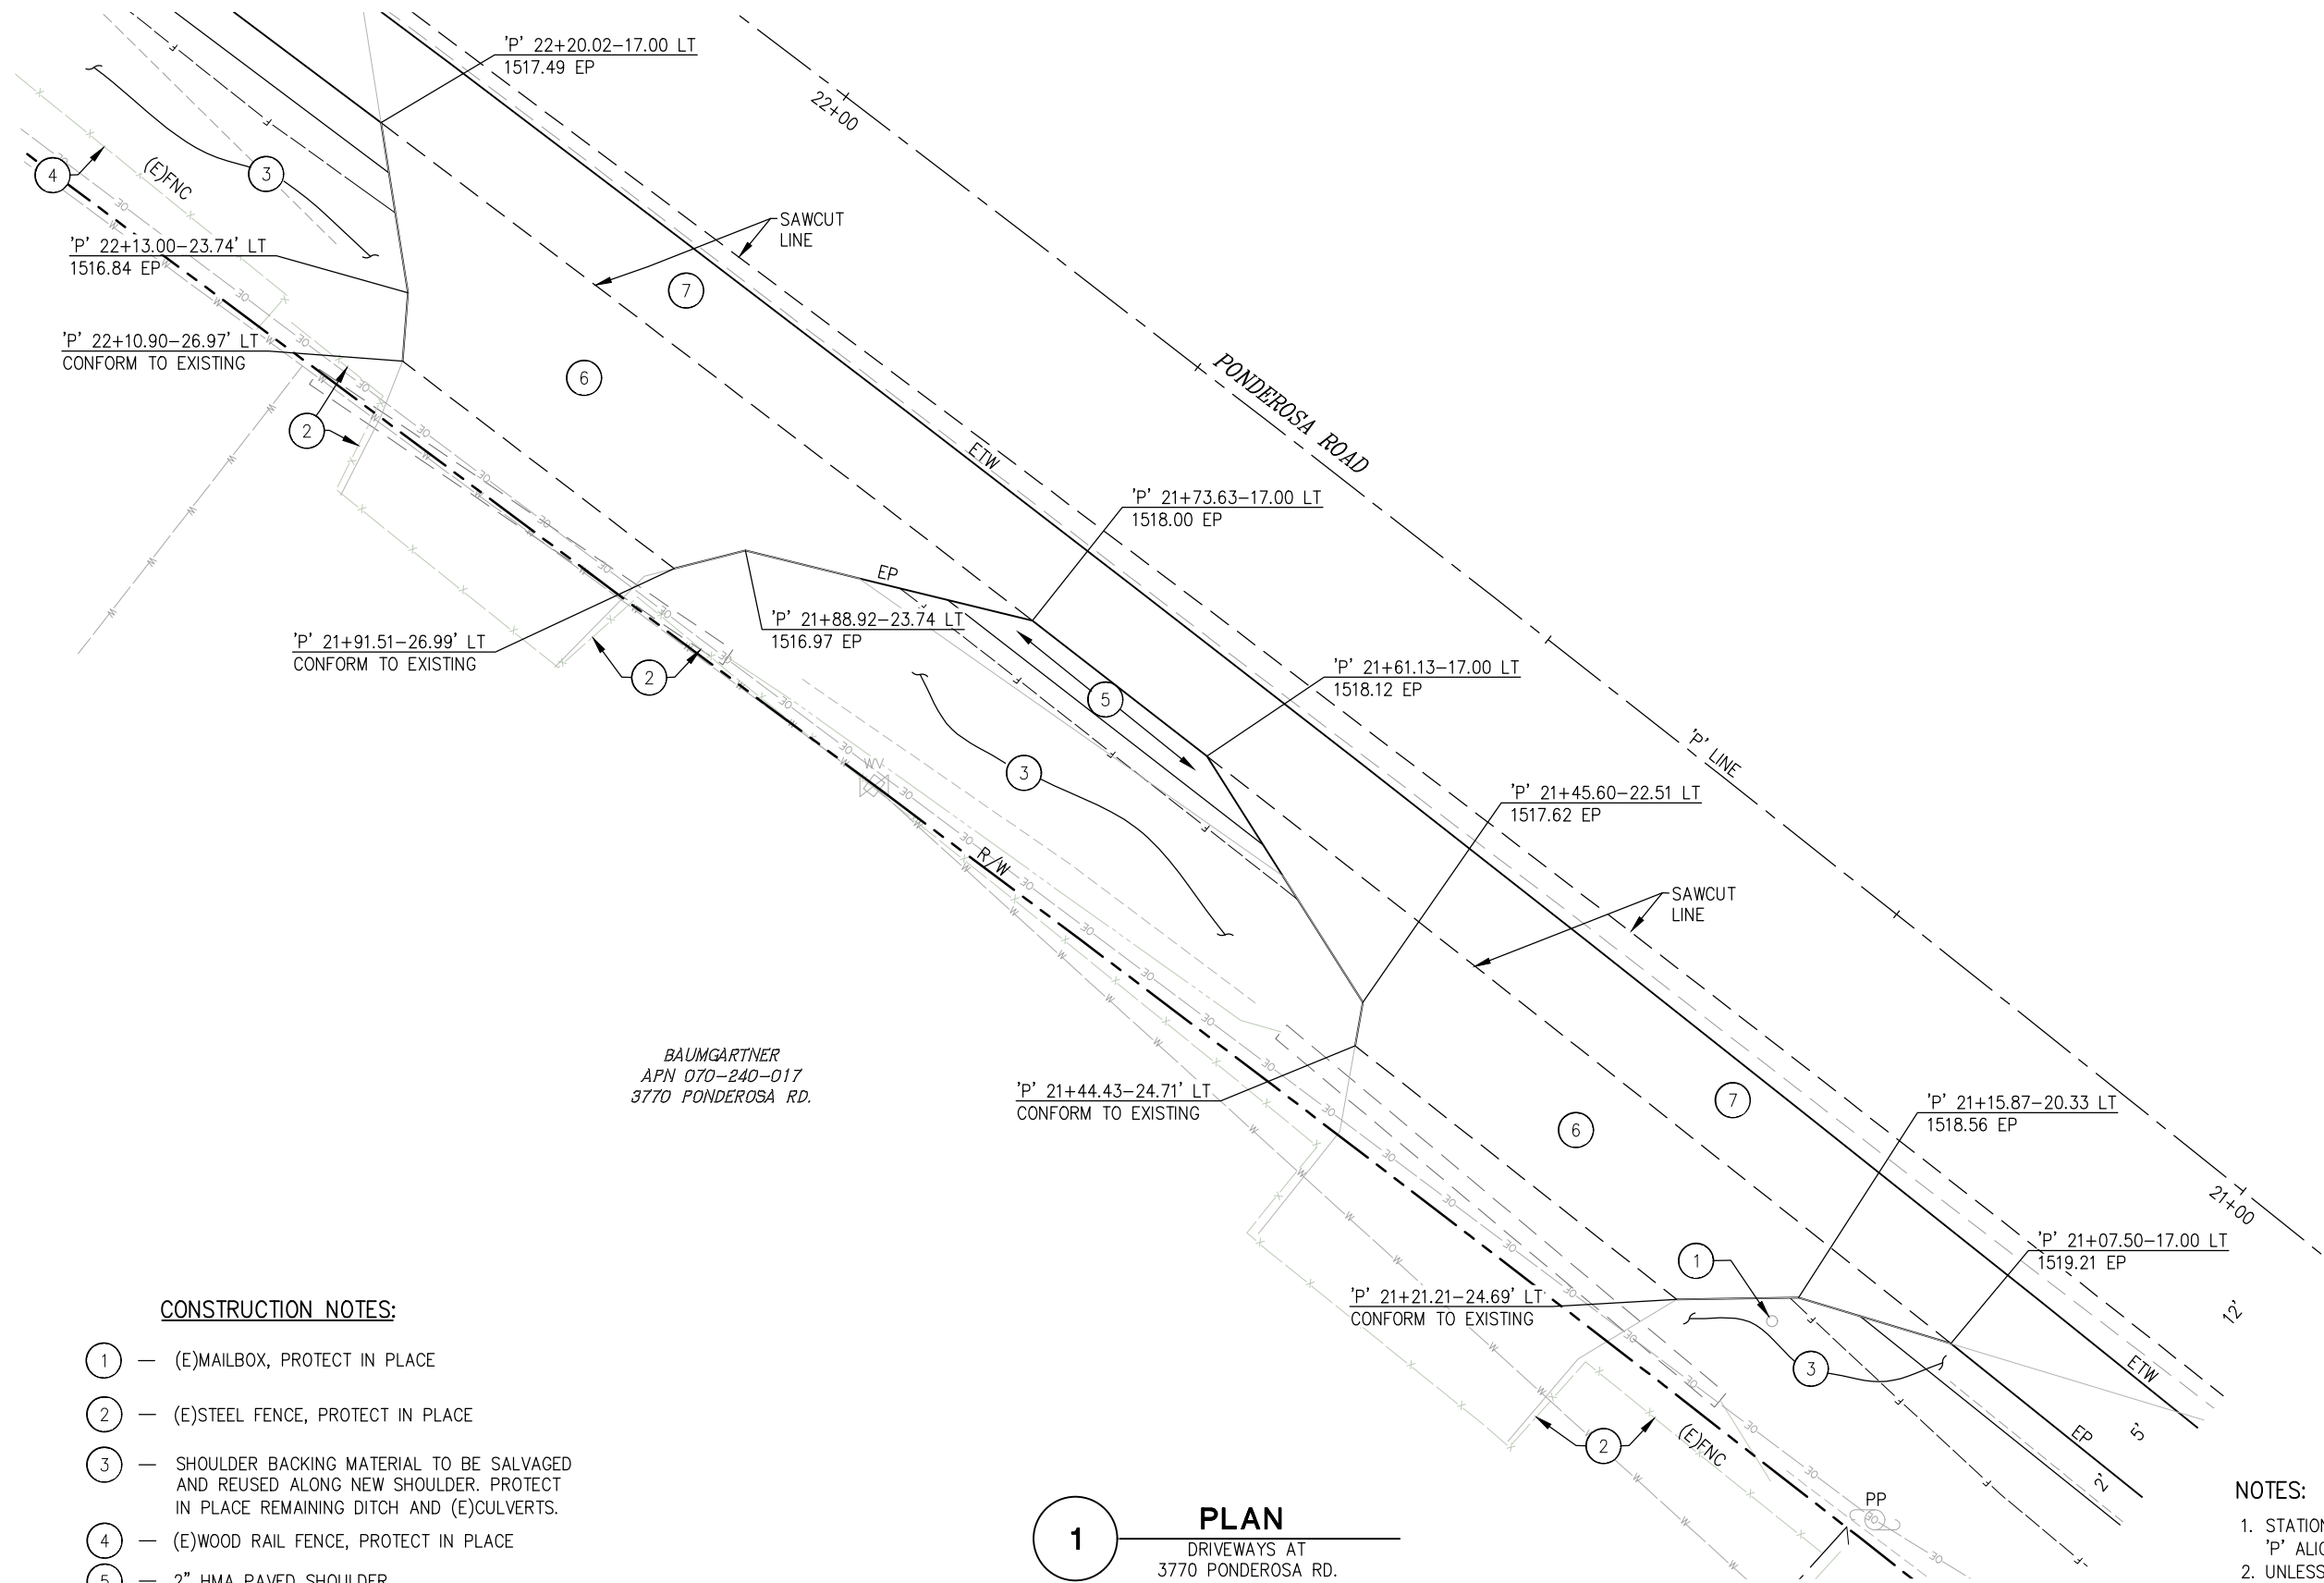

CONSTRUCTION NOTES:

- ① — (E)MAILBOX, PROTECT IN PLACE
- ② — (E)STEEL FENCE, PROTECT IN PLACE
- ③ — SHOULDER BACKING MATERIAL TO BE SALVAGED AND REUSED ALONG NEW SHOULDER. PROTECT IN PLACE REMAINING DITCH AND (E)CULVERTS.
- ④ — (E)WOOD RAIL FENCE, PROTECT IN PLACE
- ⑤ — 2" HMA PAVED SHOULDER
- ⑥ — 2" HMA, GRIND AND OVERLAY
- ⑦ — 4" HMA, OVER EXISTING AB

1 **PLAN**
DRIVEWAYS AT
3770 PONDEROSA RD.
APN: 070-240-017
SCALE: 1"=5'

- NOTES:
- 1. STATION OFFSET CALLOUTS PER 'P' ALIGNMENT.
 - 2. UNLESS NOTED, CUT/FILL SLOPES TO BE 2:1.

**DRIVEWAY
CONSTRUCTION DETAILS
SCALE : AS NOTED**

REVISION				BY
	NUMBER	DATE	DESCRIPTION	

PREPARED UNDER THE SUPERVISION OF :		DESIGNED: JB	DRAWN: CAD
		CHECKED: JB	DATE: 1/7/25
REGISTERED CIVIL ENGINEER		ROAD NUMBER: 005	
DATE:			



**COUNTY OF EL DORADO
DEPARTMENT OF TRANSPORTATION**

**PONDEROSA ROAD BICYCLE AND
PEDESTRIAN IMPROVEMENTS**
25-0282 C 12 of 15

SHEET
C-4
12 OF 46
W.O. No. **36109009**


ORIGINAL SCALE IS IN INCHES
Drawing name: Z:\Civil 3D Projects\97018 Ponderosa Class II Sidewalk\CADD Files\Sheets\C-SHEETS.dwg Layout Tab: C-5 Feb 05,2025 -- 5:42pm Dujich

FOR REDUCED PLANS

WARNER
APN 070-240-013
3750 PONDEROSA RD.

CONSTRUCTION NOTES:

- 1 — (E)CULVERT MARKER, PROTECT IN PLACE
- 2 — (E)FIRE HYDRANT, PROTECT IN PLACE
- 3 — (E)ROAD SIGN, PROTECT IN PLACE
- 4 — 2" HMA, GRIND AND OVERLAY
- 5 — 4" HMA, OVER EXISTING AB

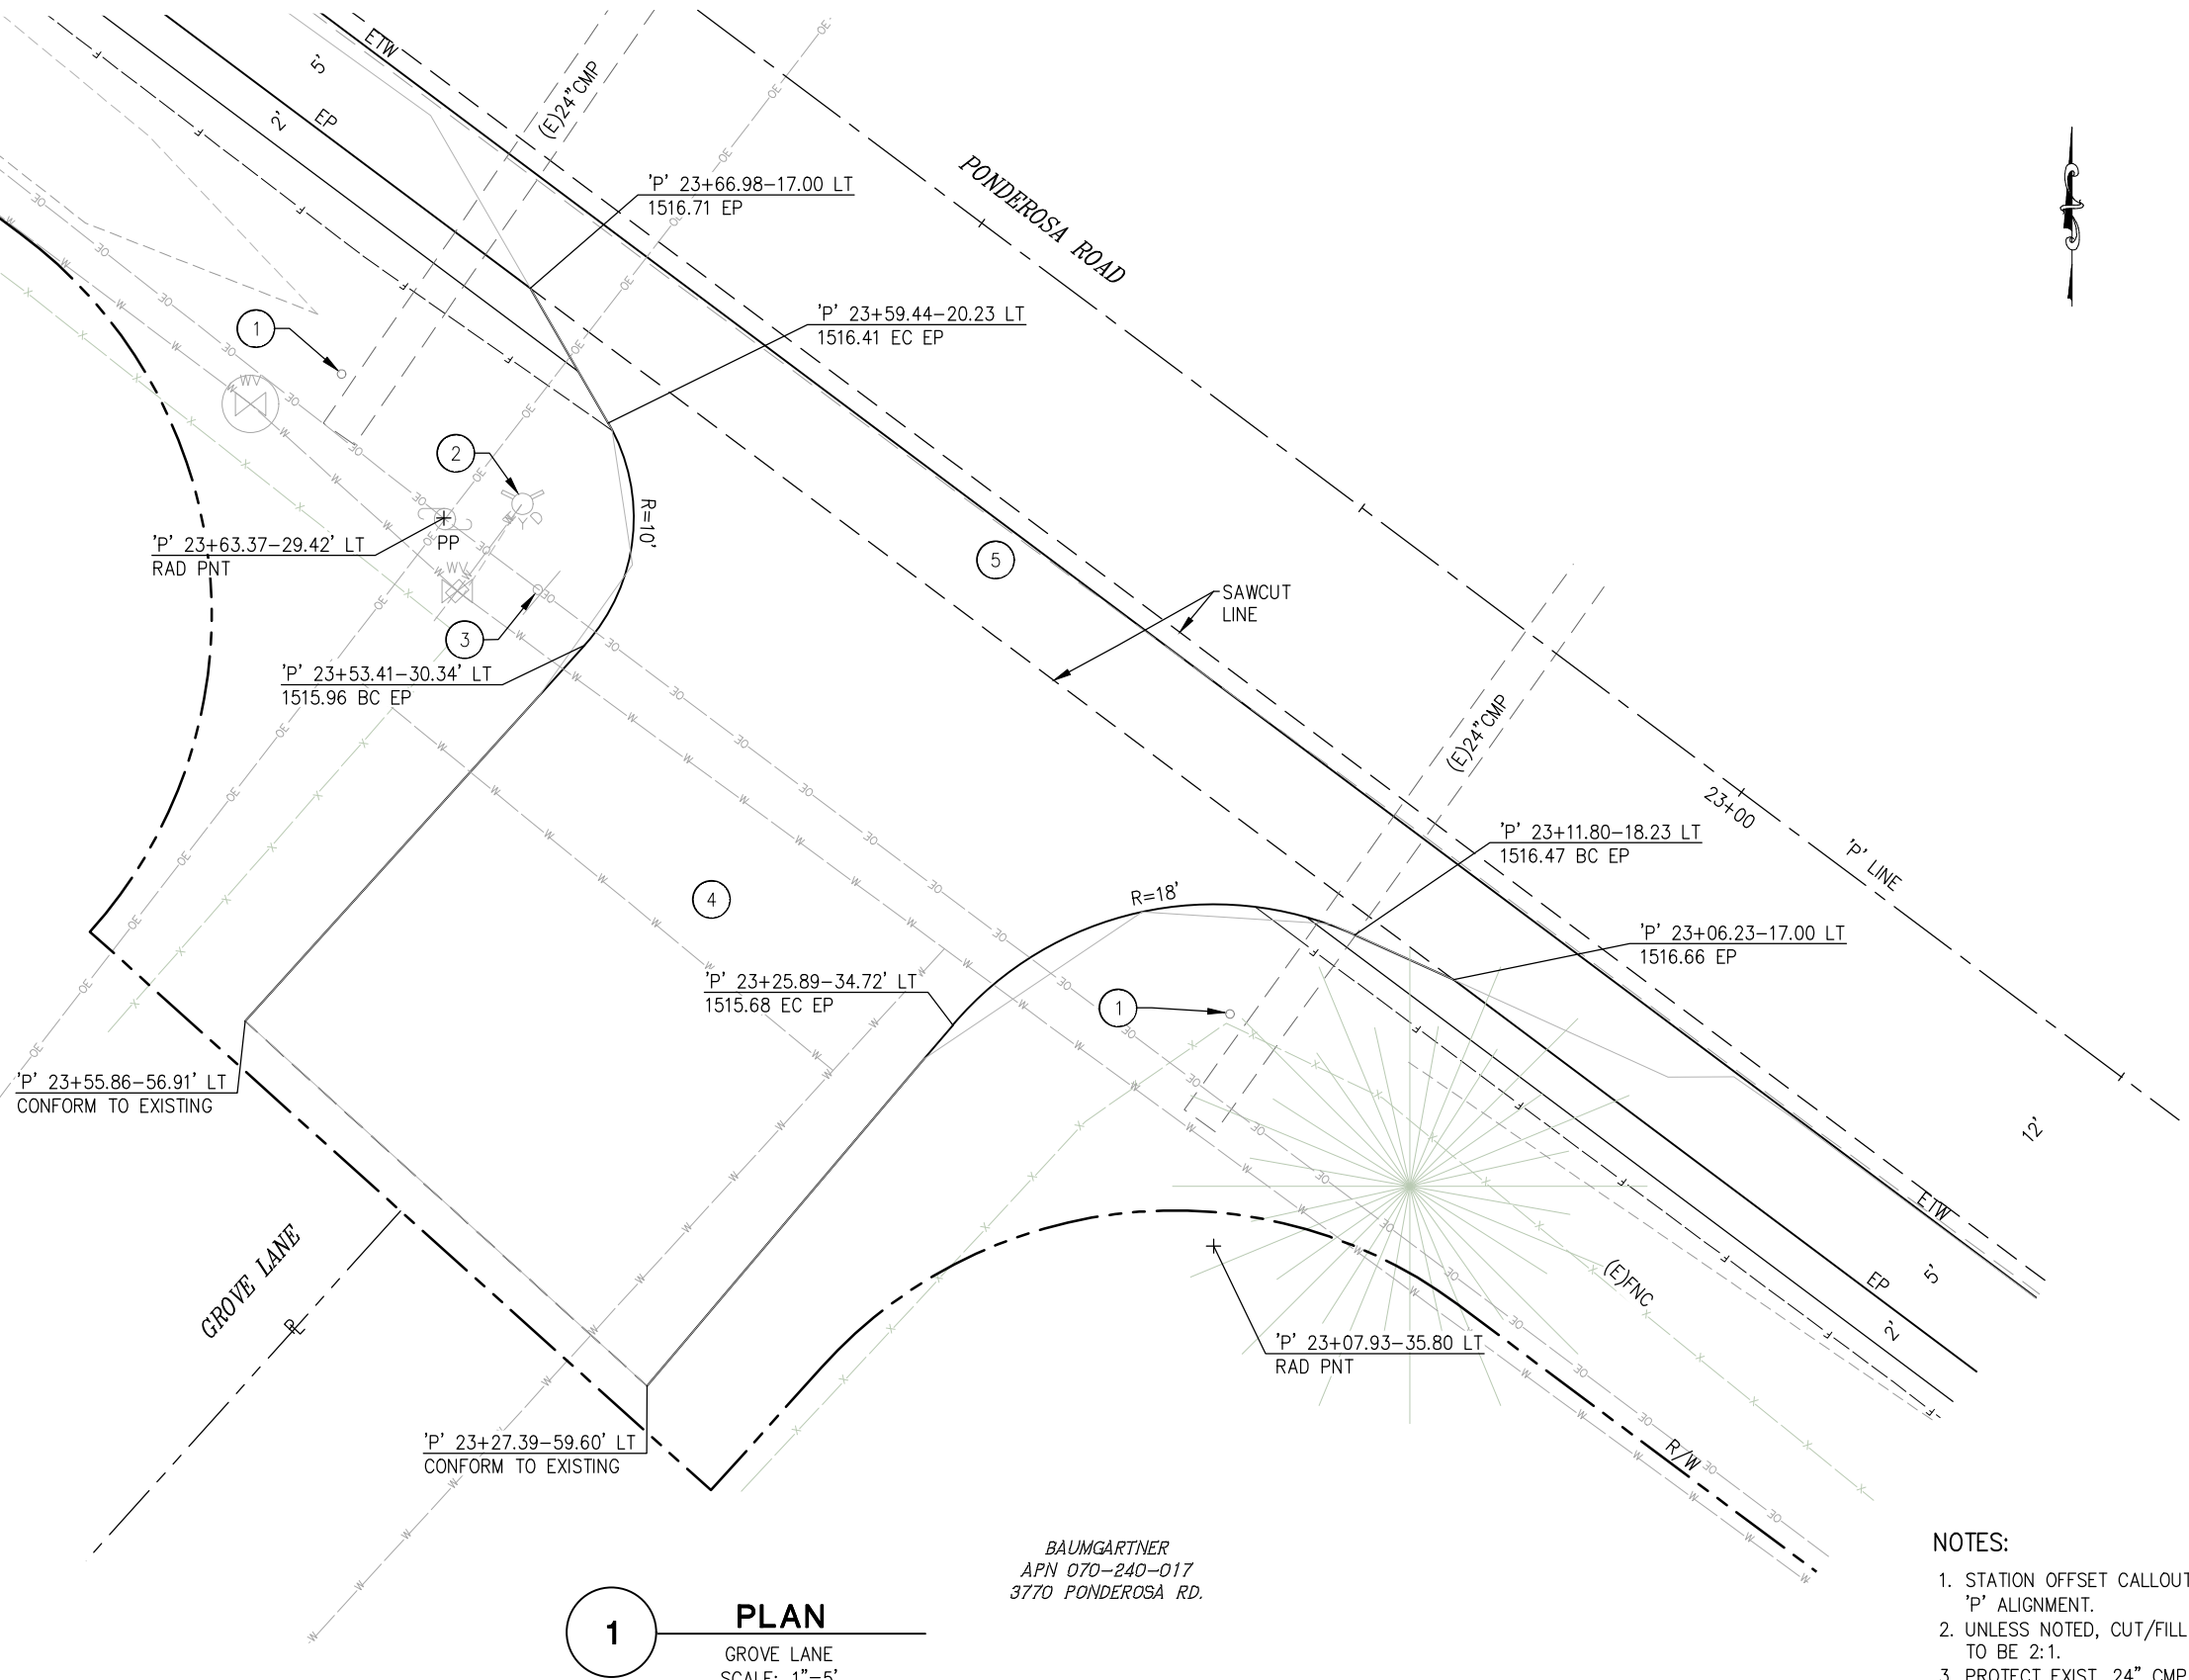

1 **PLAN**
GROVE LANE
SCALE: 1"=5'

BAUMGARTNER
APN 070-240-017
3770 PONDEROSA RD.

- NOTES:
- 1. STATION OFFSET CALLOUTS PER 'P' ALIGNMENT.
 - 2. UNLESS NOTED, CUT/FILL SLOPES TO BE 2:1.
 - 3. PROTECT EXIST. 24" CMP

**GROVE LANE
CONSTRUCTION DETAILS
SCALE : AS NOTED**

REVISION	NUMBER	DATE	DESCRIPTION	BY

PREPARED UNDER THE SUPERVISION OF :	DESIGNED: JIB	DRAWN: CAD
	CHECKED: JIB	DATE: 1/7/25
REGISTERED CIVIL ENGINEER	ROAD NUMBER: 005	
DATE:		



**COUNTY OF EL DORADO
DEPARTMENT OF TRANSPORTATION**


**PONDEROSA ROAD BICYCLE AND
PEDESTRIAN IMPROVEMENTS**

25-0282 C 13 of 15

SHEET
C-5
13 OF 46
W.O. No. 36109009

ORIGINAL SCALE: 1"=5' IN INCHES
Drawing name: Z:\Civil 3D Projects\97018 Ponderosa Class II Sidewalk\CADD Files\Sheets\C-SHEETS.dwg Layout Tab: C-6 Feb 05,2025 -- 5:42pm Dujich


FOR REDUCED PLANS
2
1
0

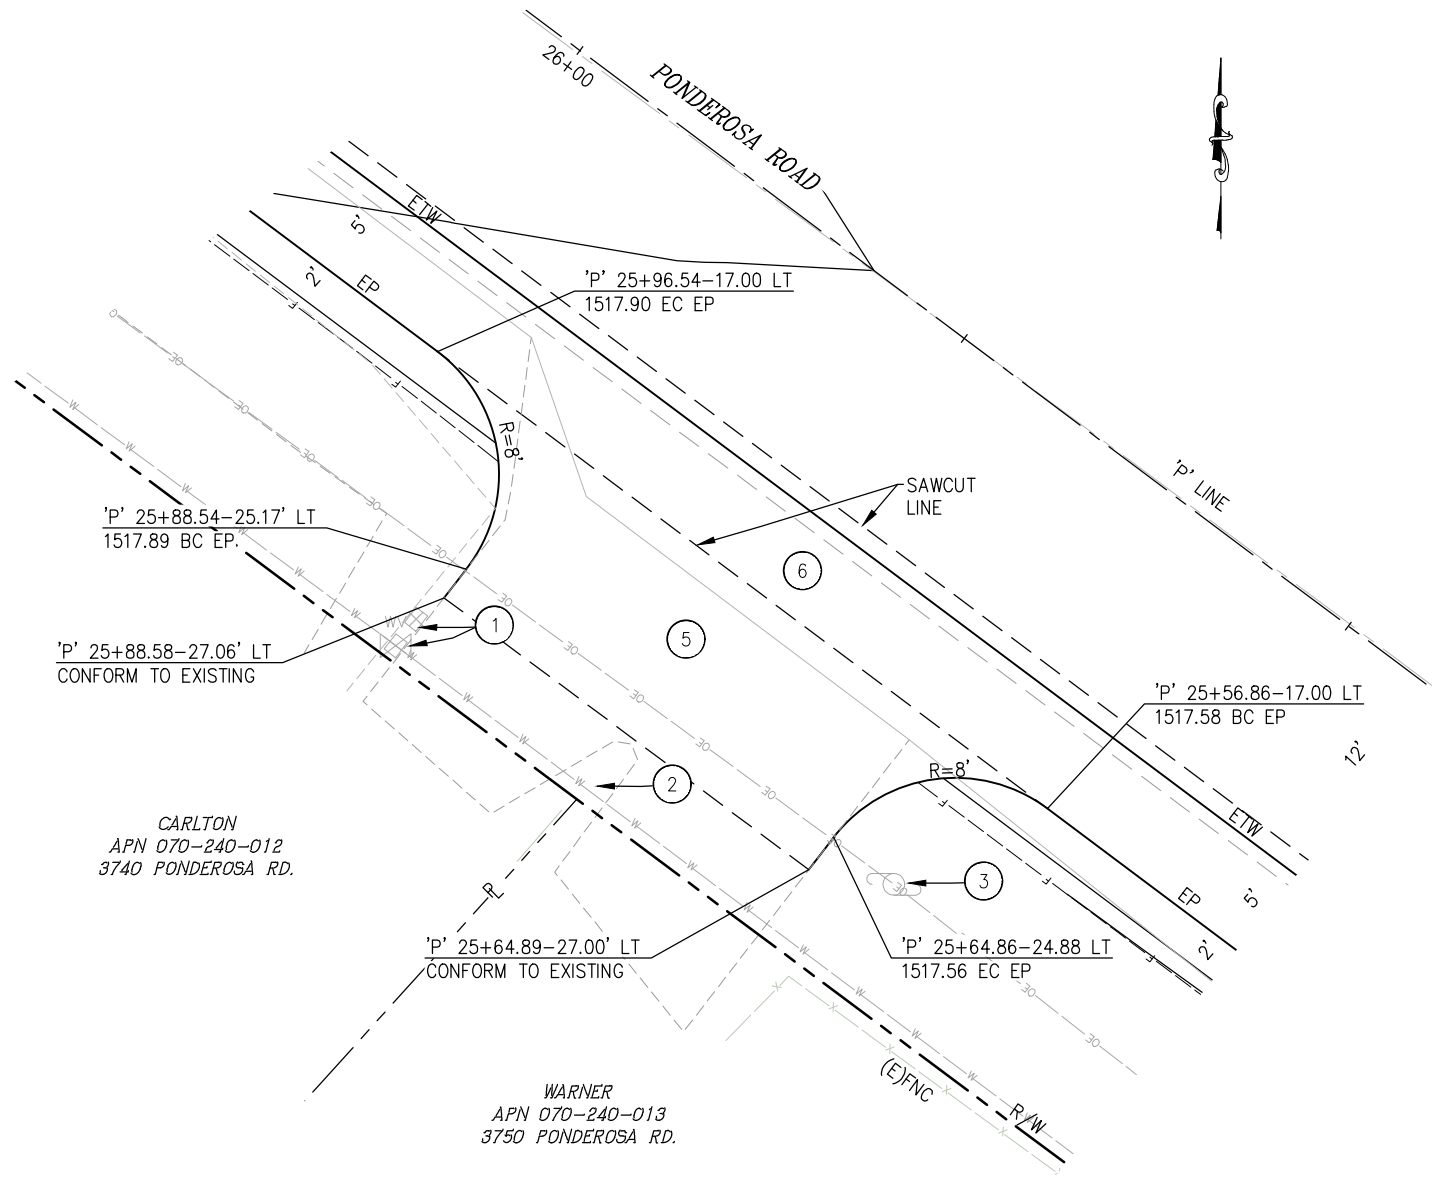

1 PLAN
DRIVEWAYS AT
3740 & 3750 PONDEROSA RD.
APN: 070-240-012 & 013
SCALE: 1"=5'

CONSTRUCTION NOTES:

- ① — (E)WATER VALVE, PROTECT IN PLACE
- ② — (E)FENCE AND GATE, PROTECT IN PLACE
- ③ — (E)POWER POLE, PROTECT IN PLACE
- ④ — (E)MAILBOX, PROTECT IN PLACE
- ⑤ — 2" HMA, GRIND AND OVERLAY
- ⑥ — 4" HMA, OVER EXISTING AB

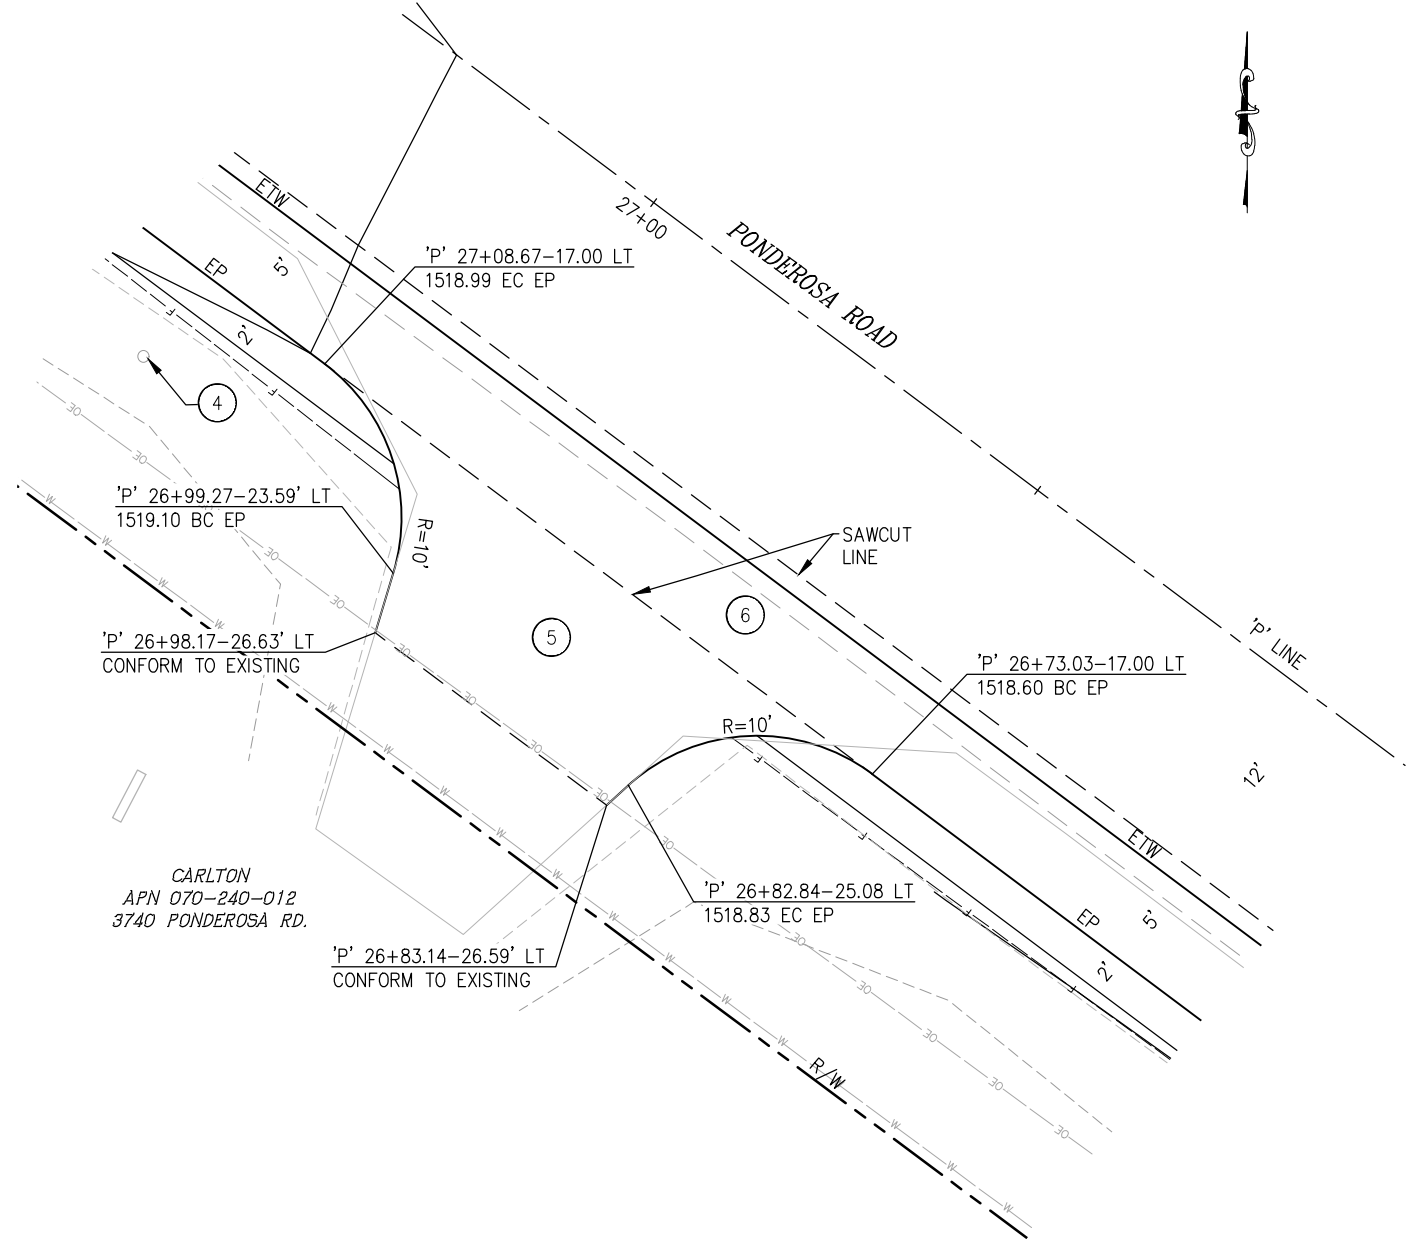

2 PLAN
DRIVEWAY AT
3740 PONDEROSA RD.
APN: 070-240-012
SCALE: 1"=5'

- NOTES:**
- 1. STATION OFFSET CALLOUTS PER 'P' ALIGNMENT.
 - 2. UNLESS NOTED, CUT/FILL SLOPES TO BE 2:1.

**DRIVEWAY
CONSTRUCTION DETAILS
SCALE : AS NOTED**

REVISION	NUMBER	DATE	DESCRIPTION	BY

PREPARED UNDER THE SUPERVISION OF :	DESIGNED: JB	DRAWN: CAD
	CHECKED: JB	DATE: 1/7/25
REGISTERED CIVIL ENGINEER	ROAD NUMBER: 005	
DATE:		



**COUNTY OF EL DORADO
DEPARTMENT OF TRANSPORTATION**


**PONDEROSA ROAD BICYCLE AND
PEDESTRIAN IMPROVEMENTS**

25-0282 C 14 of 15

SHEET
C-6
14 OF 46
W.O. No. 36109009

ORIGINAL SCALE IS IN INCHES
Drawing name: Z:\Civil 3D Projects\97018 Ponderosa Class II Sidewalk\CADD Files\Sheets\C-SHEETS.dwg Layout Tab: C-7 Feb 05,2025 -- 5:42pm Dujich


FOR REDUCED PLANS
2
1
0

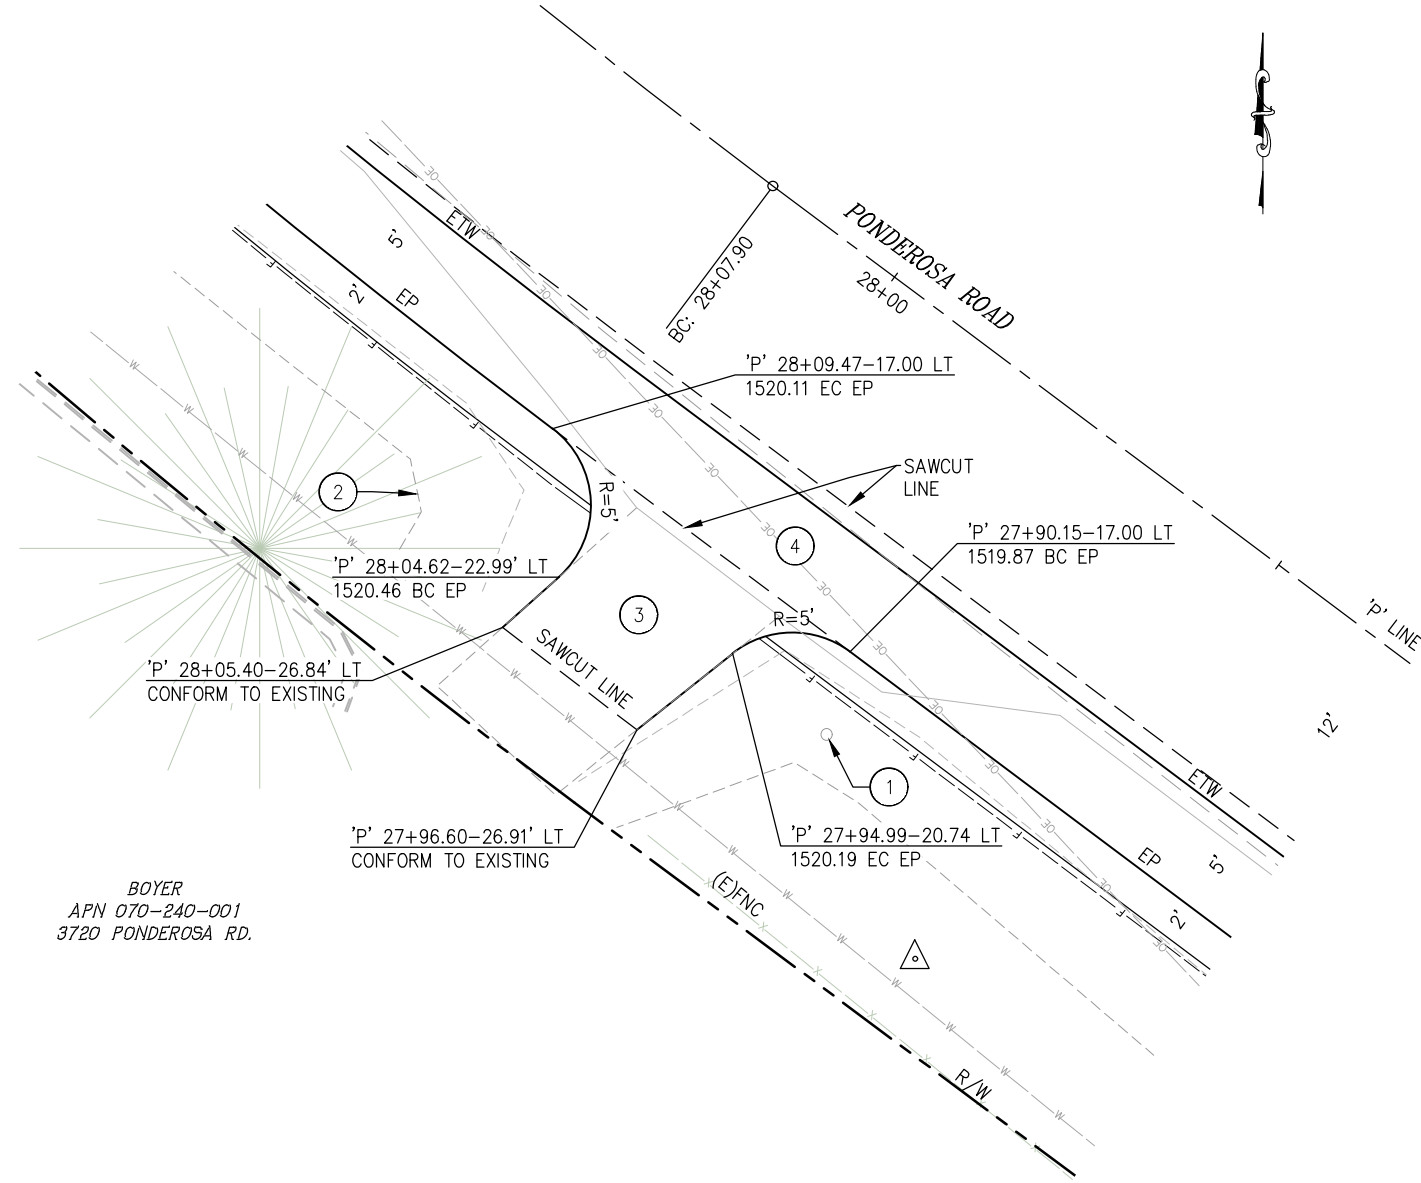

1 PLAN
DRIVEWAY AT
3720 PONDEROSA RD.
APN: 070-240-001
SCALE: 1"=5'

CONSTRUCTION NOTES:

- ① — (E)MAILBOX, PROTECT IN PLACE
- ② — (E)RETAINING WALL, PROTECT IN PLACE
- ③ — 2" HMA, GRIND AND OVERLAY
- ④ — 4" HMA, OVER EXISTING AB

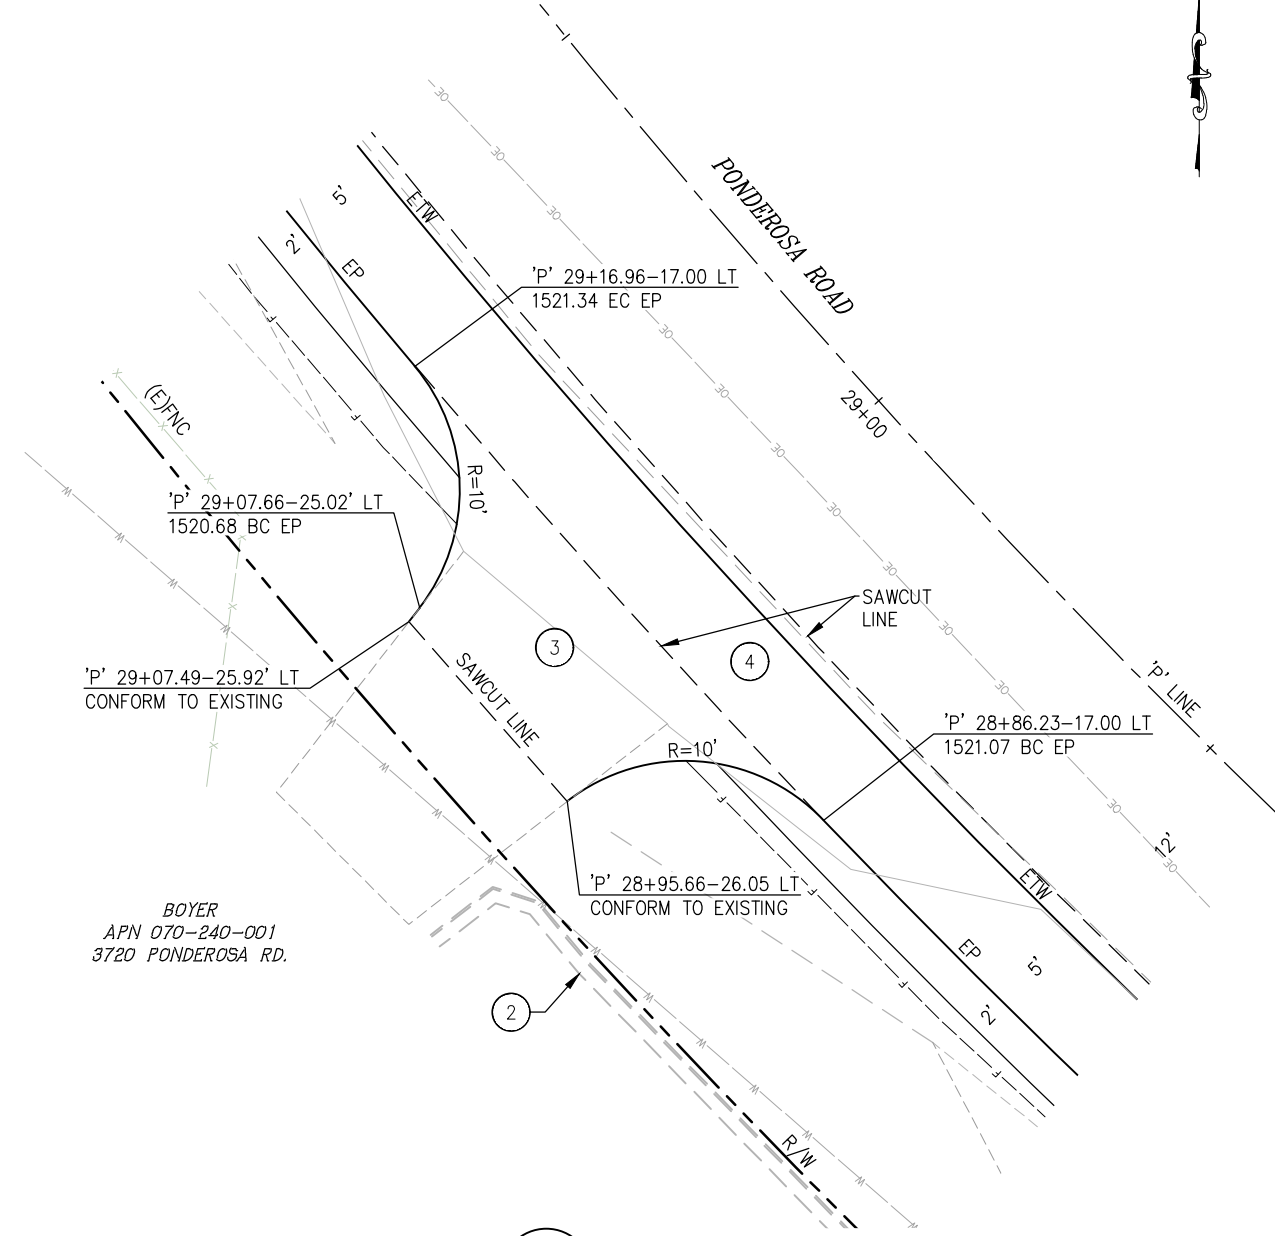

2 PLAN
DRIVEWAY AT
3720 PONDEROSA RD.
APN: 070-240-001
SCALE: 1"=5'

- NOTES:**
- 1. STATION OFFSET CALLOUTS PER 'P' ALIGNMENT.
 - 2. UNLESS NOTED, CUT/FILL SLOPES TO BE 2:1.

**DRIVEWAY
CONSTRUCTION DETAILS
SCALE : AS NOTED**

REVISION	NUMBER	DATE	DESCRIPTION	BY

PREPARED UNDER THE SUPERVISION OF :	DESIGNED: JB	DRAWN: CAD
	CHECKED: JB	DATE: 1/7/25
REGISTERED CIVIL ENGINEER	ROAD NUMBER: 005	
DATE:		



**COUNTY OF EL DORADO
DEPARTMENT OF TRANSPORTATION**

**PONDEROSA ROAD BICYCLE AND
PEDESTRIAN IMPROVEMENTS**

25-0282 C 15 of 15

SHEET	C-7
15 OF 46	
W.O. No.	36109009