


**INDEX OF SHEETS**

SHEET	PLAN SHEET	TITLE
1		TITLE SHEET
2	SPD-1	STRIPING LAYOUT & QUANTITIES
3	CS-1	CONSTRUCTION AREA SIGNS
4-6	E-1 TO E-3	ELECTRICAL LAYOUT
7	E-4	ELECTRICAL LAYOUT & REMOVAL
8-9	E-5 TO E-6	SIGNAL MODIFICATION

**COUNTY OF EL DORADO, CA**  
**COMMUNITY DEVELOPMENT AGENCY**  
**TRANSPORTATION DIVISION**  
 PROJECT PLANS FOR THE CONSTRUCTION OF  
**GREEN VALLEY ROAD**  
**TRAFFIC SIGNAL INTERCONNECT**

IN THE COUNTY OF EL DORADO, DISTRICT 1  
 ON GREEN VALLEY ROAD FROM MILEPOST 1.51 TO MILEPOST 2.14

To be supplemented with Standard Plans and Specifications dated 2010, including the Revised Standard Specifications, of the California Department of Transportation, unless otherwise noted.

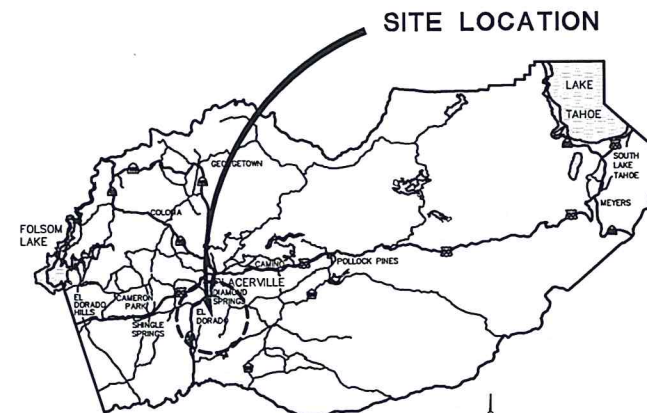


**VICINITY MAP**  
 COUNTY OF EL DORADO


**BOARD OF SUPERVISORS**

I	RON MIKULACO
II	SHIVA FRENTZEN
III	BRIAN K. VEERKAMP
IV	MICHAEL RANALLI
V	SUE NOVASEL

**COUNTY OF EL DORADO**  
**COMMUNITY DEVELOPMENT AGENCY**  
**TRANSPORTATION DIVISION**  
 (530) 621-5900  
 2850 FAIRLANE CT  
 PLACERVILLE, CA 95667

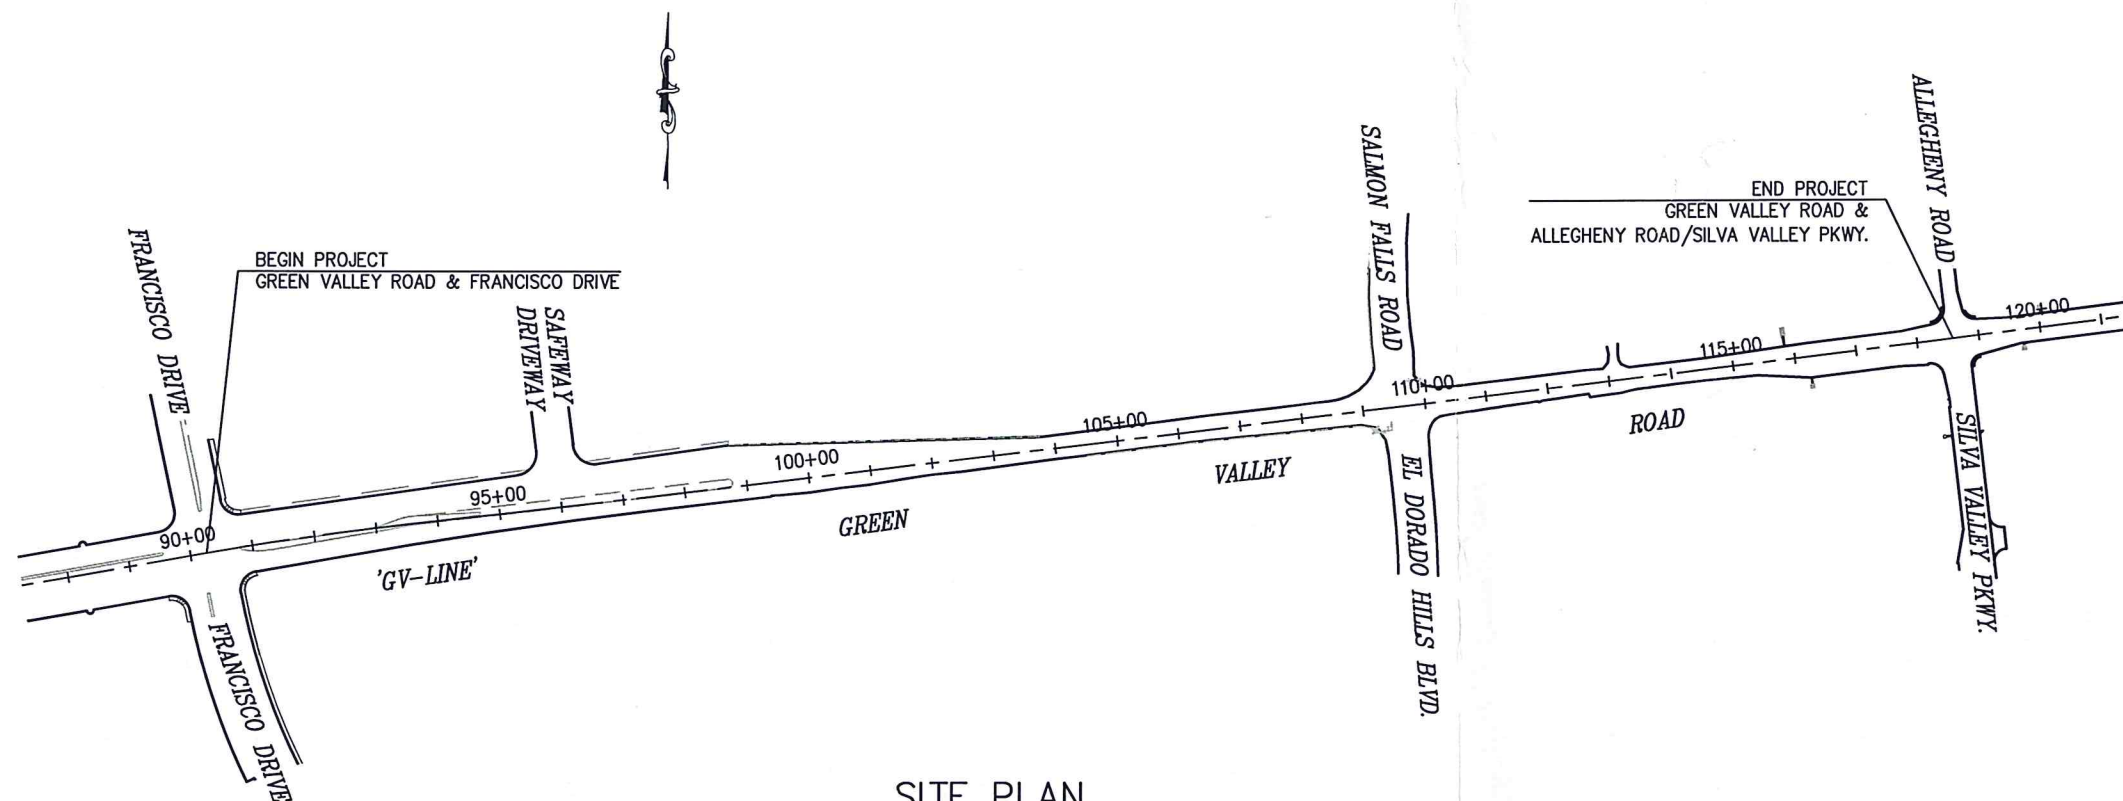

**SITE PLAN**  
 SCALE: 1" = 200'

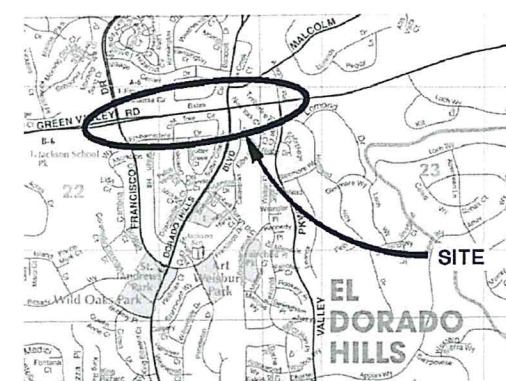

**LOCATION MAP**  
 NOT TO SCALE

**FEDERAL AID PROJECT**  
**HSIPL 5925 (115)**

ADOPTED AND APPROVED BY: *[Signature]* DATE: 6/2/15  
 BRAN K. VEERKAMP, COUNTY BOARD OF SUPERVISORS  
 CHAIR, EL DORADO COUNTY BOARD OF SUPERVISORS  
 APPROVED BY: *[Signature]* DATE: 5/15/15  
 STEVEN M. WEDRETH, COMMUNITY DEVELOPMENT AGENCY DIRECTOR  
 DEPUTY DIRECTOR, ENGINEERING DIVISION

**CONTRACTOR'S LICENSE CLASSIFICATION:** Bidders shall be properly licensed to perform the Work pursuant to the State Contractor's License Act (Business and Professions Code section 7000 et seq.) and shall possess a CLASS A LICENSE or equivalent combination of Classes required by the categories and type of Work included in the Contract Documents and Plans. If the Contractor possesses a Class A license instead of the equivalent combination of Classes required by the categories and type of work included in the Contract Documents and Plans, then the Contractor or a subcontractor must also possess a CLASS C27 "Landscaping Contractor" license. Failure of the successful Bidder to obtain proper and adequate licensing at the time bids are submitted shall constitute a failure to execute the Contract, and forfeiture as provided under that section.

**REVISIONS**

MARK	DATE	BY



*[Signature]*  
 DUSTIN W. HARRINGTON  
 REGISTERED CIVIL ENGINEER No. 71517  
 6/2/2015  
 DATE

PW NO. 14-31065 PROJECT NO. 73151  
**GREEN VALLEY ROAD**  
**TRAFFIC SIGNAL INTERCONNECT**  
**TITLE SHEET**  
 SHEET 1 OF 9