

Drawing name: Z:\Cal. 20 Projects\W04026 Pioneer\Drawings\Sheet\Title Sheet.dwg | Layout Tab | Date: Nov 07, 2024 | 3:26pm | gmtaroon
 PROJECT ENGINEER SIGNATURE: Rodolfo Avila Jr.
 DESIGN OVERSIGHT APPROVAL: Rodolfo Avila Jr.
 REGISTRATION NO.: C68700
 DATE: 12/10/24


INDEX OF SHEETS

SHEET	PLAN SHEET	TITLE
1		TITLE SHEET
2-6	CD-1 THRU CD-5	SURVEY CONTROL DIAGRAM
7-10	X-1 THRU X-4	TYPICAL SECTIONS
11-15	L-1 THRU L-5	LAYOUT
16-19	P-1 THRU P-4	PROFILES
20-40	C-1 THRU C-21	CONSTRUCTION DETAILS
41	G-1	CONTOUR GRADING
42-48	D-1 THRU D-7	DRAINAGE
49-53	PD-1 THRU PD-5	PAVEMENT DELINEATION
54	PD-6	PAVEMENT DELINEATION QUANTITIES
55-58	S-1 THRU S-4	SIGNING
59-60	S-5 THRU S-6	SIGNING QUANTITIES
61-66	SC-1 THRU SC-6	STAGE CONSTRUCTION
67-70	TH-1 THRU TH-4	TRAFFIC HANDLING
71	CS-1	CONSTRUCTION AREA SIGNS
72-75	TR-1 THRU TR-4	TREE REMOVAL
76	LD-1	LANDSCAPE DETAILS
77-79	EC-1 THRU EC-3	EROSION CONTROL
80-87	E-1 THRU E-8	MODIFY SIGNAL AND LIGHTING
88-94	ED-1 THRU ED-7	ELECTRICAL SYSTEM DETAILS

Approved as to impact on State facilities and conformance with applicable State Standards and Practices and that technical oversight was performed as described in the California Department of Transportation A&E Consultant Services Manual.

STATE OF CALIFORNIA
DEPARTMENT OF TRANSPORTATION
PROJECT PLANS FOR THE CONSTRUCTION ON
STATE HIGHWAY
PIONEER TRAIL/US HIGHWAY 50
INTERSECTION SAFETY
IMPROVEMENT PROJECT

IN THE COUNTY OF EL DORADO, DISTRICT 5
 AT THE INTERSECTION OF STATE HIGHWAY 50 AND PIONEER TRAIL
 To be supplemented with Standard Plans and Specifications dated 2023, of the California Department of Transportation, unless otherwise noted.

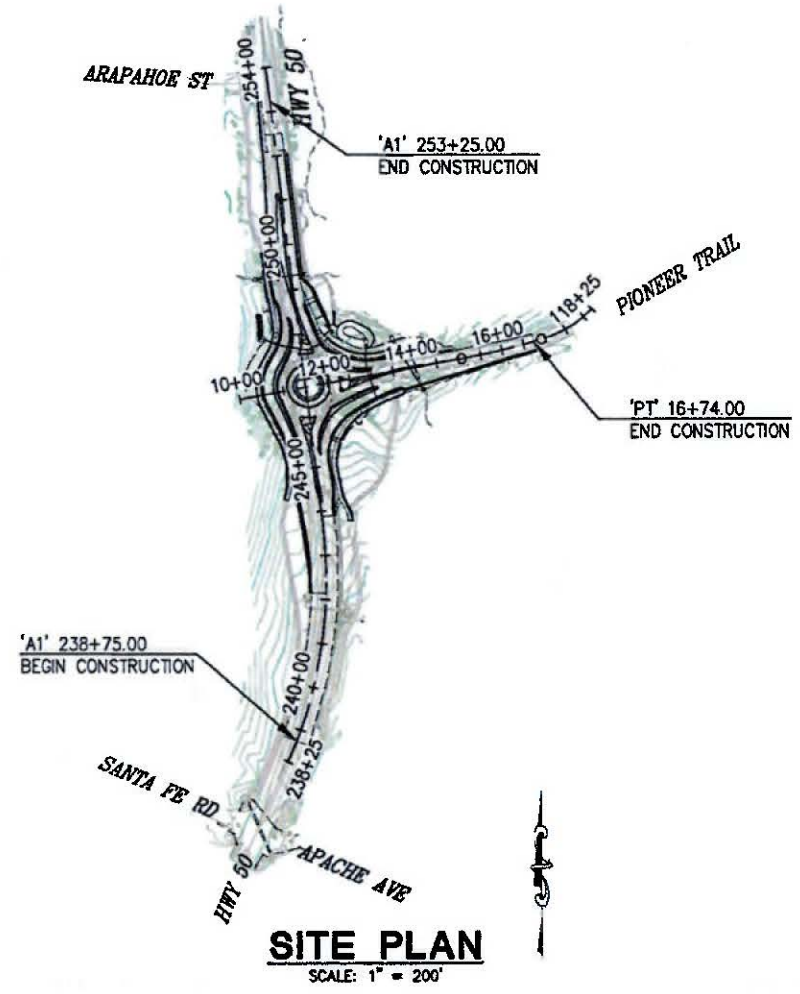

SITE PLAN
 SCALE: 1" = 200'

DIST	COUNTY	ROUTE	POST MILES	TOTAL PROJECT	SHEET NO.	TOTAL SHEETS
03	ED	50	71.33-71.60		1	94



The state of California or its officers or agents shall not be responsible for the accuracy or completeness of electronic copies of this plan sheet

FEDERAL ID#
 CMSTPL5925(148)



SUBMITTED BY:
 CIVIL ENGINEER
 STATE OF CALIFORNIA NO. C68083
 DECEMBER 29, 2023
 DATE

CONTRACTOR'S LICENSE CLASSIFICATION: Bidders shall be properly licensed to perform the Work pursuant to the State Contractor's License Act (Business and Professions Code section 7000 et seq.) and shall possess a CLASS A LICENSE or equivalent combination of Classes required by the categories and type of Work included in the Contract Documents and Plans. Failure of the successful Bidder to obtain proper and adequate licensing at the time bids are submitted shall constitute a failure to execute the Contract, and forfeiture as provided under that section.

EFIS 0317000163 | CU | CONTRACT NO. 7614

ADOPTED AND APPROVED BY:
 Wendy Thomas 12/16/24
 CHAIR, EL DORADO COUNTY BOARD OF SUPERVISORS
 Rafael Martinez 12/13/24
 DEPARTMENT OF TRANSPORTATION
 John Kahling 12/12/24
 DEPUTY DIRECTOR, ENGINEERING

COUNTY OF EL DORADO
DEPARTMENT OF TRANSPORTATION
 2850 FAIRLANE COURT
 PLACERVILLE, CA 95667
 (916) 621-5900



REVISIONS		
MARK	DATE	BY

BOARD OF SUPERVISORS
 JOHN HIDAHL I
 GEORGE TURNBOO II
 WENDY THOMAS III
 LORI PARLIN IV
 BROOKE LAINE V

PIONEER TRAIL/US HIGHWAY 50
INTERSECTION SAFETY
IMPROVEMENT PROJECT
TITLE SHEET
 SHEET 1 OF 94