

INDEX OF SHEETS

SHEET NO.	PLAN SHEET	TITLE
1		TITLE SHEET & LOCATION MAP
2-5	X-1 to X-4	TYPICAL CROSS SECTIONS
6	CD-1	SURVEY AND CONTROL DIAGRAM
7	K-1	KEY MAP
8-12	L-1 to L-5	PLAN AND PROFILE
13	SE-1	SUPER ELEVATION DIAGRAM
14-15	C-1 to C-2	CONSTRUCTION DETAILS
16-19	C-3 to C-6	PLAN VIEW DETAILS
20	C-7	'WF' LINE PROFILE
21-25	G-1 to G-5	CONTOUR GRADING PLAN
26-32	D-1 to D-7	DRAINAGE PLANS
33-34	D-8 to D-9	DRAINAGE QUANTITIES
35-39	U-1 to U-5	UTILITY PLANS
40-43	SC-1 to SC-4	STAGE CONSTRUCTION AND TRAFFIC HANDLING, STAGE 1
44-47	SC-5 to SC-8	STAGE CONSTRUCTION AND TRAFFIC HANDLING, STAGE 2
48	SC-9	STAGE CONSTRUCTION AND TRAFFIC HANDLING, STAGE 3
49	CS-1	CONSTRUCTION AREA SIGNS
50-55	PD-1 to PD-6	PAVEMENT DELINEATION PLANS
56	Q-1	SUMMARY OF QUANTITIES
57-62	S-1 to S-6	SIGNING PLANS
63-67	EC-1 to EC-5	EROSION CONTROL
68-71	E-1 to E-4	ELECTRICAL PLANS
72	RW-1	RETAINING WALL
73-79	CAC-1 TO CAC-7	ARCH CULVERT

DEPARTMENT OF TRANSPORTATION COUNTY OF EL DORADO, CA



Nathan Connelly
REGISTERED CIVIL ENGINEER
No. 64459
Exp. 08-30-07
CIVIL
STATE OF CALIFORNIA


PLANS APPROVAL DATE

COUNTY OF EL DORADO
PLACERVILLE, CA. 95667

Dokken Engineering
550 Main Street, Suite G-1
Placerville, CA 95667 (530) 295-1080

PROJECT PLANS FOR CONSTRUCTION OF IMPROVEMENTS IN EL DORADO COUNTY FOR WHITE ROCK ROAD REALIGNMENT AND WIDENING MANCHESTER DRIVE TO LATROBE ROAD CONTRACT No. 72401

To be supplemented by the State of California Department of Transportation
Standard Plans dated July 2002, County of El Dorado
Design and Improvement Standards Manual revised March 1994

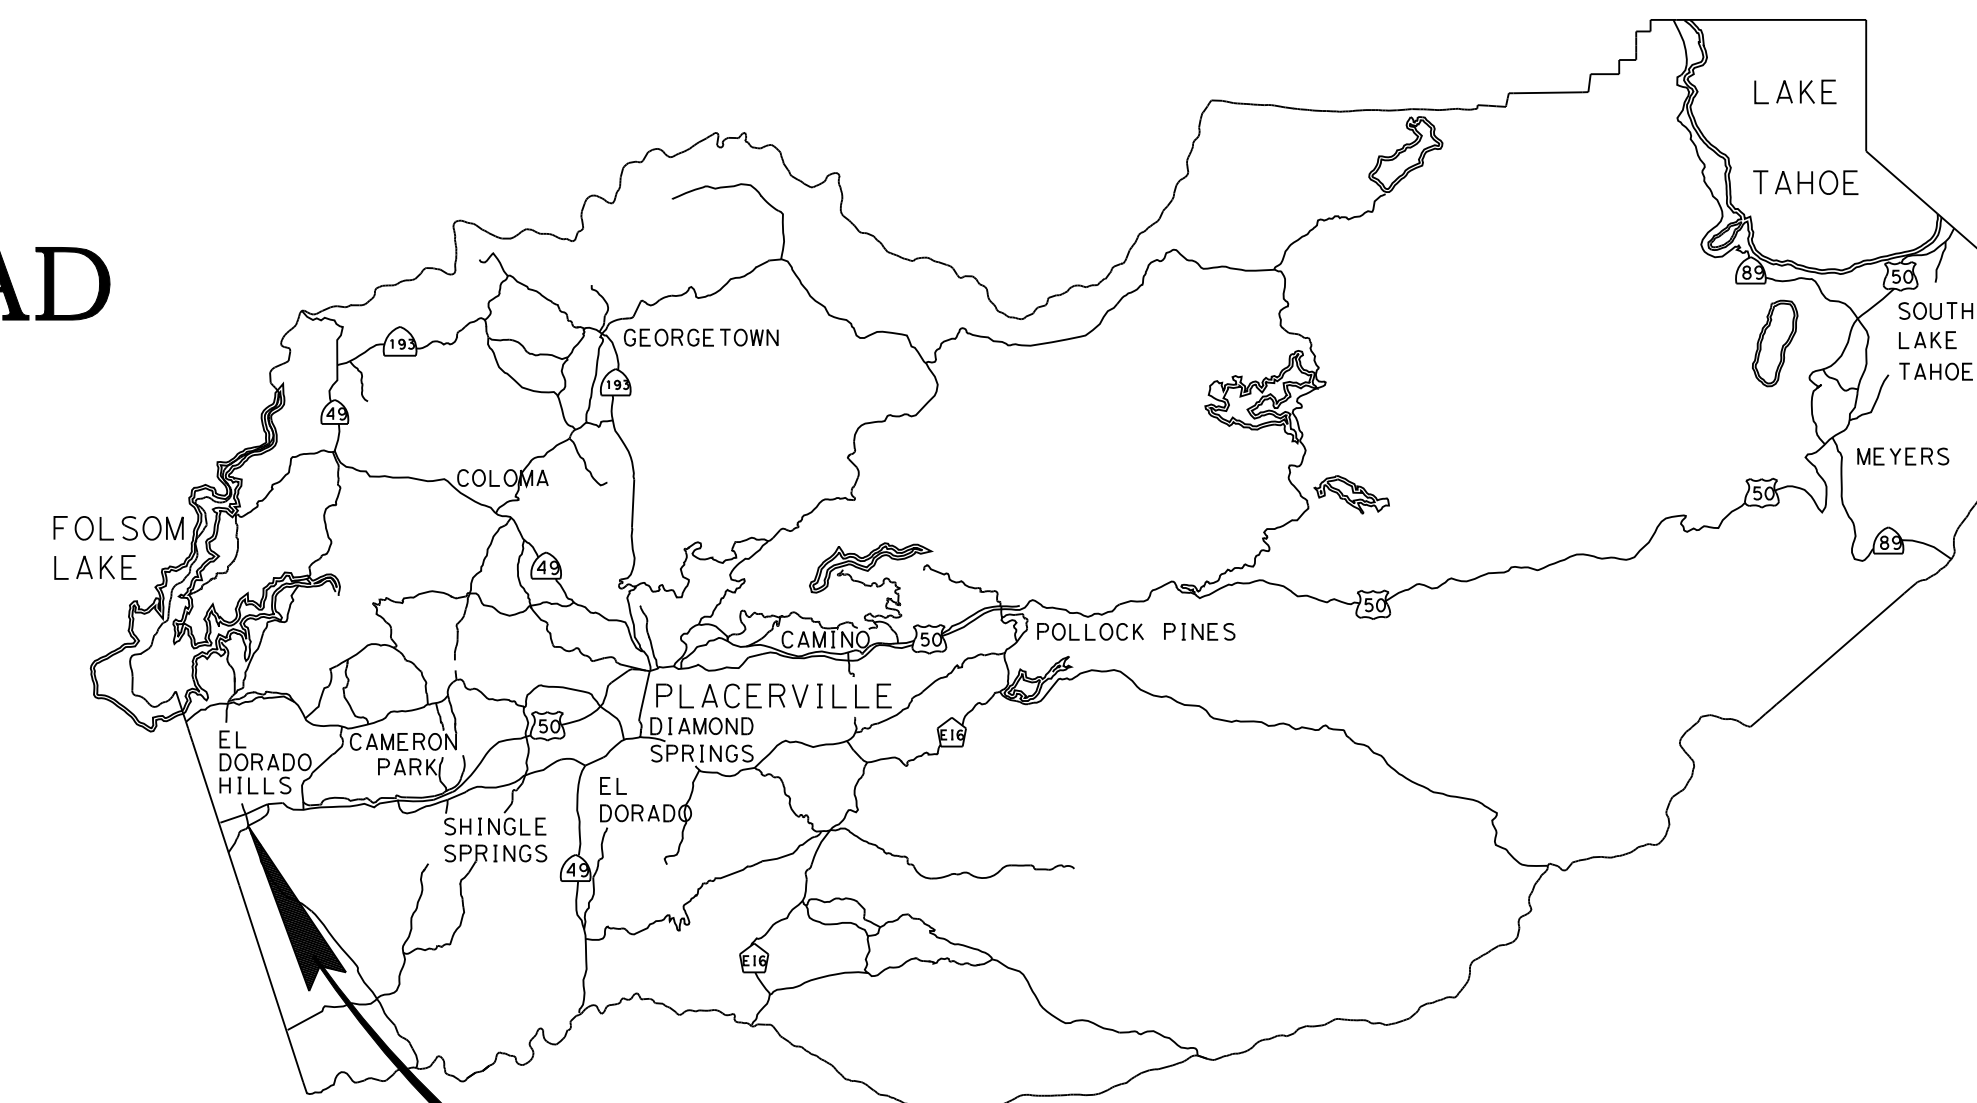

**PROJECT LIMITS
STA 'WR' 21+31.380**

Begin Work
Sta 'WR' 20+31

Limit of Work (Windfield Way)
Sta 43+43.975

Limit of Work (Windfield Way)
Sta 42+14.855

**PROJECT LIMITS
STA 'WR' 32+69.393**

End Work
Sta 'WR' 33+70


SITE LOCATION

LOCATION MAP

EL DORADO COUNTY

NOTES:

- RELOCATE EXIST FENCES WHEN REQUIRED.
- PARCEL NUMBERS SHOWN ON UTILTIY SHEETS.

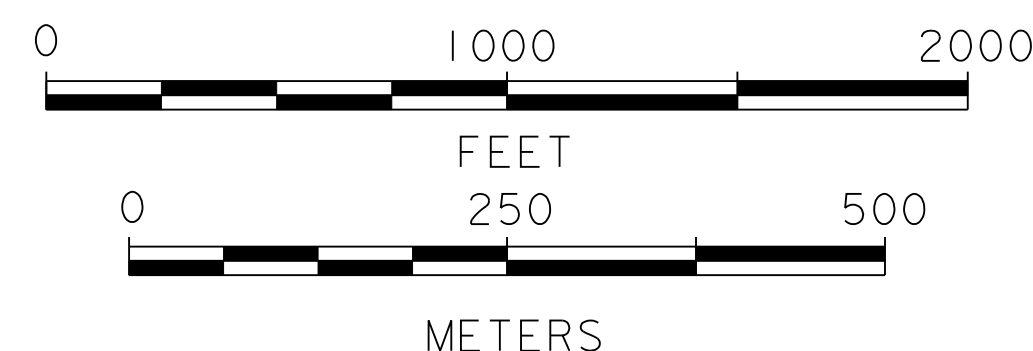

LEGEND


ROAD CONSTRUCTION

THE CONTRACTOR SHALL POSSESS THE CLASS (OR CLASSES) OF LICENSE AS SPECIFIED IN THE "NOTICE TO CONTRACTORS"

APPROVED BY:	DATE
JAMES R. SWEENEY CHAIRMAN, EL DORADO COUNTY BOARD OF SUPERVISORS	
RICHARD SHEPARD, P.E. NO. C35439 DIRECTOR, EL DORADO COUNTY DEPARTMENT OF TRANSPORTATION	
RUSSELL NYGARRD, P.E. NO. C50369 DEPUTY DIRECTOR, EL DORADO COUNTY DEPARTMENT OF TRANSPORTATION	

COUNTY OF EL DORADO
DEPARTMENT OF TRANSPORTATION

2850 FAIRLANE COURT
PLACERVILLE, CA 95667
(530) 621-5900

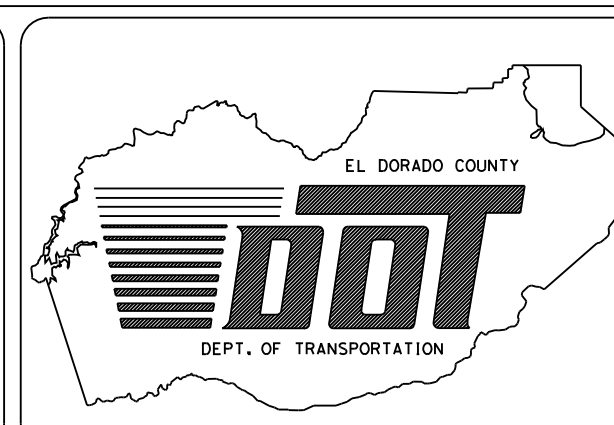

REVISIONS		
MARK	DATE	BY

BOARD OF SUPERVISORS	
RUSTY DUPRAY	I
HELEN BAUMANN	II
JAMES SWEENEY	III
VACANT	IV
NORMA SANTIAGO	V

WHITE ROCK ROAD
REALIGNMENT AND
WIDENING MANCHESTER
DRIVE TO LATROBE ROAD
TITLE SHEET
SHEET 1 OF 79