

INDEX OF SHEETS

SHEET	PLAN SHEET	TITLE
1		TITLE SHEET
2	CD-1	SURVEY AND CONTROL DIAGRAM
3-4	L-1 THRU L-2	LAYOUT
5	TR-1	TREE REMOVAL


COUNTY OF EL DORADO, CA DEPARTMENT OF TRANSPORTATION

PROJECT PLANS FOR THE CONSTRUCTION OF CLEAR CREEK ROAD SCOUR MITIGATION


IN THE COUNTY OF EL DORADO, DISTRICT 3
APPROX 1 MILE NORTH OF THE SLY PARK ROAD/CLEAR CREEK ROAD INTERSECTION
To be supplemented with Standard Plans and Specifications dated 2018, including the 2018 Revised Standard Specifications, of the California Department of Transportation, unless otherwise noted.



SITE PLAN
SCALE: 1"=40'

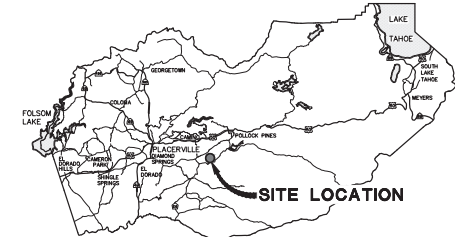


VICINITY MAP
COUNTY OF EL DORADO

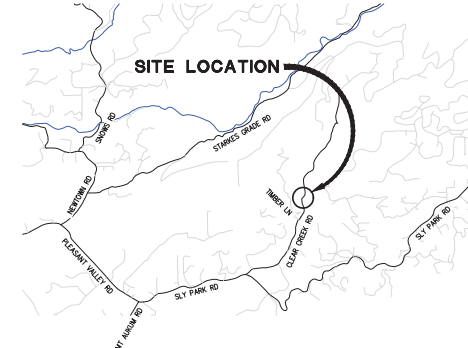

LOCATION MAP
NOT TO SCALE

FUNDING AGENCY

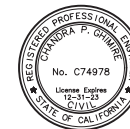

Chandra Ghimire 08/03/23
DATE
SUBMITTED BY:
CIVIL ENGINEER
STATE OF CALIFORNIA.

BOARD OF SUPERVISORS

I	JOHN HIDAHL
II	GEORGE TURNBOO
III	WENDY THOMAS
IV	LORI PARLIN
V	SUE NOVASEL

**COUNTY OF EL DORADO
DEPARTMENT OF TRANSPORTATION**

(530) 621-5900
2850 FAIRLANE CT
PLACERVILLE, CA 95667

ACCEPTED AND APPROVED BY:

DATE	
LORI PARLIN, CHAIR, EL DORADO COUNTY BOARD OF SUPERVISORS	
APPROVED BY:	
RAFAEL MARTINEZ, DIRECTOR, DEPARTMENT OF TRANSPORTATION	
DATE	
DATE	
DATE	

CONTRACT NO. 7444 CIP NO. 36106002
**CLEAR CREEK ROAD
SCOUR MITIGATION**
TITLE SHEET
SHEET 1 OF 5


CONTRACTOR'S LICENSE CLASSIFICATION: Bidders shall be properly licensed to perform the Work pursuant to the State Contractor's License Act (Business and Professions Code section 7000 et seq.) and shall possess a CLASS A LICENSE or equivalent combination of Classes required by the categories and type of Work included in the Contract Documents and Plans. Failure of the successful Bidder to obtain proper and adequate licensing at the time bids are submitted shall constitute a failure to execute the Contract, and forfeiture as provided under that section.

REVISIONS

MARK	DATE	BY



ORIGINAL SCALE IS IN INCHES
 Drawing name: Z:\Civil_3D\Projects\36106002_Clear_Creek_Rd_Scour_Mitigation\CADD_Files\Sheets\CD-Sheets.dwg Layout Tab: CD-1 Aug 09, 2023 8:50am dldkert

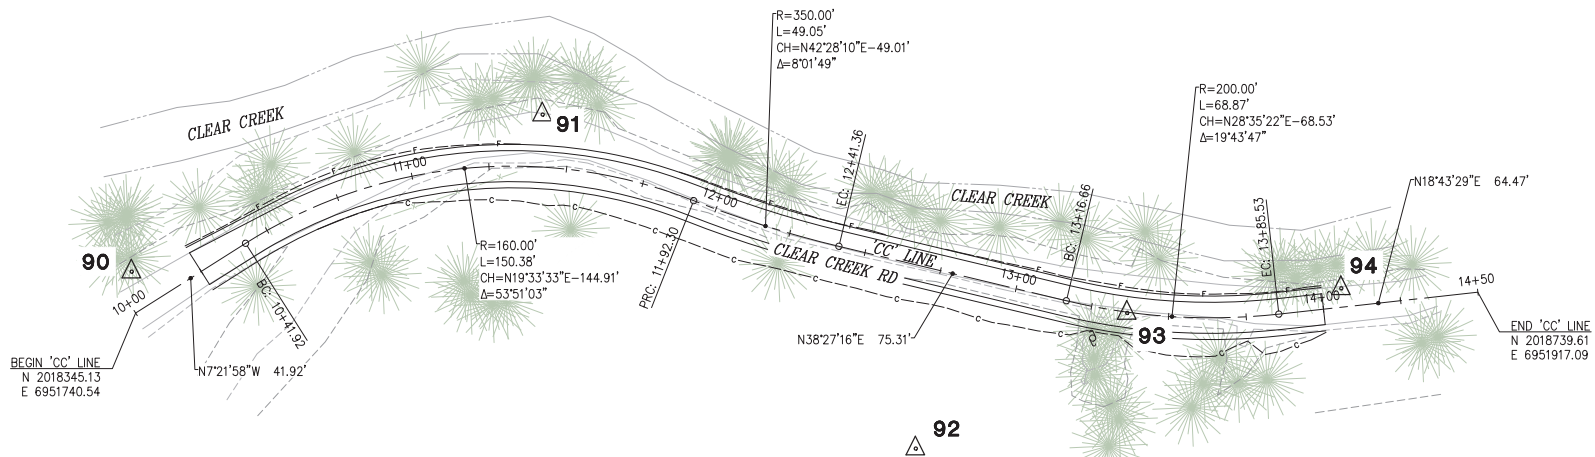


CONTROL TABLE				
CONTROL NUMBER	NORTHING	EASTING	ELEVATION	DESCRIPTION
90	2018349.63	6951727.96	2618.87	CP SPIKE
91	2018490.91	6951738.03	2624.25	CP SPIKE
92	2018554.34	6951886.25	2662.78	CP GIN_SPIKE
93	2018634.48	6951875.45	2628.53	CP SPIKE
94	2018700.32	6951897.39	2627.75	CP Mag

SURVEY NOTES:



BEARINGS, DISTANCES, STATIONING, AND COORDINATES SHOWN HEREON ARE BASED ON THE CALIFORNIA STATE COORDINATE SYSTEM OF 1983, ZONE 2 (1991.35) U.S. SURVEY FEET.

 DIVIDE DISTANCES SHOWN BY 0.999808 TO OBTAIN GROUND DISTANCES.




ELEVATIONS SHOWN HEREON REFERENCE NGVD 29.



SURVEY AND CONTROL DIAGRAM
 SCALE : 1" = 20'


<table border="1" style="width: 100%; border-collapse: collapse;"> <thead> <tr> <th>REVISION</th> <th>NUMBER</th> <th>DATE</th> <th>DESCRIPTION</th> <th>BY</th> </tr> </thead> <tbody> <tr><td> </td><td> </td><td> </td><td> </td><td> </td></tr> <tr><td> </td><td> </td><td> </td><td> </td><td> </td></tr> <tr><td> </td><td> </td><td> </td><td> </td><td> </td></tr> <tr><td> </td><td> </td><td> </td><td> </td><td> </td></tr> </tbody> </table>	REVISION	NUMBER	DATE	DESCRIPTION	BY																					 PREPARED UNDER THE SUPERVISION OF: <i>Joseph C. Neely</i> REGISTERED CIVIL ENGINEER DATE: 08/03/25	DESIGNED: CR DRAWN: SGM CHECKED: CG DATE: 11/07/22 ROAD NUMBER: 0B1	 COUNTY OF EL DORADO DEPARTMENT OF TRANSPORTATION	CLEAR CREEK ROAD SCOUR MITIGATION	SHEET CD-1 2 OF 5 W.O. No. 36106002
REVISION	NUMBER	DATE	DESCRIPTION	BY																										

ORIGINAL SCALE: 1/8" = 10' INCHES
 Drawing name: Z:\Civil_3D\Projects\36106002_Clear_Creek_Rd_Scour_Mitigation\CADD_Files\Sheets\L-1_Sheets.dwg Layout: Tab: L-1 Aug 09, 2023 8:50am ddkkert

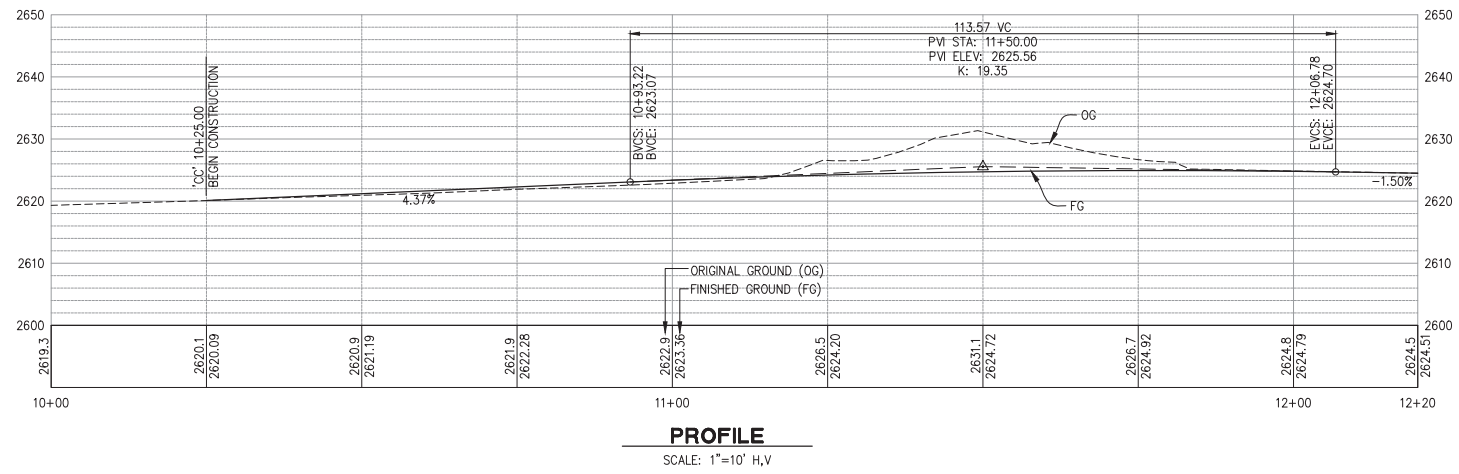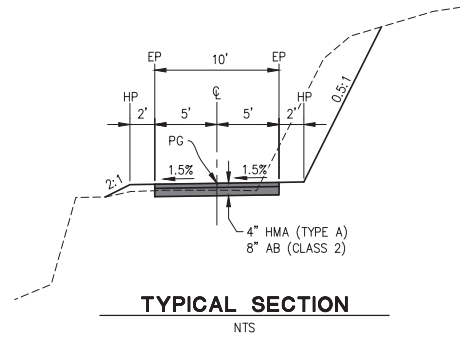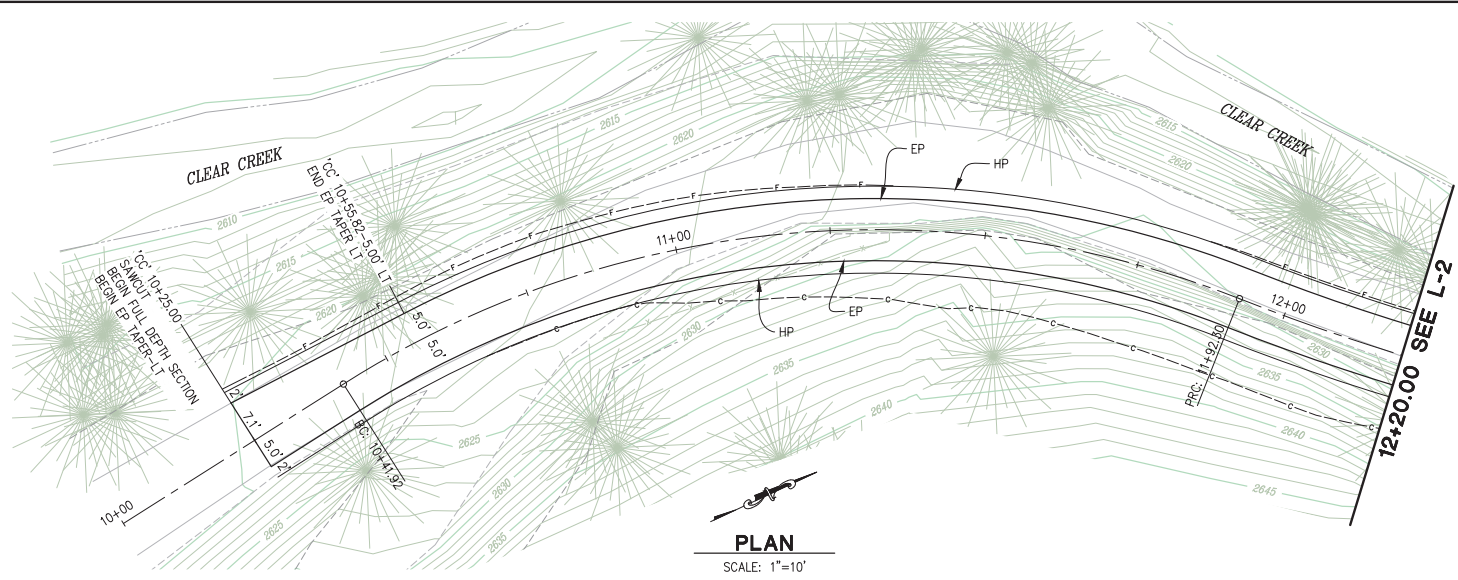

FOR REDUCED PLANS
 2'
 1'
 0'

REVISION	NUMBER	DATE	DESCRIPTION	BY

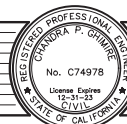

PREPARED UNDER THE SUPERVISION OF:
Chandra Ghimire
 REGISTERED CIVIL ENGINEER
 DATE: 08/03/23

DESIGNED: CR
 DRAWN: SCM
 CHECKED: CG
 DATE: 11/07/22
 ROAD NUMBER: 0B1


 


COUNTY OF EL DORADO
 DEPARTMENT OF TRANSPORTATION


CLEAR CREEK ROAD SCOUR
 MITIGATION

LAYOUT
 SCALE : AS SHOWN
 SHEET
L-1
 3 OF 5
 W.O. No. **36106002**

ORIGINAL SCALE IS IN INCHES
 Drawing name: Z:\Civil_3D\Projects\36106002_Clear_Creek_Rd_Scour_Mitigation\CADD_Files\Sheets\L-2_Sheets.dwg Layout Tab: L-2 Aug 09 2023 - 8:50am dkkkrt
 FOR REDUCED PLANS

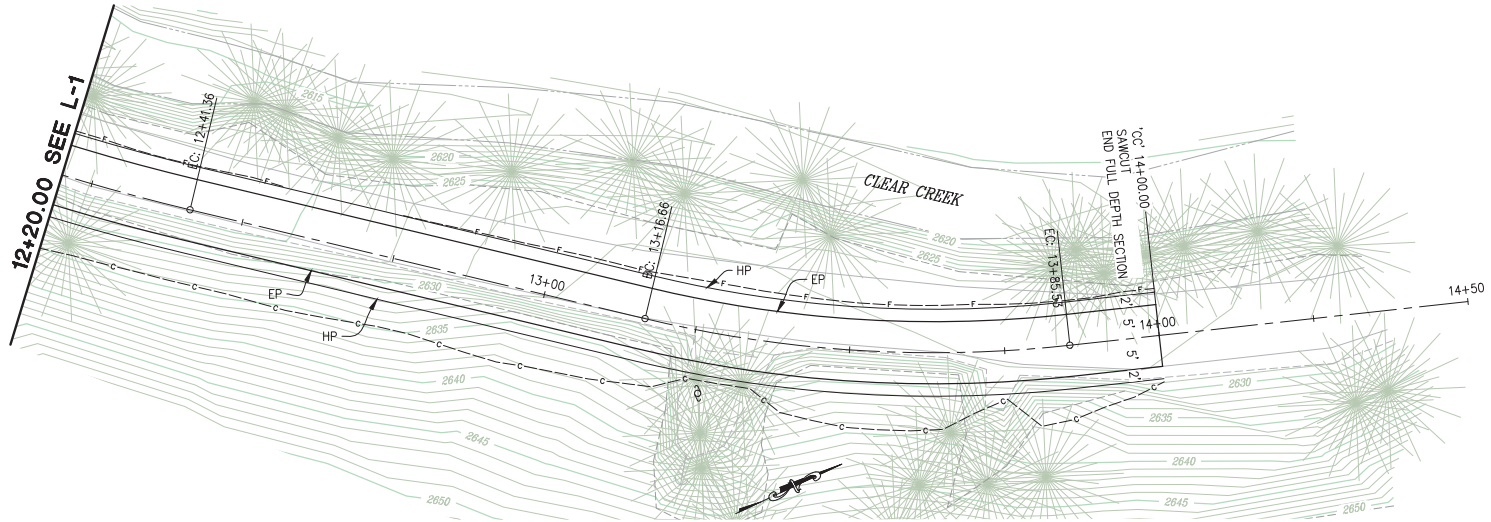

PLAN
SCALE: 1"=10'

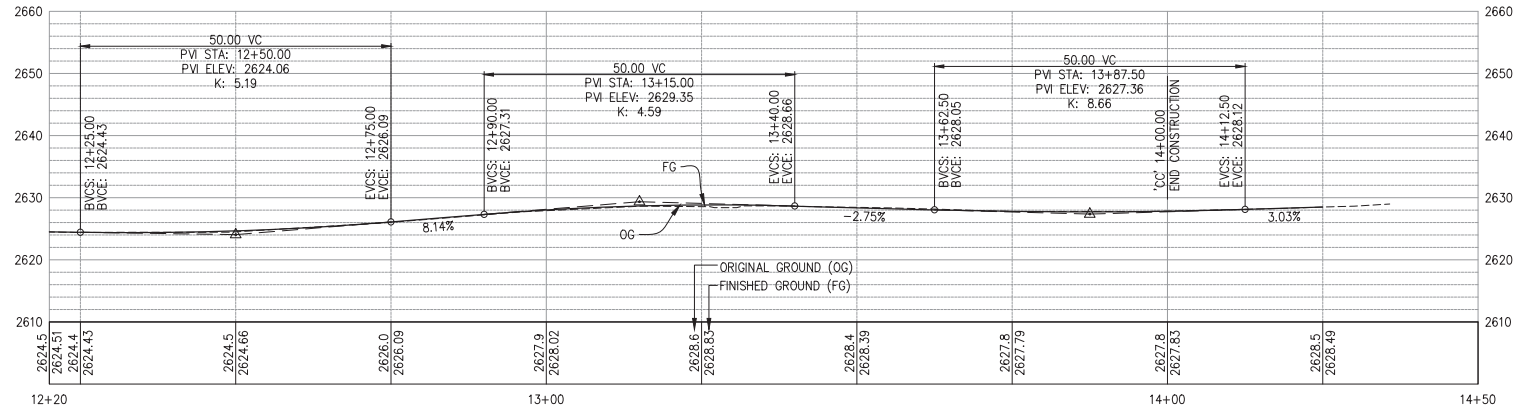

PROFILE
SCALE: 1"=10' H,V



PREPARED UNDER THE SUPERVISION OF:
Chandra Ghimire
 REGISTERED CIVIL ENGINEER
 DATE: 08/03/23

DESIGNED: CR
 DRAWN: SGM
 CHECKED: CG
 DATE: 11/07/22
 ROAD NUMBER: 0B1




 
COUNTY OF EL DORADO
DEPARTMENT OF TRANSPORTATION

CLEAR CREEK ROAD SCOUR
MITIGATION

LAYOUT
 SCALE : AS SHOWN

SHEET
L-2
 4 OF 5
 W.O. No. **36106002**

ORIGINAL SCALE: 1/8" = 1' INCHES
 Drawing name: Z:\Civil_3D\Projects\36106002_Clear_Creek_Rd_Scour_Mitigation\CADD_Files\Sheets\TR-Sheets.dwg Layout Tab: TR-1 Aug 09 2023 - 8:50am dkikert

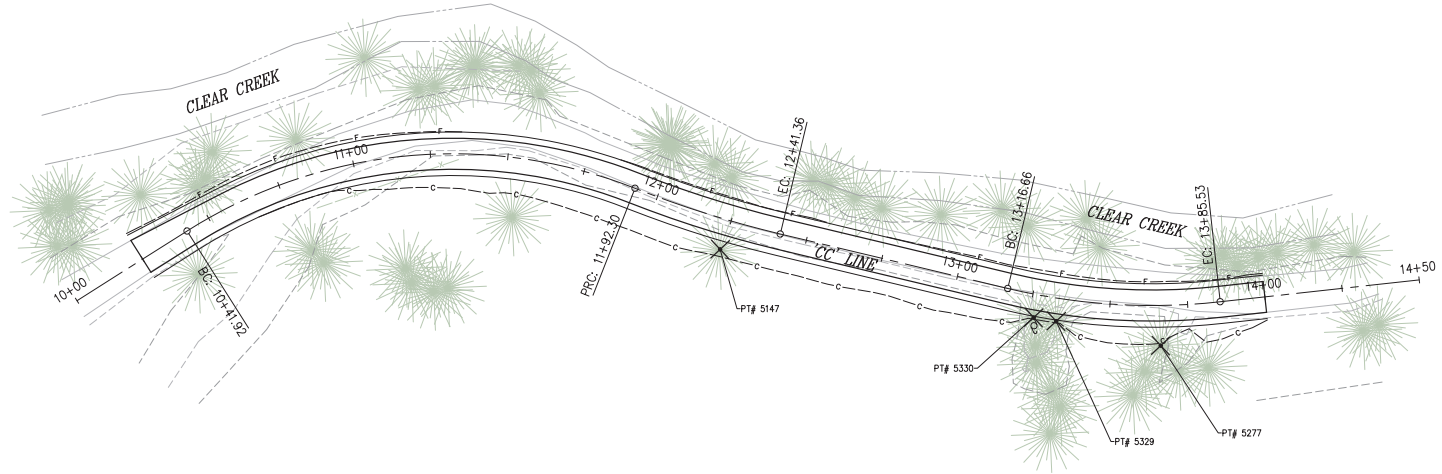

TREE REMOVAL TABLE			
POINT NUMBER	'CC' LINE STATION	OFFSET	DESCRIPTION & DIA.
5147	12+24.15	9.76 RT	MADRONE-0.83"
5330	13+26.59	7.42 RT	FIR FORKED-1.17"
5329	13+33.67	7.37 RT	CEDAR-0.50"
5277	13+66.18	12.94 RT	FIR-0.83"

TREE REMOVAL
SCALE : 1" = 20'

REVISION	NUMBER	DATE	DESCRIPTION	BY



PREPARED UNDER THE SUPERVISION OF:
Chandra Ghimire
 REGISTERED CIVIL ENGINEER
 DATE: 08/03/23

DESIGNED: CR	DRAWN: SGM
CHECKED: CG	DATE: 11/07/22
ROAD NUMBER: OB1	



COUNTY OF EL DORADO
DEPARTMENT OF TRANSPORTATION

CLEAR CREEK ROAD SCOUR MITIGATION	SHEET TR-1 5 OF 5 W.O. No. 36106002
--	---