

NORTH



MICROWAVE ANTENNA LAYOUT



36)	3
17)	



WIRELESS

SAC AE DESIGN GROUP, INC.

5015 SHOREHAM PLACE, STE. 150
SAN DIEGO, CA 92122

www.sacw.com
619.736.3766


verizon

OUTINGDALE
PSL # 295537
4260 RANCHO MONTES DRIVE
PLACERVILLE, CA 95667


SHEET TITLE:
EQUIPMENT &
ANTENNA LAYOUTS

A-2

NOTE: THE ORIGINAL SIZE OF THIS PLAN IS 24" X 36". SCALE: 1/8" = 1'-0" (24x36) (OR) 1/16" = 1'-0" (11x17)

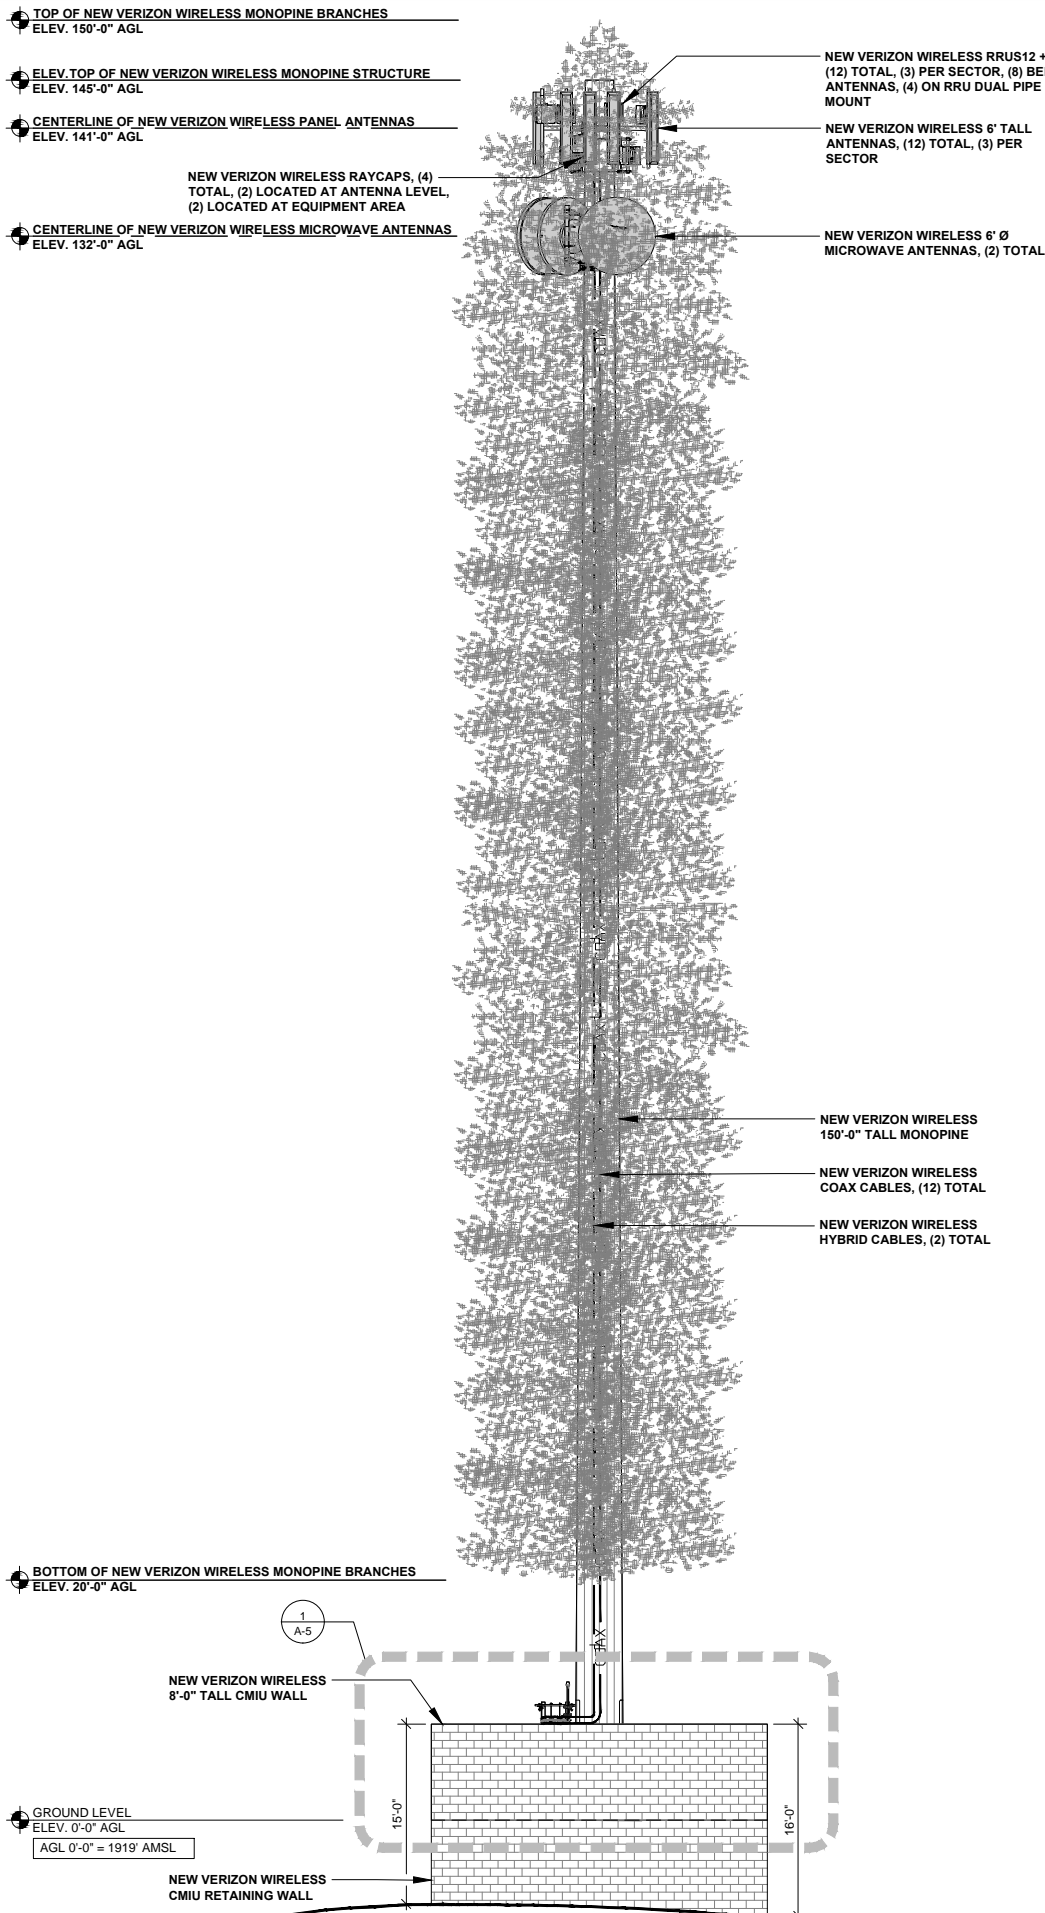

NOTE:
PAINT ALL NEW VERIZON WIRELESS EQUIPMENT TO MATCH MONOPINE

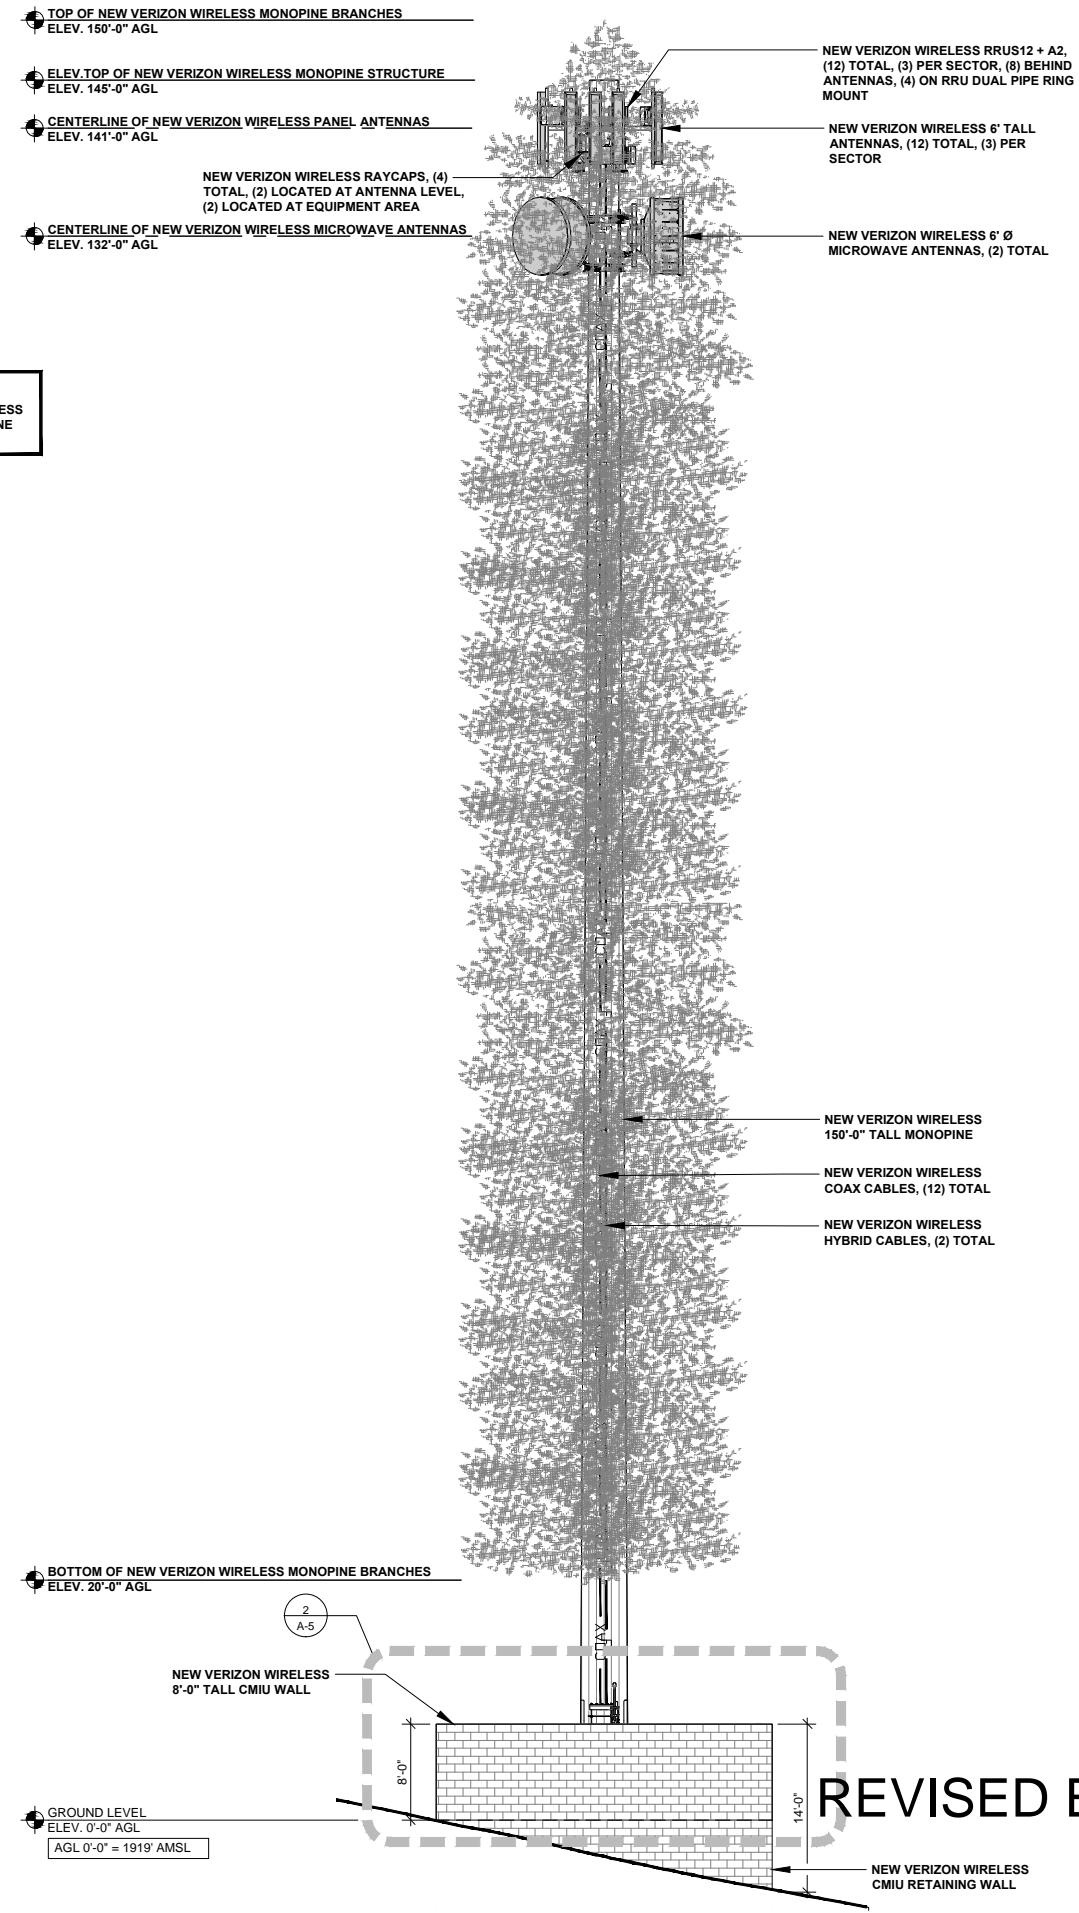

ISSUE STATUS			
REV.	DATE	DESCRIPTION	BY
0	04/13/15	90% ZONING	FA
1	05/06/15	100% ZONING	FA
2	06/22/15	100% ZONING	NG
3	07/14/15	100% ZONING	NG
4	10/06/16	100% ZONING	FA



SAC AE DESIGN GROUP, INC.
5015 SHOREHAM PLACE, STE. 150
SAN DIEGO, CA 92122
www.sacw.com
619.736.3766

PROPRIETARY INFORMATION
THE INFORMATION CONTAINED IN THIS SET OF DRAWINGS IS PROPRIETARY & CONFIDENTIAL TO VERIZON WIRELESS
ANY USE OR DISCLOSURE OTHER THAN AS IT RELATES TO VERIZON WIRELESS IS STRICTLY PROHIBITED



2785 MITCHELL DRIVE, BLDG 9
WALNUT CREEK, CA 94598

OUTINGDALE

PSL # 295537

4260 RANCHO MONTES DRIVE
PLACERVILLE, CA 95667

SHEET TITLE:
NORTH & EAST ELEVATIONS

A-3

NORTH ELEVATION

0 2' 4' 8' SCALE: 1/8" = 1'-0" (24x36) (OR) 1/16" = 1'-0" (11x17)

EAST ELEVATION

0 2' 4' 8' SCALE: 1/8" = 1'-0" (24x36) (OR) 1/16" = 1'-0" (11x17)

REVISED Exhibit E-5

NOTE: THE ORIGINAL SIZE OF THIS PLAN IS 24" X 36". SCALE: 1/8" = 1'-0" (24x36) (OR) 1/16" = 1'-0" (11x17)

 
- TOP OF NEW VERIZON WIRELESS MONOPINE BRANCHES
ELEV. 150'-0" AGL
- ELEV. TOP OF NEW VERIZON WIRELESS MONOPINE STRUCTURE
ELEV. 145'-0" AGL
- CENTERLINE OF NEW VERIZON WIRELESS PANEL ANTENNAS
ELEV. 141'-0" AGL
- CENTERLINE OF NEW VERIZON WIRELESS MICROWAVE ANTENNAS
ELEV. 132'-0" AGL
- NEW VERIZON WIRELESS RRUS12 + A2,
(12) TOTAL, (3) PER SECTOR, (8) BEHIND
ANTENNAS, (4) ON RRU DUAL PIPE RING
MOUNT
- NEW VERIZON WIRELESS 6' TALL
ANTENNAS, (12) TOTAL, (3) PER
SECTOR
- NEW VERIZON WIRELESS RAYCAPS, (4)
TOTAL, (2) LOCATED AT ANTENNA LEVEL,
(2) LOCATED AT EQUIPMENT AREA
- NEW VERIZON WIRELESS 6' Ø
MICROWAVE ANTENNAS, (2) TOTAL

NOTE:
PAINT ALL NEW VERIZON WIRELESS
EQUIPMENT TO MATCH MONOPINE

- NEW VERIZON WIRELESS
150'-0" TALL MONOPINE
- NEW VERIZON WIRELESS
COAX CABLES, (12) TOTAL
- NEW VERIZON WIRELESS
HYBRID CABLES, (2) TOTAL

- BOTTOM OF NEW VERIZON WIRELESS MONOPINE BRANCHES
ELEV. 20'-0" AGL
- NEW VERIZON WIRELESS
8'-0" TALL CMU WALL
- NEW VERIZON WIRELESS
12'-0" WIDE CHAIN-LINK
ACCESS GATE W/ SLATS
- NEW VERIZON WIRELESS
KNOX BOX
- GROUND LEVEL
ELEV. 0'-0" AGL
AGL 0'-0" = 1919' AMSL

SOUTH ELEVATION



SCALE: 1/8" = 1'-0" (24x36)
(OR) 1/16" = 1'-0" (11x17)

 
1

- TOP OF NEW VERIZON WIRELESS MONOPINE BRANCHES
ELEV. 150'-0" AGL
- ELEV. TOP OF NEW VERIZON WIRELESS MONOPINE STRUCTURE
ELEV. 145'-0" AGL
- CENTERLINE OF NEW VERIZON WIRELESS PANEL ANTENNAS
ELEV. 141'-0" AGL
- CENTERLINE OF NEW VERIZON WIRELESS MICROWAVE ANTENNAS
ELEV. 132'-0" AGL
- NEW VERIZON WIRELESS RRUS12 + A2,
(12) TOTAL, (3) PER SECTOR, (8) BEHIND
ANTENNAS, (4) ON RRU DUAL PIPE RING
MOUNT
- NEW VERIZON WIRELESS 6' TALL
ANTENNAS, (12) TOTAL, (3) PER
SECTOR
- NEW VERIZON WIRELESS 6' Ø
MICROWAVE ANTENNAS, (2) TOTAL

- NEW VERIZON WIRELESS
150'-0" TALL MONOPINE
- NEW VERIZON WIRELESS
COAX CABLES, (12) TOTAL
- NEW VERIZON WIRELESS
HYBRID CABLES, (2) TOTAL

- BOTTOM OF NEW VERIZON WIRELESS MONOPINE BRANCHES
ELEV. 20'-0" AGL
- NEW VERIZON WIRELESS
8'-0" TALL CMU WALL
- NEW VERIZON WIRELESS
12'-0" WIDE CHAIN-LINK
ACCESS GATE W/ SLATS
- NEW VERIZON WIRELESS
KNOX BOX
- GROUND LEVEL
ELEV. 0'-0" AGL
AGL 0'-0" = 1919' AMSL
- NEW VERIZON WIRELESS
CMU RETAINING WALL

WEST ELEVATION



SCALE: 1/8" = 1'-0" (24x36)
(OR) 1/16" = 1'-0" (11x17)

2

REVISED Exhibit E-6

ISSUE STATUS

REV.	DATE	DESCRIPTION	BY
0	04/13/15	90% ZONING	FA
1	05/06/15	100% ZONING	FA
2	06/22/15	100% ZONING	NG
3	07/14/15	100% ZONING	NG
4	10/06/16	100% ZONING	FA



SAC AE DESIGN GROUP, INC.
5015 SHOREHAM PLACE, STE. 150
SAN DIEGO, CA 92122
WWW.SACW.COM
619.736.3766

PROPRIETARY INFORMATION

THE INFORMATION CONTAINED IN THIS SET OF
DRAWINGS IS PROPRIETARY & CONFIDENTIAL TO
VERIZON WIRELESS

ANY USE OR DISCLOSURE OTHER THAN AS IT RELATES
TO VERIZON WIRELESS IS STRICTLY PROHIBITED

verizon

2785 MITCHELL DRIVE, BLDG 9
WALNUT CREEK, CA 94598


OUTINGDALE

PSL # 295537


4260 RANCHO MONTES DRIVE
PLACERVILLE, CA 95667

SHEET TITLE:
SOUTH & WEST
ELEVATIONS

A-4

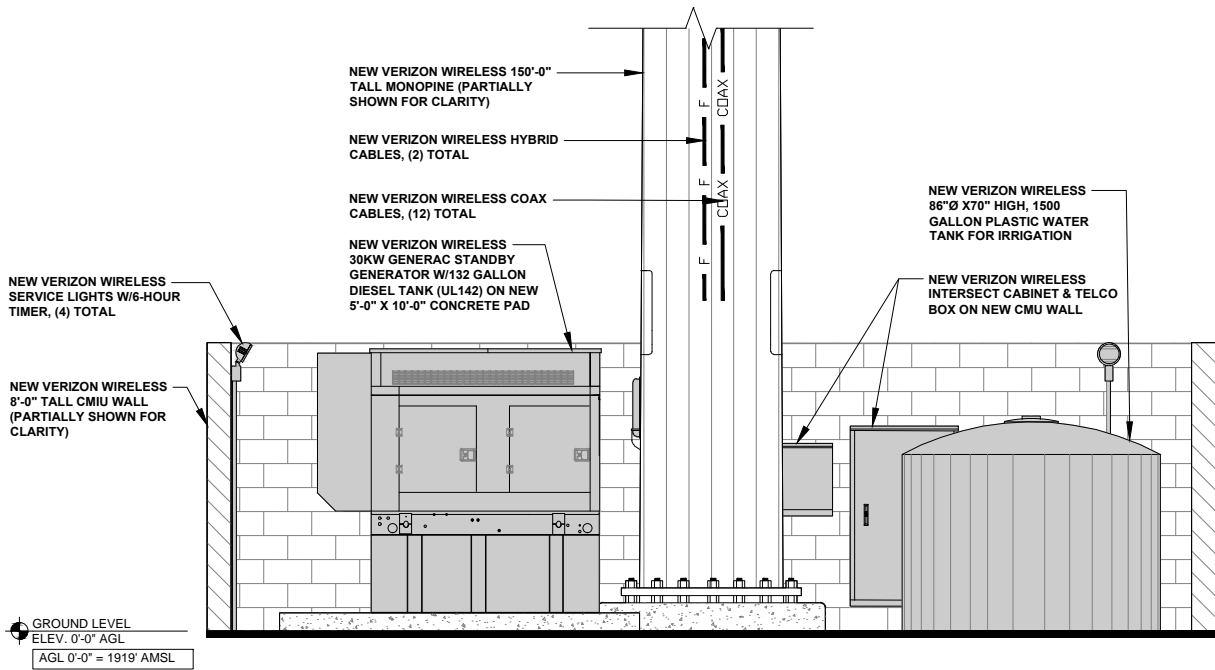


WEST EQUIPMENT ELEVATION

 


SCALE: 3/8" = 1'-0" (24x36)
(OR) 3/16" = 1'-0" (11x17)

4

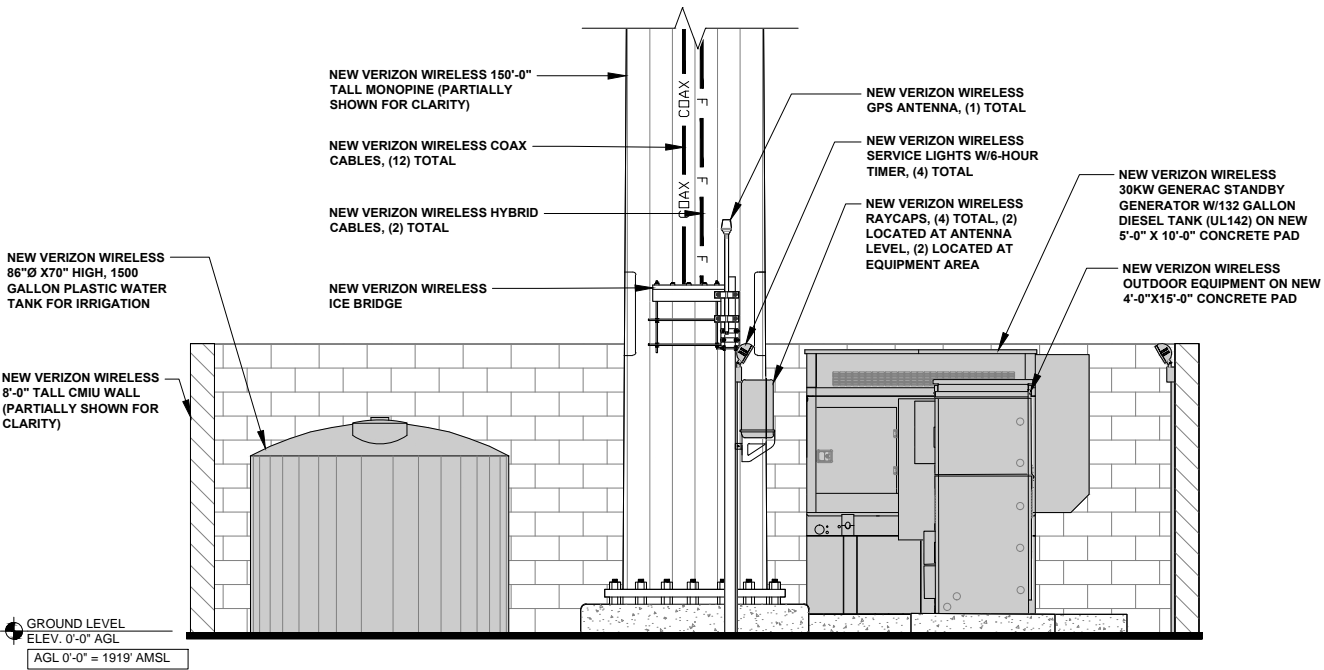


EAST EQUIPMENT ELEVATION

 


SCALE: 3/8" = 1'-0" (24x36)
(OR) 3/16" = 1'-0" (11x17)

2

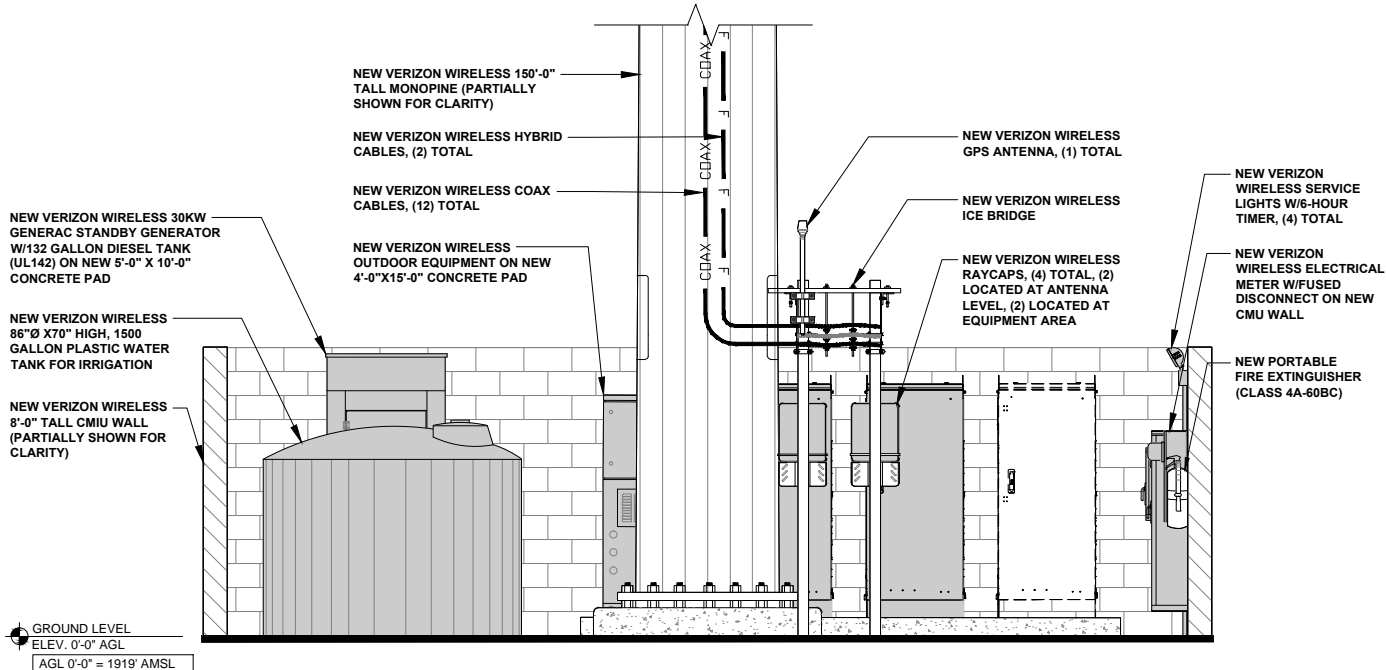


SOUTH EQUIPMENT ELEVATION

 


SCALE: 3/8" = 1'-0" (24x36)
(OR) 3/16" = 1'-0" (11x17)

3

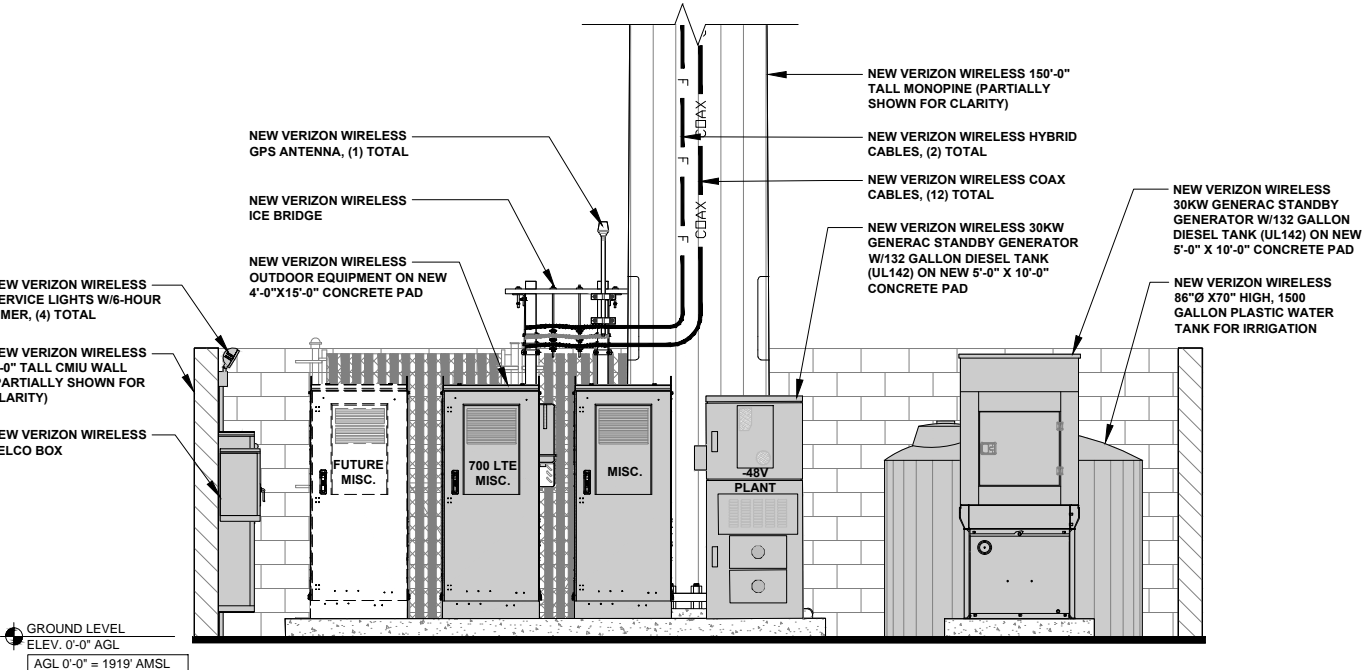

NORTH EQUIPMENT ELEVATION

 

SCALE: 3/4" = 1'-0" (24x36)
(OR) 3/8" = 1'-0" (11x17)

1

REVISED Exhibit E-7

ISSUE STATUS

REV.	DATE	DESCRIPTION	BY
0	04/13/15	90% ZONING	FA
1	05/06/15	100% ZONING	FA
2	06/22/15	100% ZONING	NG
3	07/14/15	100% ZONING	NG
4	10/06/16	100% ZONING	FA



SAC AE DESIGN GROUP, INC.
5015 SHOREHAM PLACE, STE. 150
SAN DIEGO, CA 92122
www.sacw.com
619.736.3766

PROPRIETARY INFORMATION

THE INFORMATION CONTAINED IN THIS SET OF DRAWINGS IS PROPRIETARY & CONFIDENTIAL TO VERIZON WIRELESS
ANY USE OR DISCLOSURE OTHER THAN AS IT RELATES TO VERIZON WIRELESS IS STRICTLY PROHIBITED



2785 MITCHELL DRIVE, BLDG 9
WALNUT CREEK, CA 94598

OUTINGDALE

PSL # 295537

4260 RANCHO MONTES DRIVE
PLACERVILLE, CA 95667

SHEET TITLE:
EQUIPMENT
ELEVATIONS

A-5